



PLANS FOR THE PROPOSED  
**RICHARD ST, ROBERT ST, AND N RUSSELL AVE**  
**WATER MAIN IMPROVEMENTS**  
 FROM FORAN LN TO N RUSSELL AVE


APRIL 2026

GENERALLY LOCATED IN THE N. 1/2 OF SEC 16, T38N, R8E

LEGEND		
EXISTING	PROPOSED	
SANITARY SEWER		
STORM SEWER		
WATER MAIN		
FORCE MAIN		
UNDERDRAIN		
OVERHEAD LINE		
CABLE TV LINE		
GAS LINE		
TELEPHONE LINE		
ELECTRIC LINE		
FENCE		
MAJOR CONTOUR		
MINOR CONTOUR		
HIGH WATER LEVEL		
NORMAL WATER LEVEL		
PAVEMENT FLOW DIRECTION		
SPOT ELEVATION		
TOP OF CURB ELEVATION		
TOP OF FOUNDATION ELEVATION		
GUTTER ELEVATION		
PAVEMENT ELEVATION		
EDGE OF PAVEMENT		
CURB AND GUTTER		
RIGHT-OF-WAY		
SANITARY MANHOLE		
SANITARY CLEANOUT		
STORM MANHOLE		
CATCH BASIN		
INLET		
FLARED END SECTION		
FIRE HYDRANT		
VALVE VAULT		
VALVE BOX		
STREET LIGHT		
POWER POLE		
STREET SIGN		
ELECTRIC BOX		
TELEPHONE BOX		
TELEPHONE MANHOLE		
B-BOX		
GAS VALVE		
TRAFFIC HANDHOLE		
ELECTRIC HANDHOLE		
TREE W/ DIAMETER		
MAILBOX		
STRUCTURE TO BE REMOVED		
PLUG EXISTING PIPE		
UTILITY CROSSING		
EXPLORATORY EXCAVATION LOCATION		
SANITARY MANHOLE REHABILITATION NUMBER		
SOIL BORING LOCATION WITH IDENTIFICATION NUMBER & ELEVATION		

INDEX OF SHEETS

- 1-2 COVER SHEET & OVERALL PLAN
- 3-15 PLAN AND PROFILE
- 16-20 STANDARD DETAILS

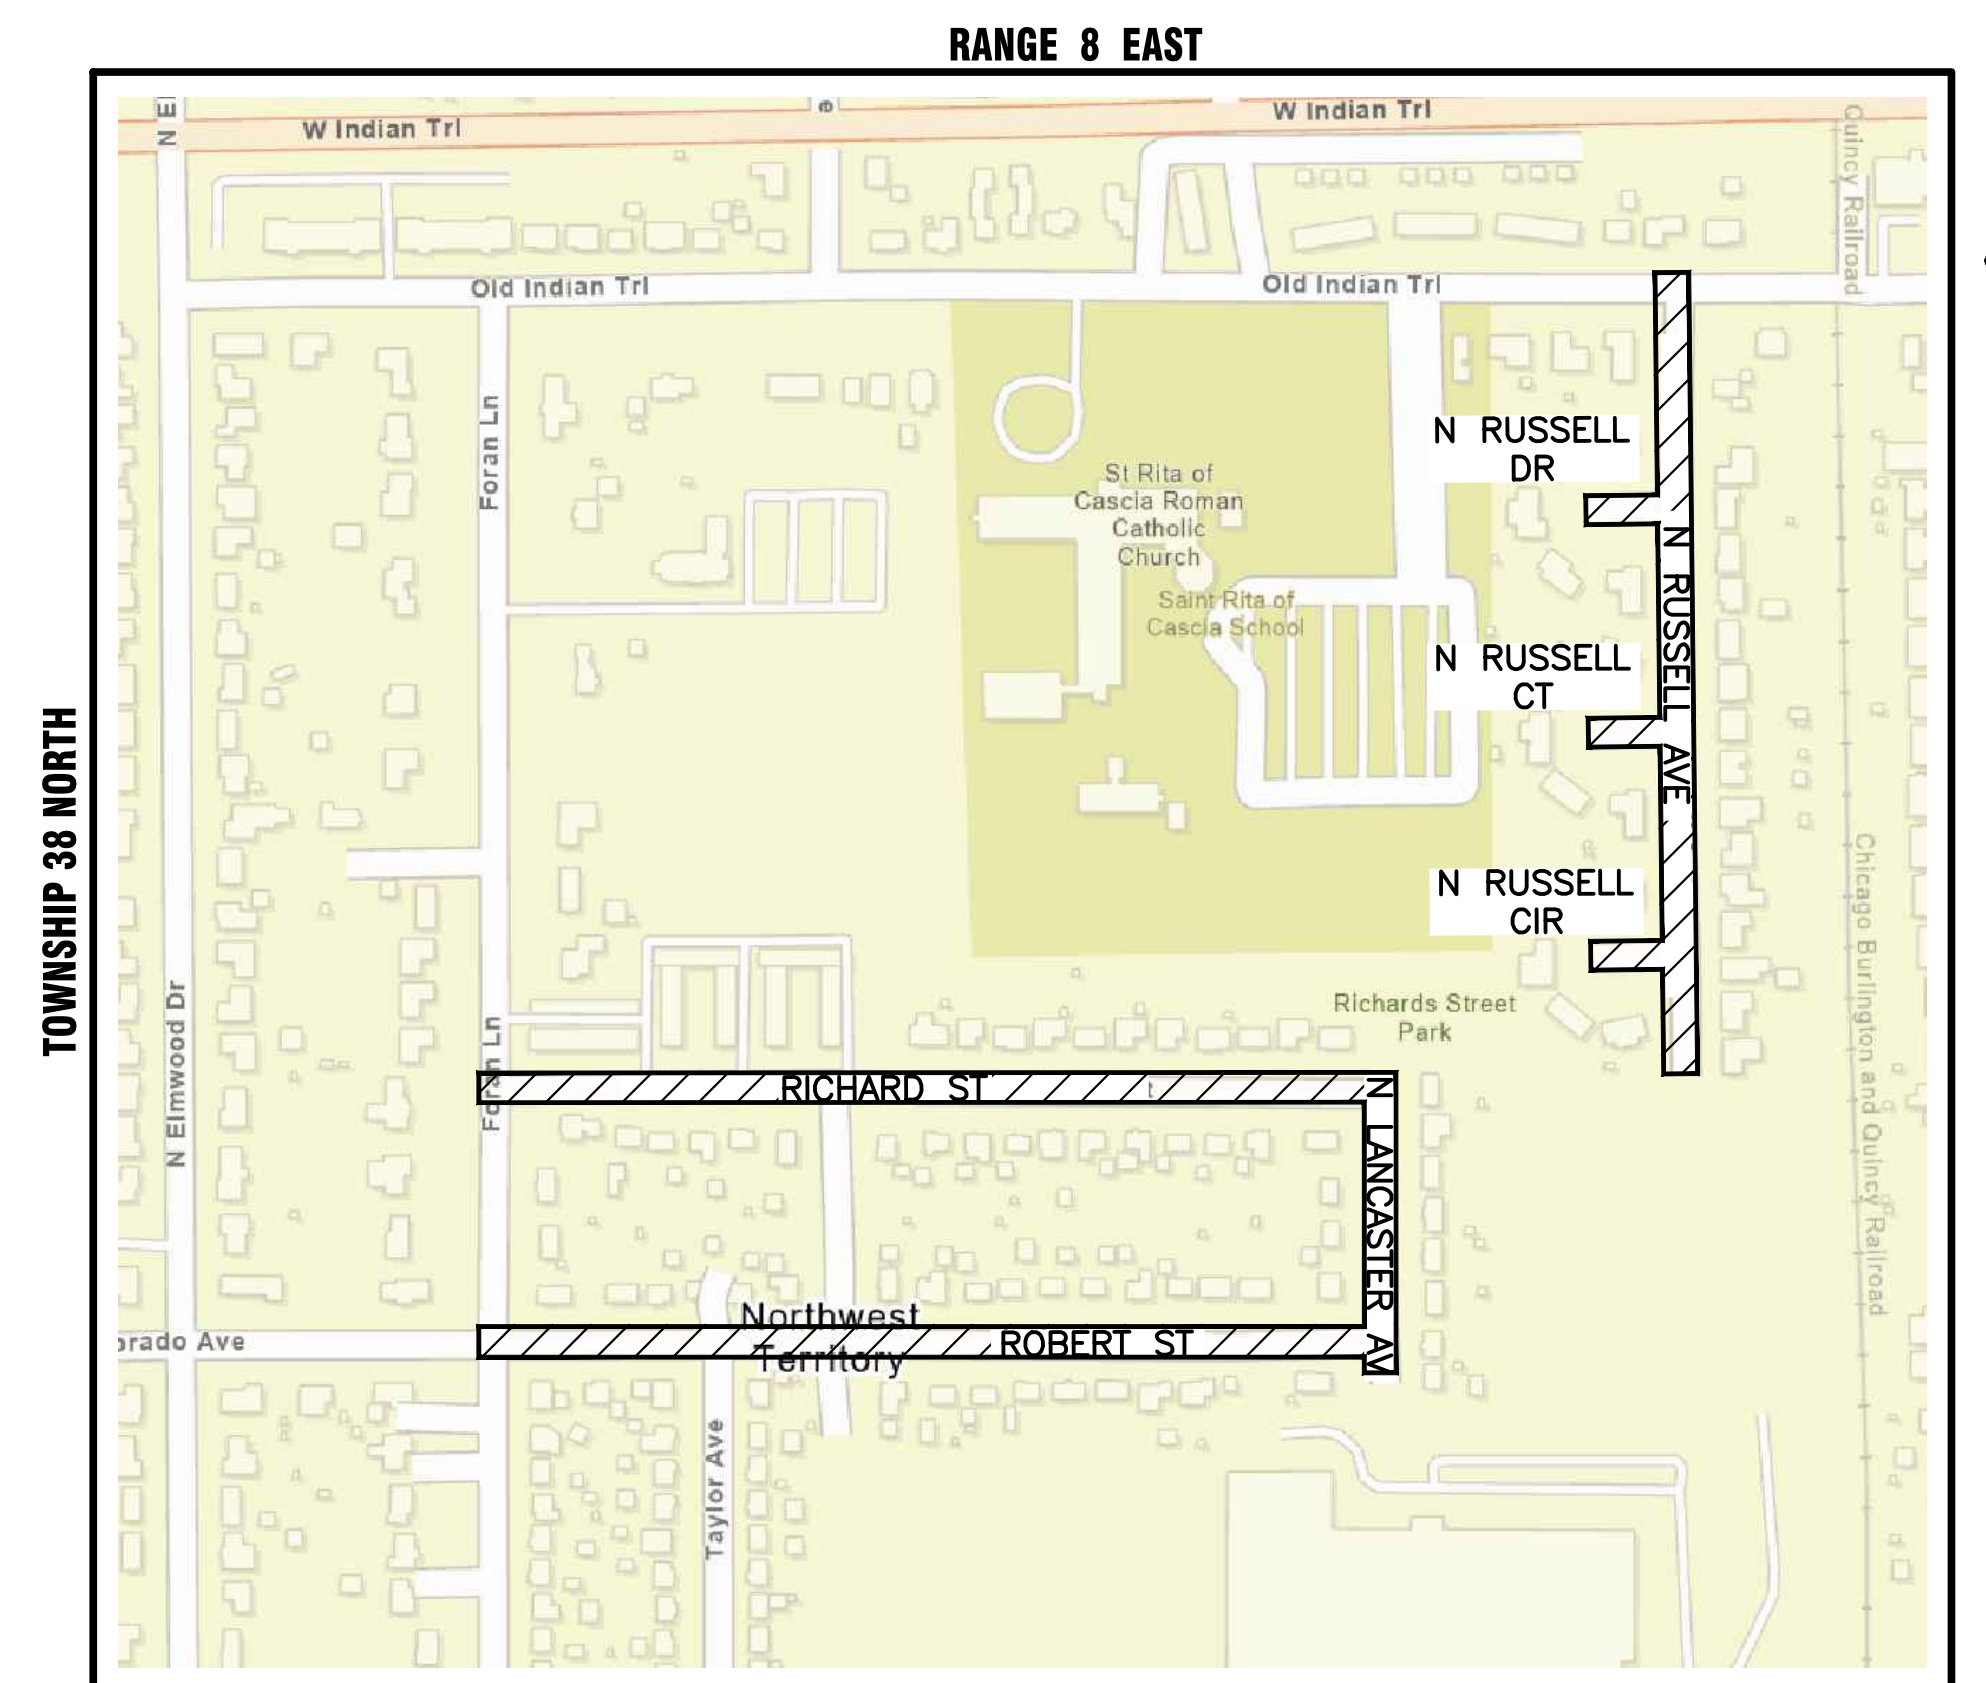

DUPAGE COUNTY - AURORA & NAPERVILLE  
 THIRD PRINCIPAL MERIDIAN

LOCATION MAP  
 NOT TO SCALE

Dial 811 or 1-800-892-0123



Know what's below.  
 Call before you dig.

J.U.L.I.E.  
 JOINT UTILITY LOCATION INFORMATION FOR EXCAVATION  
 811 OR 1-800-892-0123

CONSTRUCTION AND MAINTENANCE TO BE IN  
 ACCORDANCE WITH ALL APPLICABLE REGULATORY  
 REQUIREMENTS AND STANDARDS

**PRINTED BY THE AUTHORITY  
 OF THE CITY OF AURORA**

PLANS PREPARED BY:

**CITY OF AURORA**

DEPARTMENT OF PUBLIC WORKS - ENGINEERING DIVISION  
 2185 LIBERTY ST, AURORA, IL 60505

PHONE: 630-256-3200 FAX: 630-256-3229

REVISIONS:

DESIGNED BY: NLS	DRAWN BY: AHB	CHECKED BY: KTM	APPROVED BY: KTM	HORIZ. SCALE: N/A	DATE: APRIL 2026
				VERT. SCALE: N/A	

STAMP	DATE
ILLINOIS REGISTERED PROFESSIONAL	
ENGINEER No. 062.070660	
LICENSE EXPIRES NOVEMBER 30, 2027	