


NO.	DESCRIPTION	QTY	UNIT	PRICE	TOTAL
1	RECEIPT - SALE AREA POS	20	1	1.00	20.00
2	RECEIPT - SALE AREA POS	20	1	1.00	20.00
3	RECEIPT - STATION	20	1	1.00	20.00
4	RECEIPT - STATION	20	1	1.00	20.00
5	RECEIPT - STATION	20	1	1.00	20.00
100	RECEIPT - STATION	20	1	1.00	20.00


5. E.C. TO UTILIZE ALL EXISTING 2015AMPS 1P BRANCH CIRCUIT BREAKERS FOR NEW CXTS. ALL 2P AND 3P BRANCH BREAKERS ARE NEW FOR NEW CXTS. (NOT ON EXISTING).
6. PROVIDE COPPER CONDUCTOR BRANCH CIRCUIT WIRING FOR THE FOLLOWING AS A MINIMUM. VALUES NOTED OTHERWISE.
 - 20A - #12AWG IN 3/4" C MINIMUM
 - 30A - #10AWG IN 3/4" C MINIMUM
 - 40A TO 50A - #8AWG IN 3/4" C MINIMUM
 - 60A - #6AWG IN 3/4" C MINIMUM
7. ALL ELECTRICAL OUTLETS, SWITCHES, TO BE LABELED BY PANEL & CIRCUIT FOR MAINTENANCE AND TROUBLESHOOTING.

GENERAL NOTES

1. E.C. TO PROVIDE MATCHING RECEPTACLE OUTLET WITH EQUIPMENT PLUG TYPE OF EACH PIECE EQUIPMENT WITH MANUFACTURERS COT SHEET

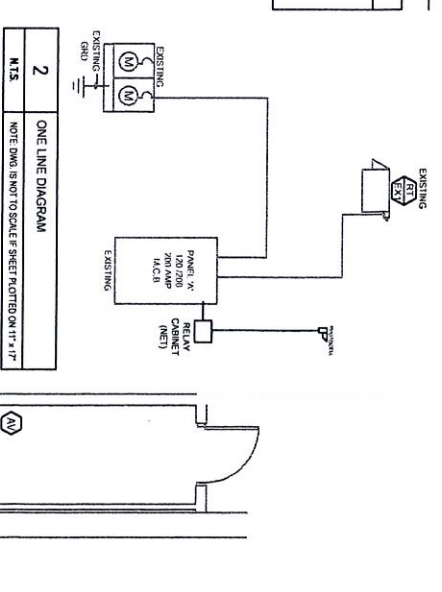

2 ONE LINE DIAGRAM
NOTE: OWN. (NOT TO SCALE) SHEET PLOTTED ON 11" x 17"

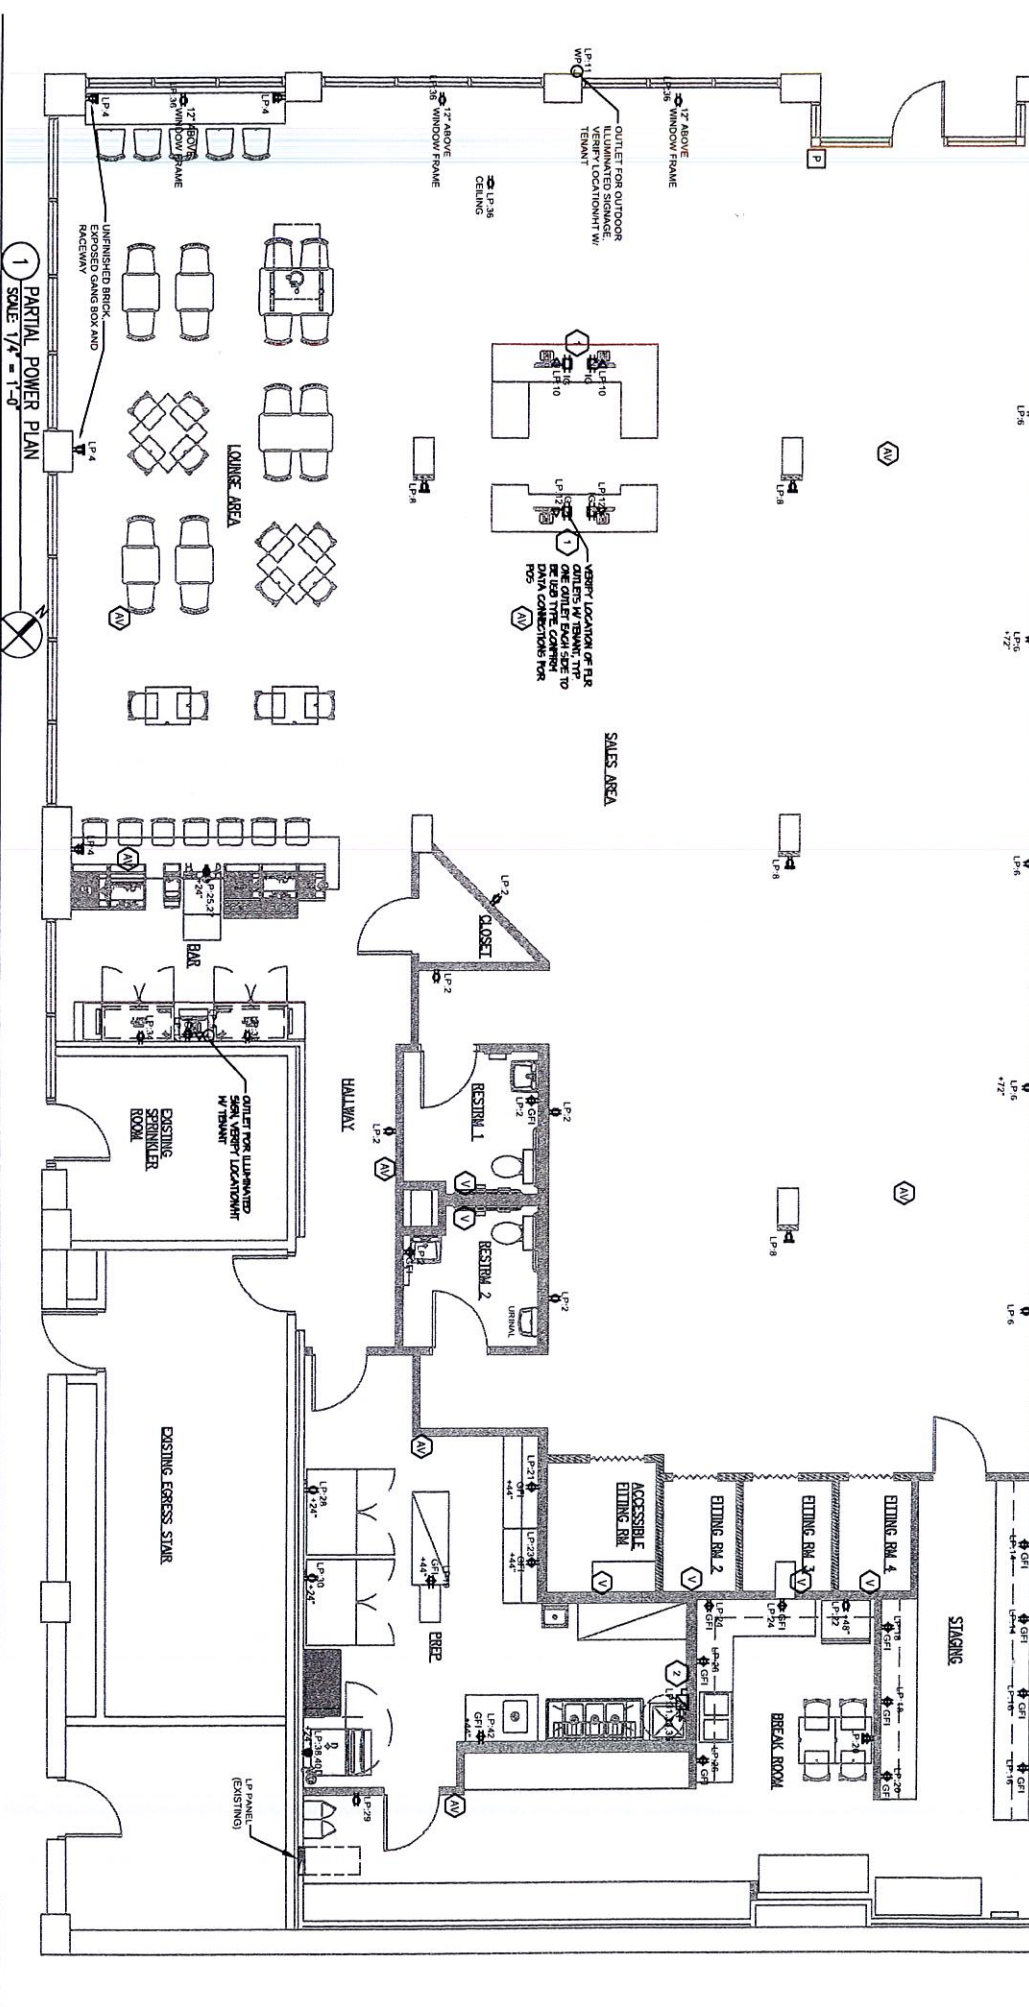

1 PARTIAL POWER PLAN
SCALE 1/4" = 1'-0"