



FIRE ACCESS PLAN FOR CINCO DE MAYO SUBDIVISION

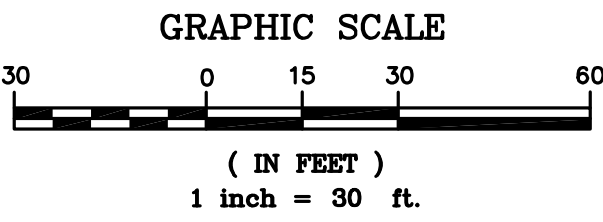

SCALE: 1" = 30'

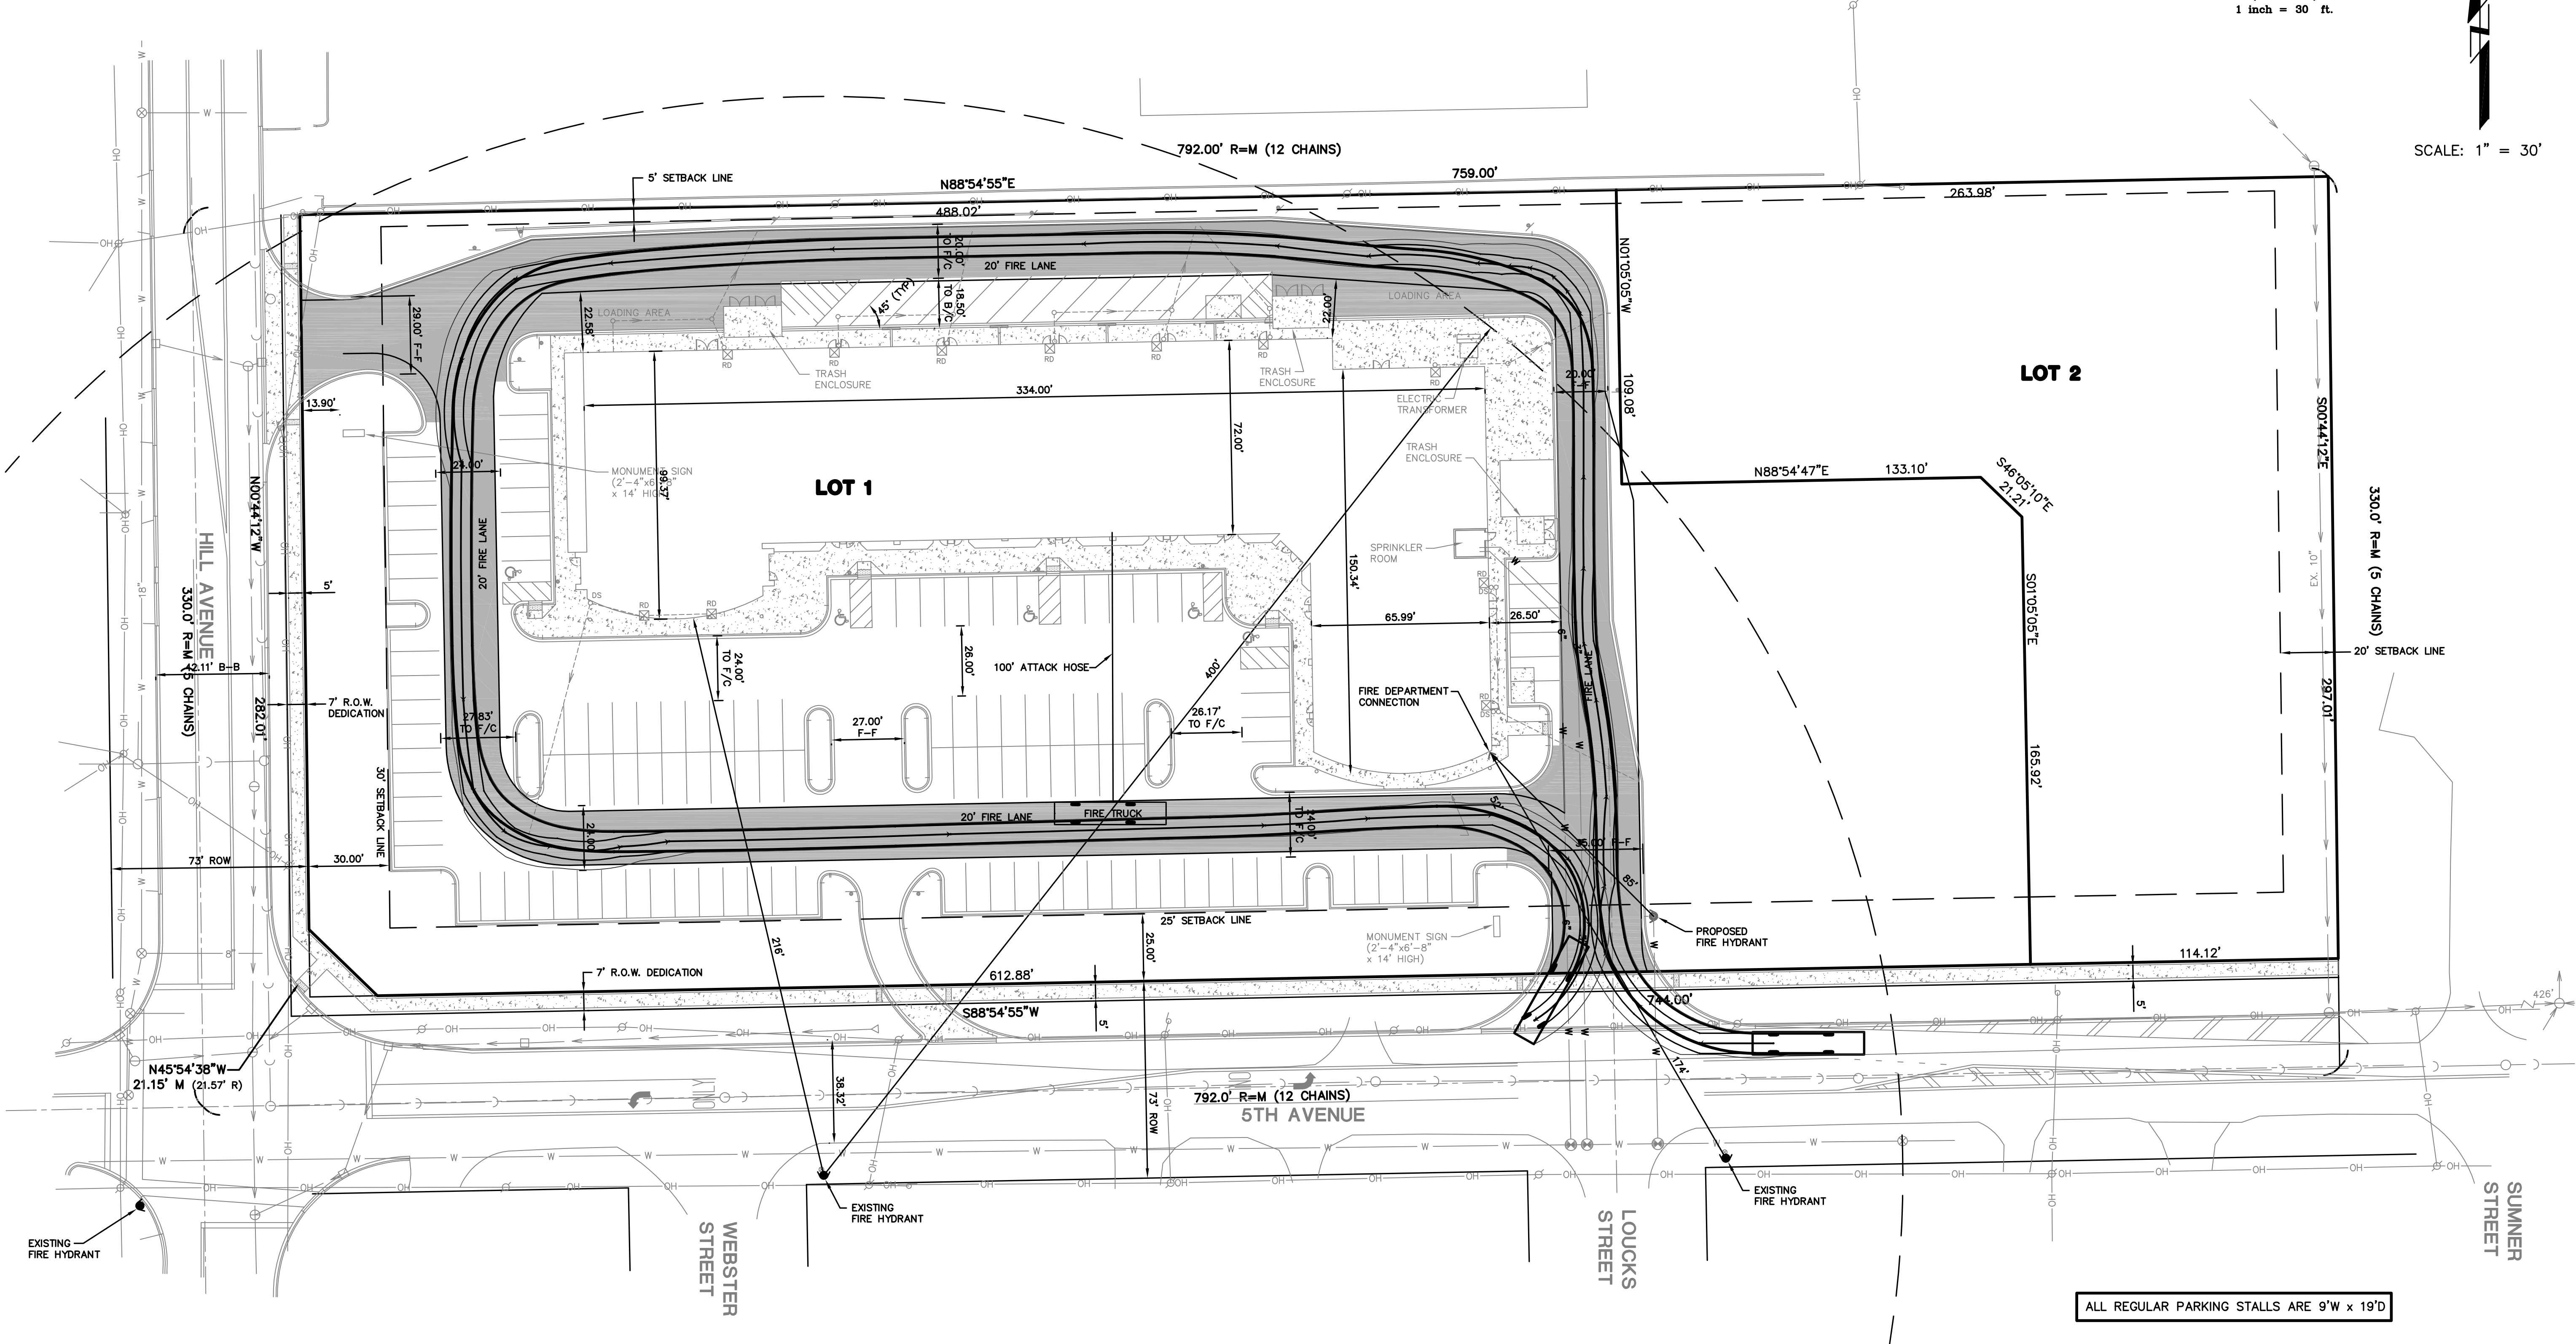

FIRE APPARATUS ACCESS PAVEMENT

1. 1.5" HOT MIX ASPHALT SURFACE COURSE, MIX C, N-50
2. 4.5" HOT MIX ASPHALT BINDER COURSE, MIX C, N-50
3. BITUMINOUS MATERIALS (PRIME COAT) 0.3 GAL/SY
4. 10" AGGREGATE BASE COURSE, TY B, CA-6

AURORA

Width : 8.33
Track : 7.50
Lock to Lock Time : 6.00
Steering Angle : 40.00

LEGEND

- FIRE HYDRANT
- VALVE IN VAULT
- FIRE APPARATUS ACCESS ROAD

Fire Access Plan Data Table		
Description	Value	Unit
a) Building Height	20.00	feet
b) Building Square Footage (typical)	30,026	square feet
c) Building fire suppression information including any proposed use of sprinkler systems, fire alarm systems, whether fire extinguishers are needed. Full sprinklers and fire detection per NFPA.		
d) General description of business to be conducted within each building including: will there be rack storage in the building, will there be storage of combustible materials over twelve feet in height, clearance of sprinkler heads and stored materials (18 inch minimum): BUILDING 1: Unit 1 +/- 5,000 sf, Bakery, Units 2-9 and 11-14 General Retail +/- 1400 sf each, Unit 10:		

INTECH CONSULTANTS, INC.
ENGINEERS - SURVEYORS
1989 UNIVERSITY LANE, SUITE D
LISLE, ILLINOIS 60532
PHONE: 630-964-5556
ILLINOIS REGISTRATION NO. 184-001440

OWNER & PETITIONER:
GERARDO PARRA
215 JACKSON STREET
AURORA, ILLINOIS 60505

**CINCO DE MAYO
RETAIL CENTER**

**FIRE ACCESS PLAN
FOR CINCO DE MAYO
SUBDIVISION**

SCALE: 1"=30'
DATE: 03-29-16
DRAWN: SJP
DESIGNED: CP
PROJECT NO.: 2015-011
SHEET 1 OF 1