
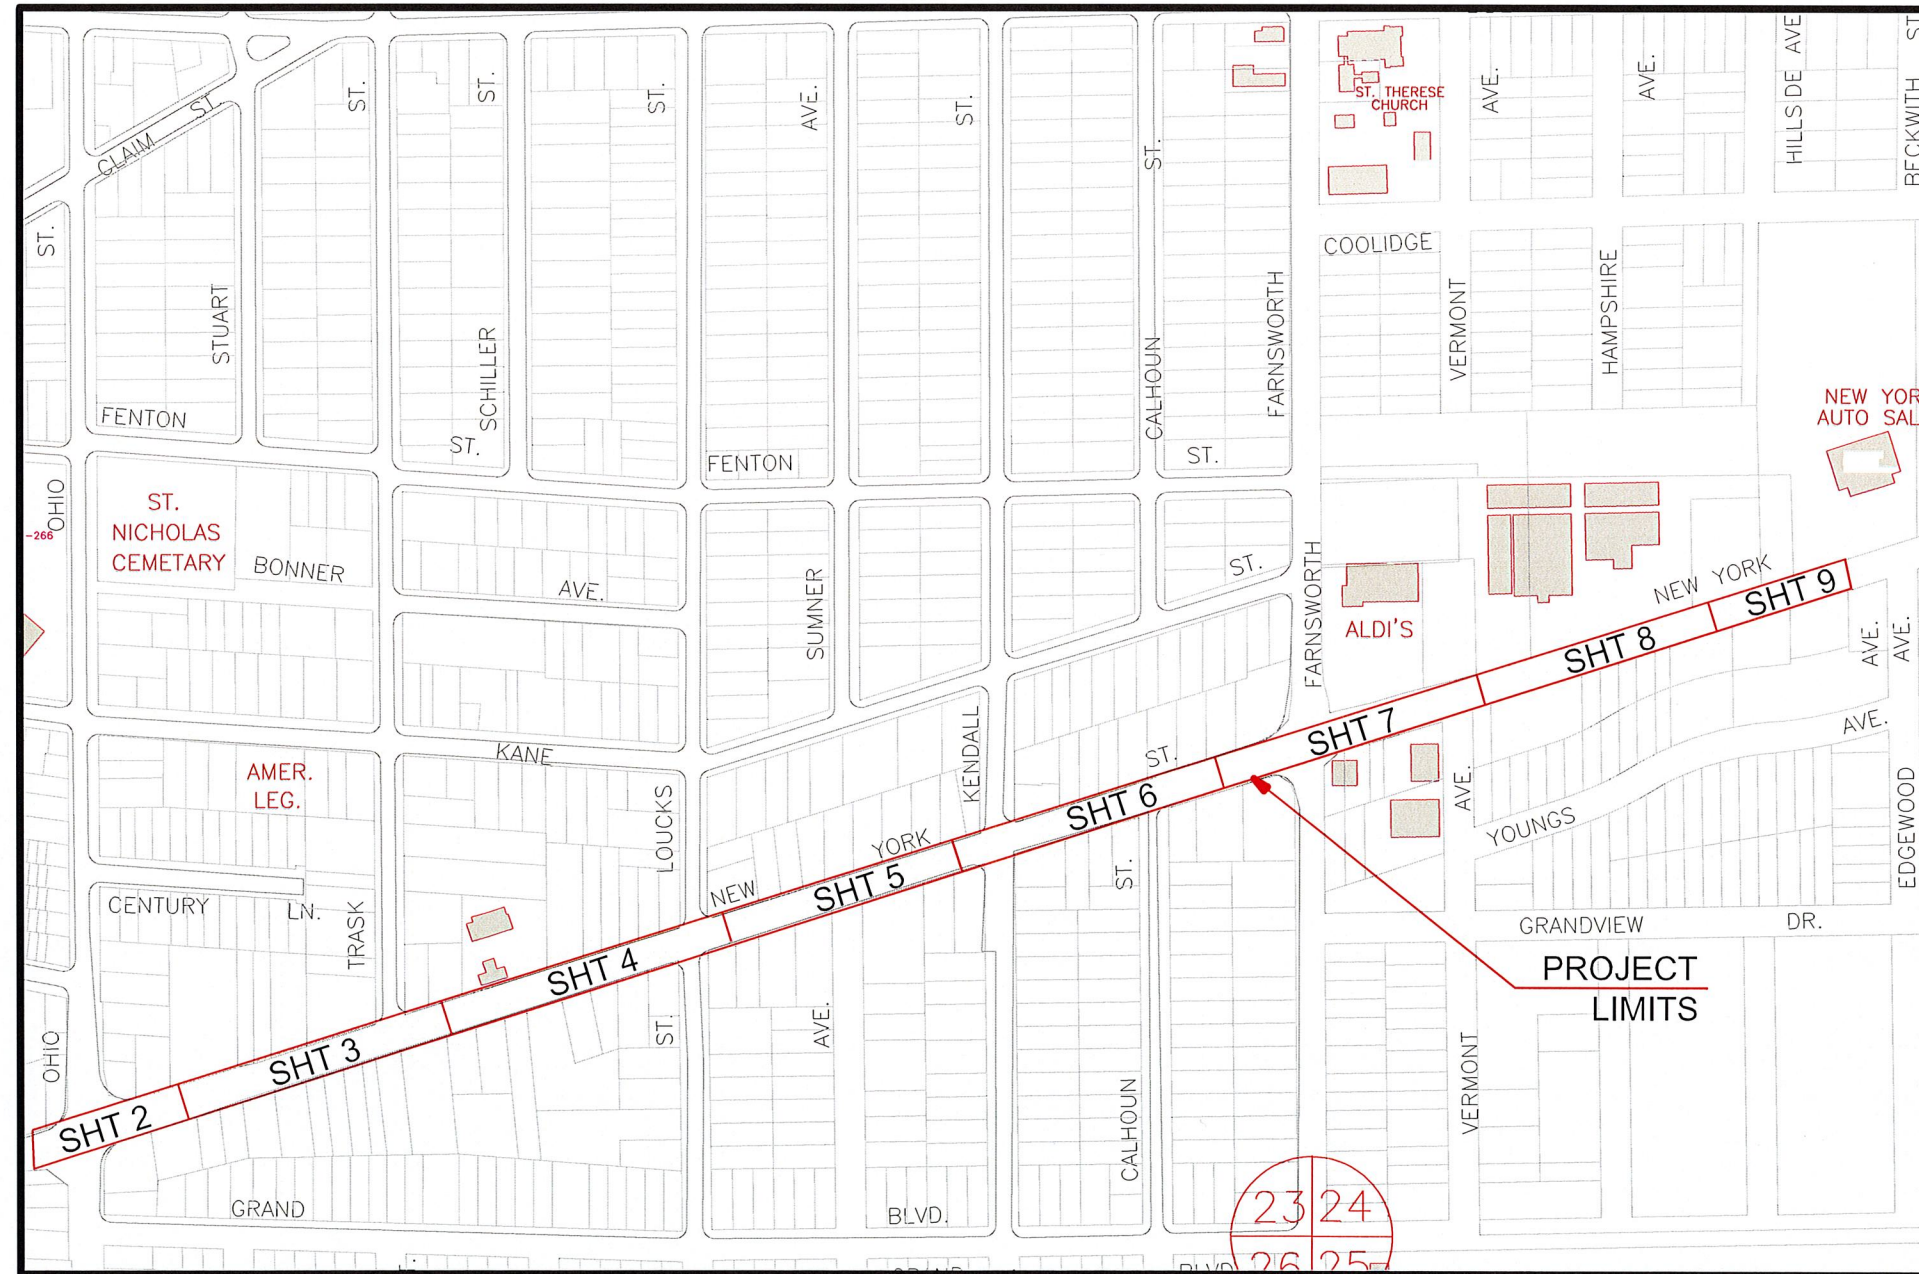


E. NEW YORK ST WATER MAIN REPLACEMENT - OHIO ST TO EDGEWOOD AVE


JANUARY, 2022

GENERALLY LOCATED: SE 1/4 SEC 23 & SW 1/4 SEC 24, T38N, R8E AURORA TOWNSHIP

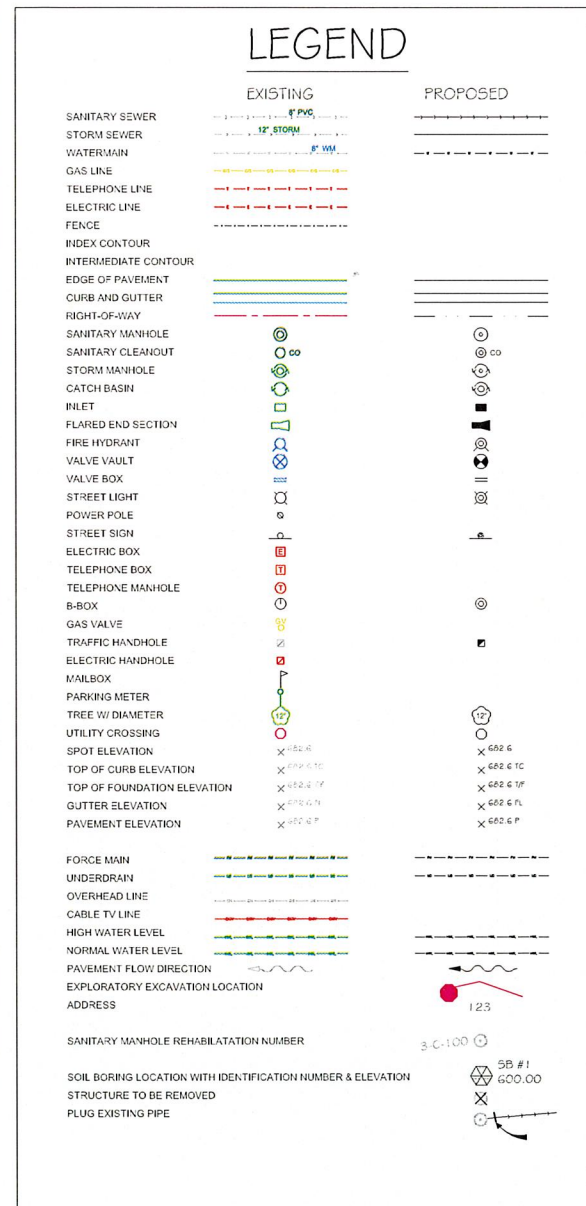

INDEX OF SHEETS

- 1 COVER SHEET
- 2-9 PLAN AND PROFILE
- 10-13 STANDARD
DETAIL SHEETS

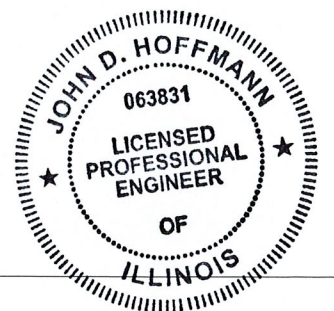

PLANS PREPARED BY:

CITY OF AURORA

DEPARTMENT OF PUBLIC WORKS, DIVISION OF ENGINEERING

77 S. BROADWAY AVE. - AURORA, IL

PHONE: 630-256-3200 FAX: 630-256-3229

REVISIONS:

DESIGNED BY: JDH	DRAWN BY: OTHERS	CHECKED BY: KTM	APPROVED BY: JMB	HORIZ. SCALE: N/A	VERT. SCALE: N/A	DATE: JAN 2022
------------------	------------------	-----------------	------------------	-------------------	------------------	----------------

[Signature]
ILLINOIS REGISTERED PROFESSIONAL

ENGINEER No. 062-63831
LICENSE EXPIRES NOVEMBER 30, 2023

1-10-22