


CALIFORNIA AVE WATER MAIN REPLACEMENT

MARCH, 2023

GENERALLY LOCATED: E 1/2 SECTION 17, T38N, R8E AURORA TOWNSHIP

LEGEND		
	EXISTING	PROPOSED
SANITARY SEWER		
STORM SEWER		
WATERMAIN		
GAS LINE		
TELEPHONE LINE		
ELECTRIC LINE		
FENCE		
INDEX CONTOUR		
INTERMEDIATE CONTOUR		
EDGE OF PAVEMENT		
CURB AND GUTTER		
RIGHT-OF-WAY		
SANITARY MANHOLE		
SANITARY CLEANOUT		
STORM MANHOLE		
CATCH BASIN		
INLET		
FLARED END SECTION		
FIRE HYDRANT		
VALVE VAULT		
VALVE BOX		
STREET LIGHT		
POWER POLE		
STREET SIGN		
ELECTRIC BOX		
TELEPHONE BOX		
TELEPHONE MANHOLE		
B-BOX		
GAS VALVE		
TRAFFIC HANDHOLE		
ELECTRIC HANDHOLE		
MAILBOX		
PARKING METER		
TREE W/ DIAMETER		
UTILITY CROSSING		
SPOT ELEVATION		
TOP OF CURB ELEVATION		
TOP OF FOUNDATION ELEVATION		
GUTTER ELEVATION		
PAVEMENT ELEVATION		
FORCE MAIN		
UNDERDRAIN		
OVERHEAD LINE		
CABLE TV LINE		
HIGH WATER LEVEL		
NORMAL WATER LEVEL		
PAVEMENT FLOW DIRECTION		
EXPLORATORY EXCAVATION LOCATION		
ADDRESS		
SANITARY MANHOLE REHABILITATION NUMBER		
SOIL BORING LOCATION WITH IDENTIFICATION NUMBER & ELEVATION		
STRUCTURE TO BE REMOVED		
PLUG EXISTING PIPE		

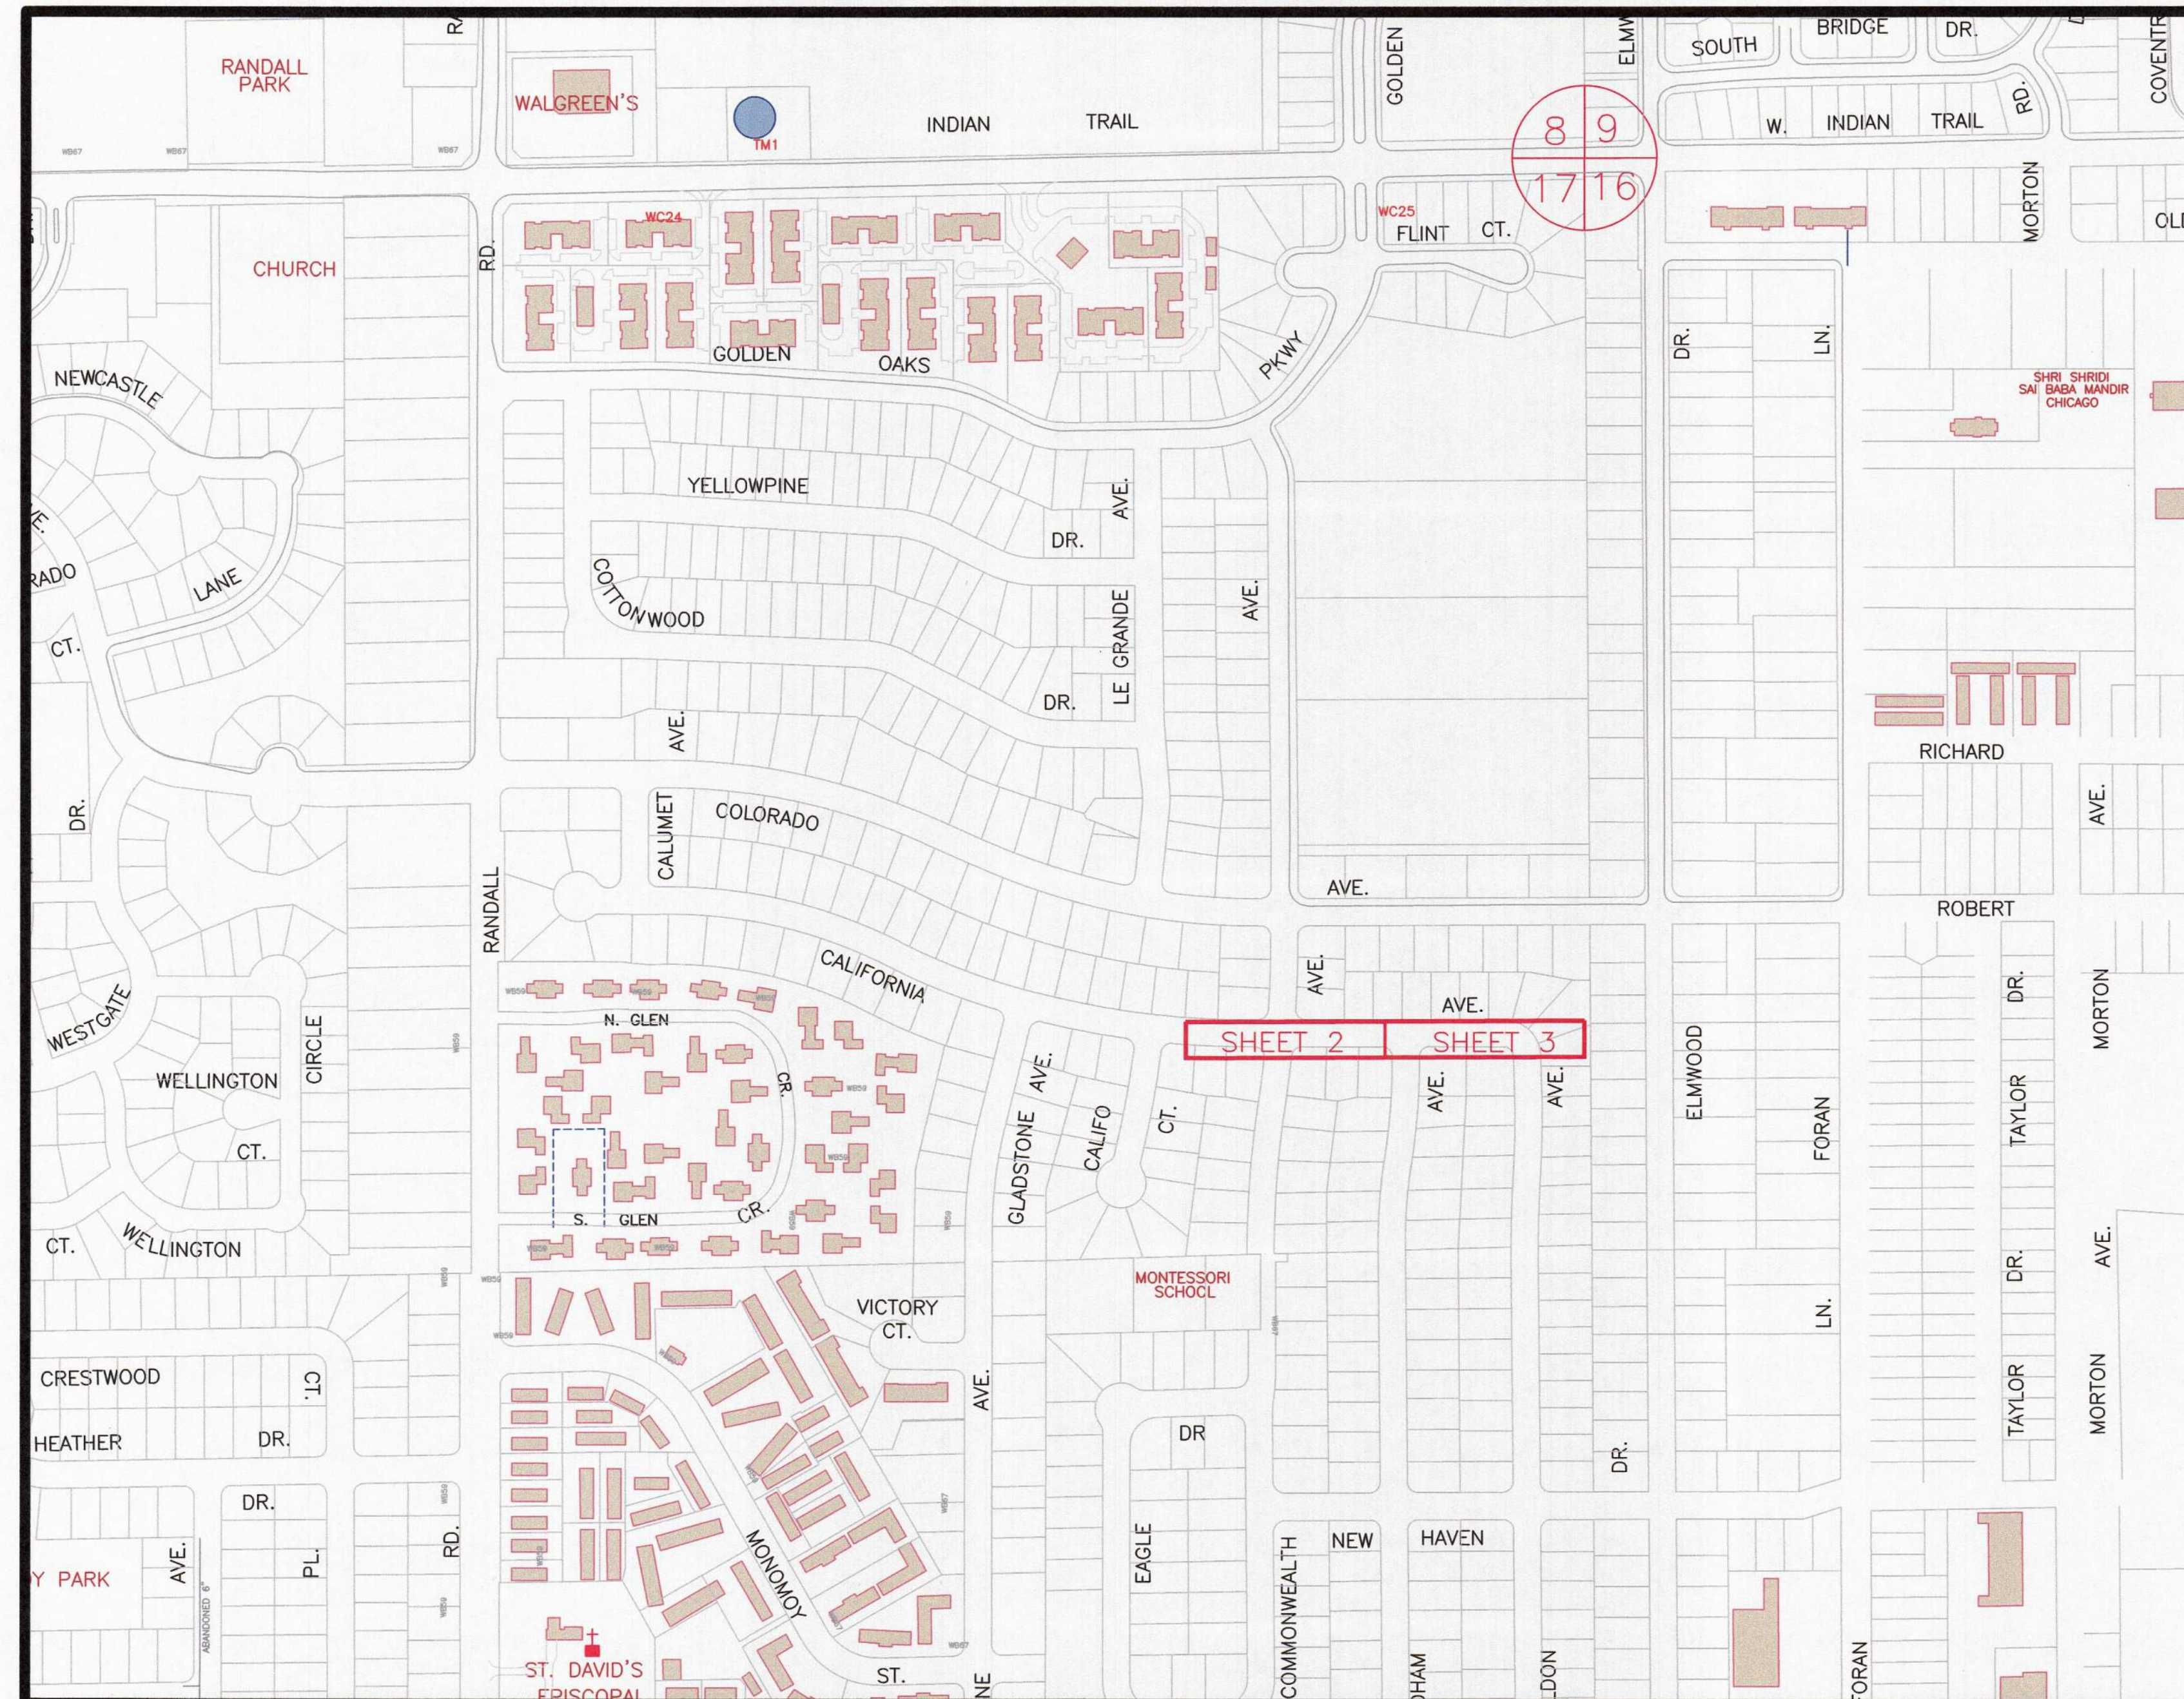

INDEX OF SHEETS

- 1 COVER SHEET
- 2-3 PLAN AND PROFILE
- 4-7 STANDARD DETAIL SHEETS

PLANS PREPARED BY:

CITY OF AURORA


DEPARTMENT OF PUBLIC WORKS, DIVISION OF ENGINEERING
77 S. BROADWAY AVE. - AURORA, IL

PHONE: 630-256-3200 FAX: 630-256-3229

REVISIONS:

DESIGNED BY: KTM	DRAWN BY: AH	CHECKED BY: JMB	APPROVED BY: JMB	HORIZ. SCALE: N/A	VERT. SCALE: N/A	DATE: 3/2023
------------------	--------------	-----------------	------------------	-------------------	------------------	--------------

Kurtis T. Muth
ILLINOIS REGISTERED PROFESSIONAL
ENGINEER No. 062-59993
LICENSE EXPIRES NOVEMBER 30, 2023

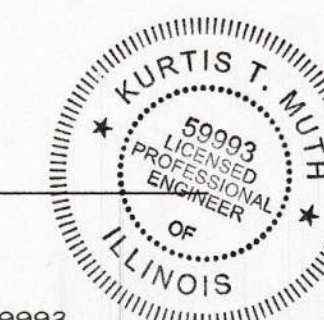

3/6/23