


TALL OAKS SUBDIVISION WATER MAIN REPLACEMENT - PHASE 2

JANUARY, 2018

GENERALLY LOCATED: NW 1/4 SECTION 22, T38N, R8E, AURORA TOWNSHIP

LEGEND

	EXISTING	PROPOSED
SANITARY SEWER	--- 8" PVC ---	--- ---
STORM SEWER	--- 12" STORM ---	--- ---
WATERMAIN	--- 8" WY ---	--- ---
GAS LINE	--- ---	--- ---
TELEPHONE LINE	--- ---	--- ---
ELECTRIC LINE	--- ---	--- ---
FENCE	--- ---	--- ---
INDEX CONTOUR	--- ---	--- ---
INTERMEDIATE CONTOUR	--- ---	--- ---
EDGE OF PAVEMENT	--- ---	--- ---
CURB AND GUTTER	--- ---	--- ---
RIGHT-OF-WAY	--- ---	--- ---
SANITARY MANHOLE	⊙	⊙
SANITARY CLEANOUT	⊙	⊙
STORM MANHOLE	⊙	⊙
CATCH BASIN	⊙	⊙
INLET	⊙	⊙
FLARED END SECTION	⊙	⊙
FIRE HYDRANT	⊙	⊙
VALVE VAULT	⊙	⊙
VALVE BOX	⊙	⊙
STREET LIGHT	⊙	⊙
POWER POLE	⊙	⊙
STREET SIGN	⊙	⊙
ELECTRIC BOX	⊙	⊙
TELEPHONE BOX	⊙	⊙
TELEPHONE MANHOLE	⊙	⊙
B-BOX	⊙	⊙
GAS VALVE	⊙	⊙
TRAFFIC HANDHOLE	⊙	⊙
ELECTRIC HANDHOLE	⊙	⊙
MAILBOX	⊙	⊙
PARKING METER	⊙	⊙
TREE W/ DIAMETER	⊙	⊙
UTILITY CROSSING	⊙	⊙
SPOT ELEVATION	X 682.6	X 682.6
TOP OF CURB ELEVATION	X 682.6 TC	X 682.6 TC
TOP OF FOUNDATION ELEVATION	X 682.6 TF	X 682.6 TF
GUTTER ELEVATION	X 682.6 FL	X 682.6 FL
PAVEMENT ELEVATION	X 682.6 F	X 682.6 F
FORCE MAIN	--- ---	--- ---
UNDERDRAIN	--- ---	--- ---
OVERHEAD LINE	--- ---	--- ---
CABLE TV LINE	--- ---	--- ---
HIGH WATER LEVEL	--- ---	--- ---
NORMAL WATER LEVEL	--- ---	--- ---
PAVEMENT FLOW DIRECTION	--- ---	--- ---
EXPLORATORY EXCAVATION LOCATION	⊙	⊙
ADDRESS	123	123
SANITARY MANHOLE REHABILITATION NUMBER	3-C-100	3-C-100
SOIL BORING LOCATION WITH IDENTIFICATION NUMBER & ELEVATION	SB #1 600.00	SB #1 600.00
STRUCTURE TO BE REMOVED	⊙	⊙
PLUG EXISTING PIPE	⊙	⊙

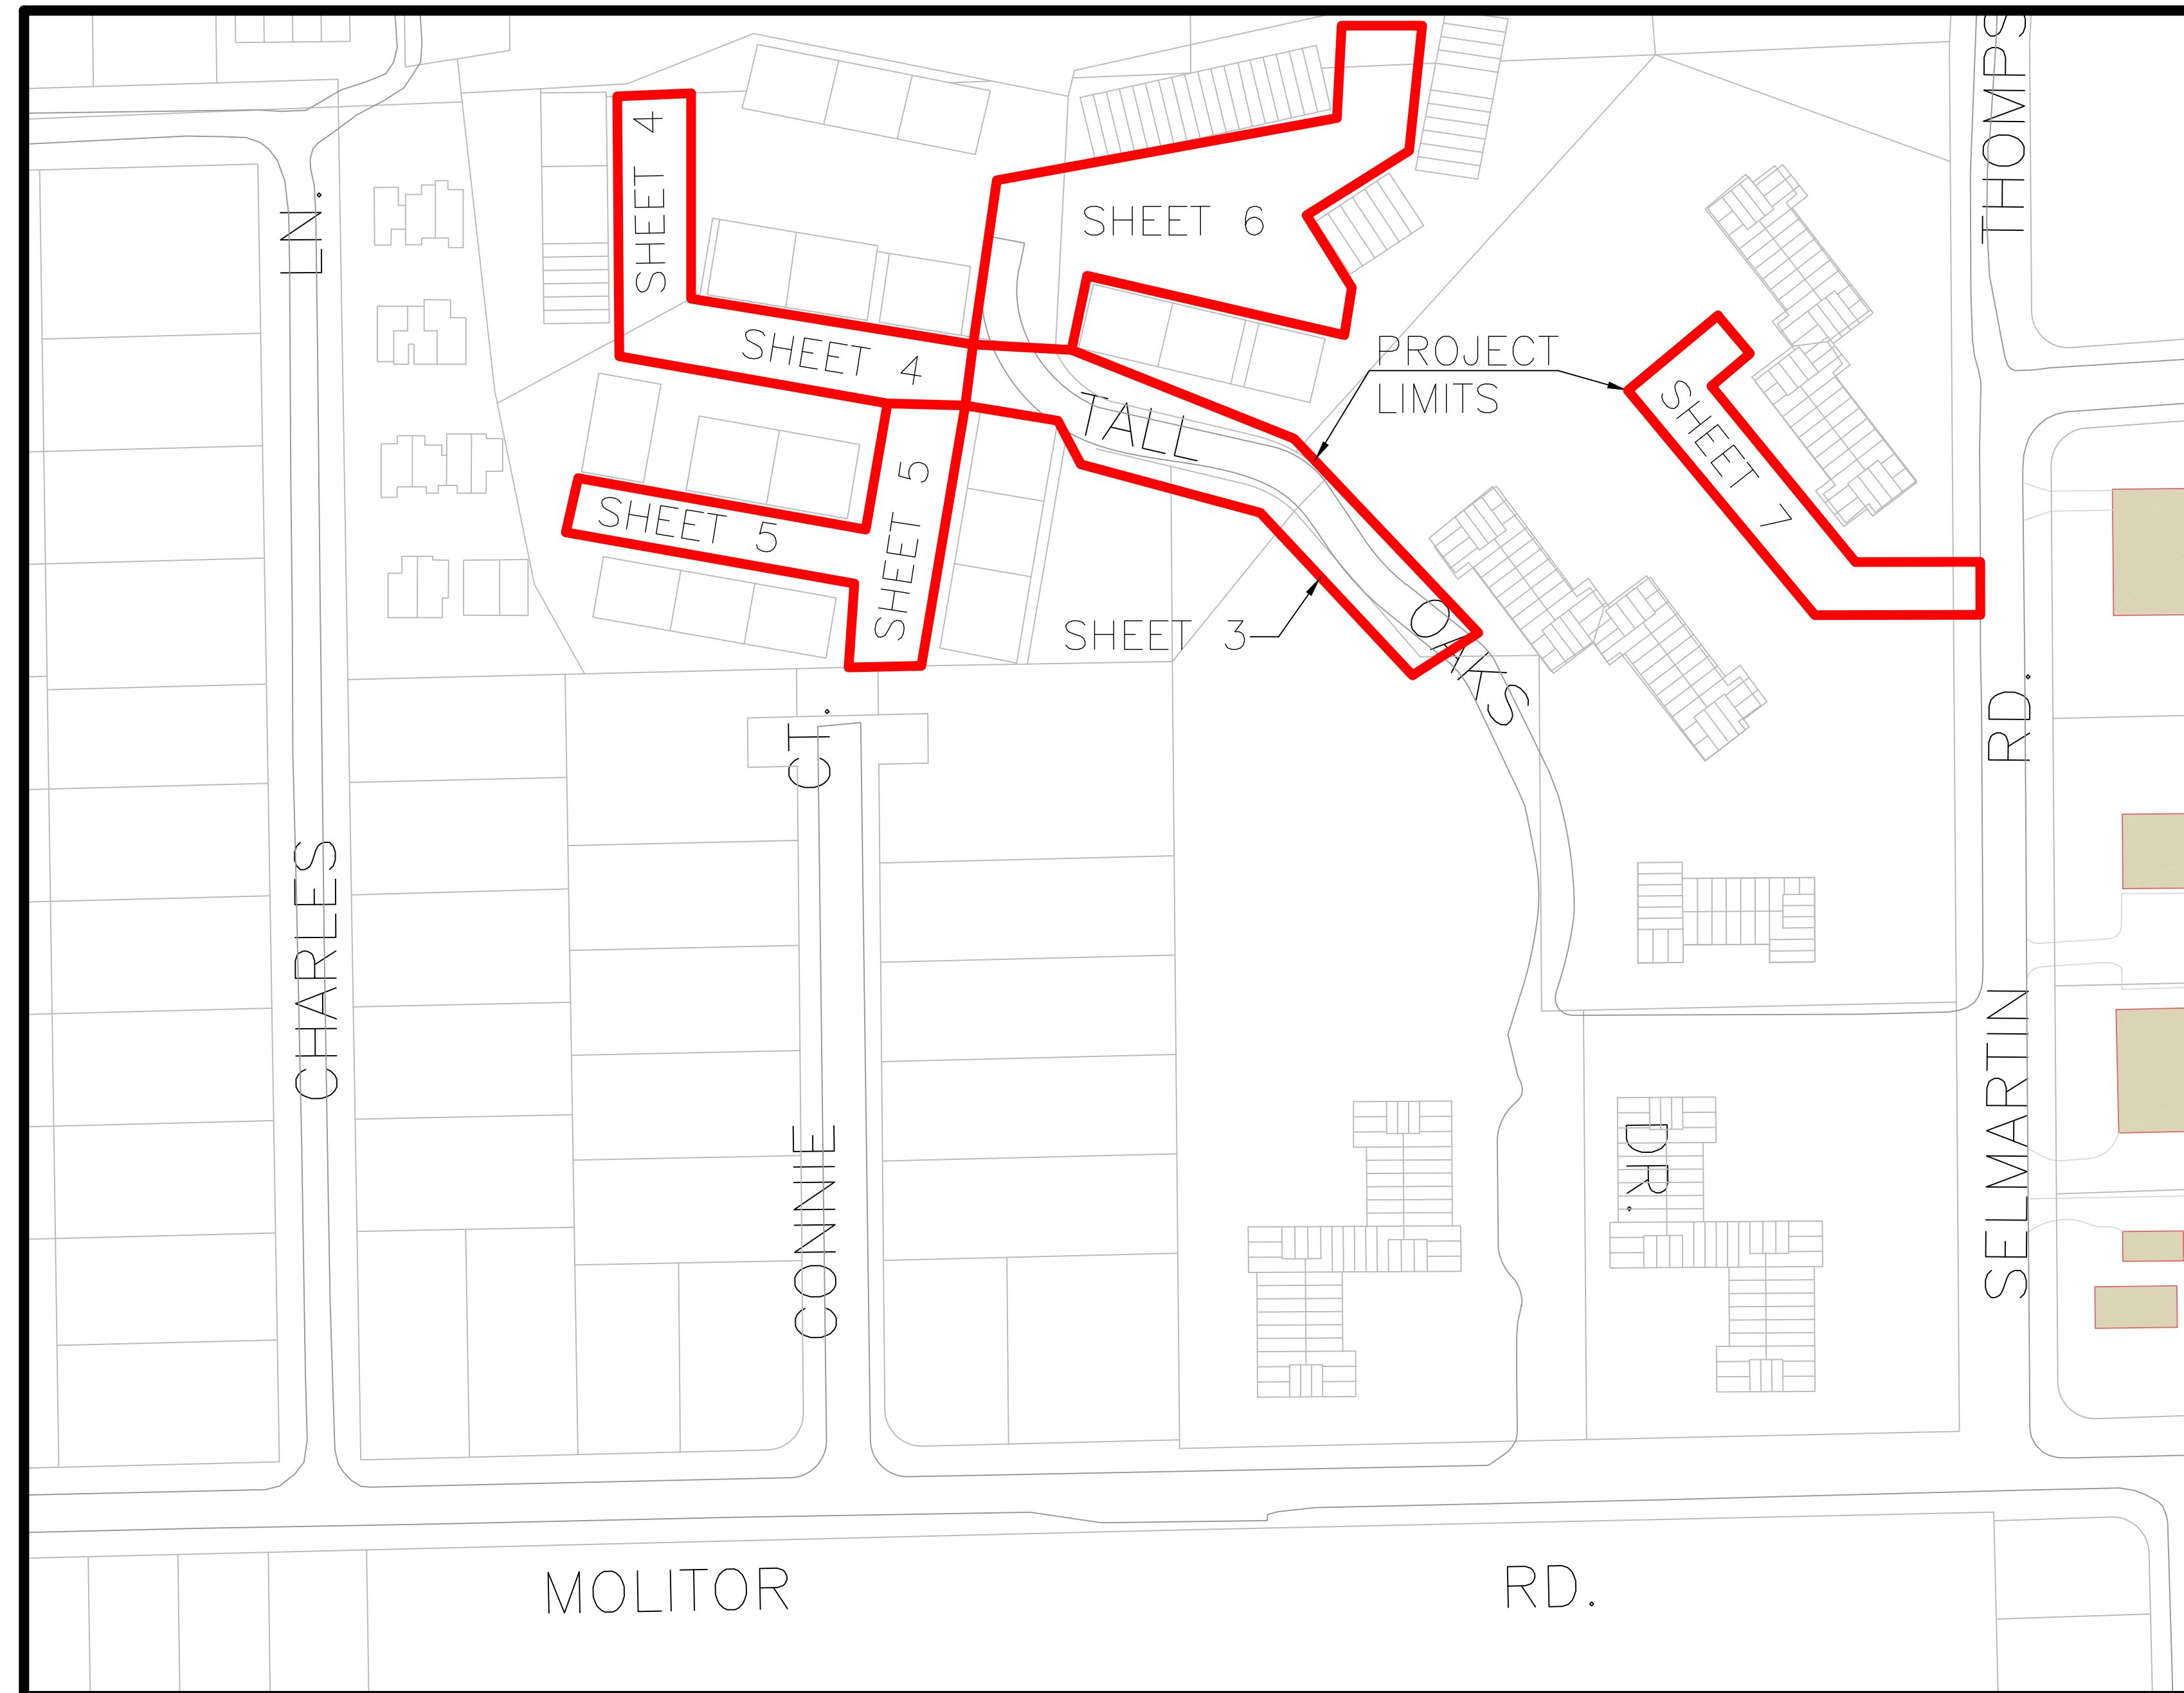

INDEX OF SHEETS

- 1 COVER SHEET
- 2 OVERALL SITE PLAN
- 3-7 PLAN AND PROFILE
- 8-11 STANDARD DETAIL SHEETS

PLANS PREPARED BY:
CITY OF AURORA
DEPARTMENT OF PUBLIC WORKS, DIVISION OF ENGINEERING
44 E. DOWNER PLACE - AURORA, IL
PHONE: 630-256-3200 FAX: 630-256-3229

REVISIONS:

DESIGNED BY: KTM	DRAWN BY: KTM	CHECKED BY: JMB	APPROVED BY: JMB	HORIZ. SCALE: N/A	VERT. SCALE: N/A	DATE: JAN 2018
------------------	---------------	-----------------	------------------	-------------------	------------------	----------------

STAMP
ILLINOIS REGISTERED PROFESSIONAL
ENGINEER No. 062-59993
LICENSE EXPIRES NOVEMBER 30, 2019