
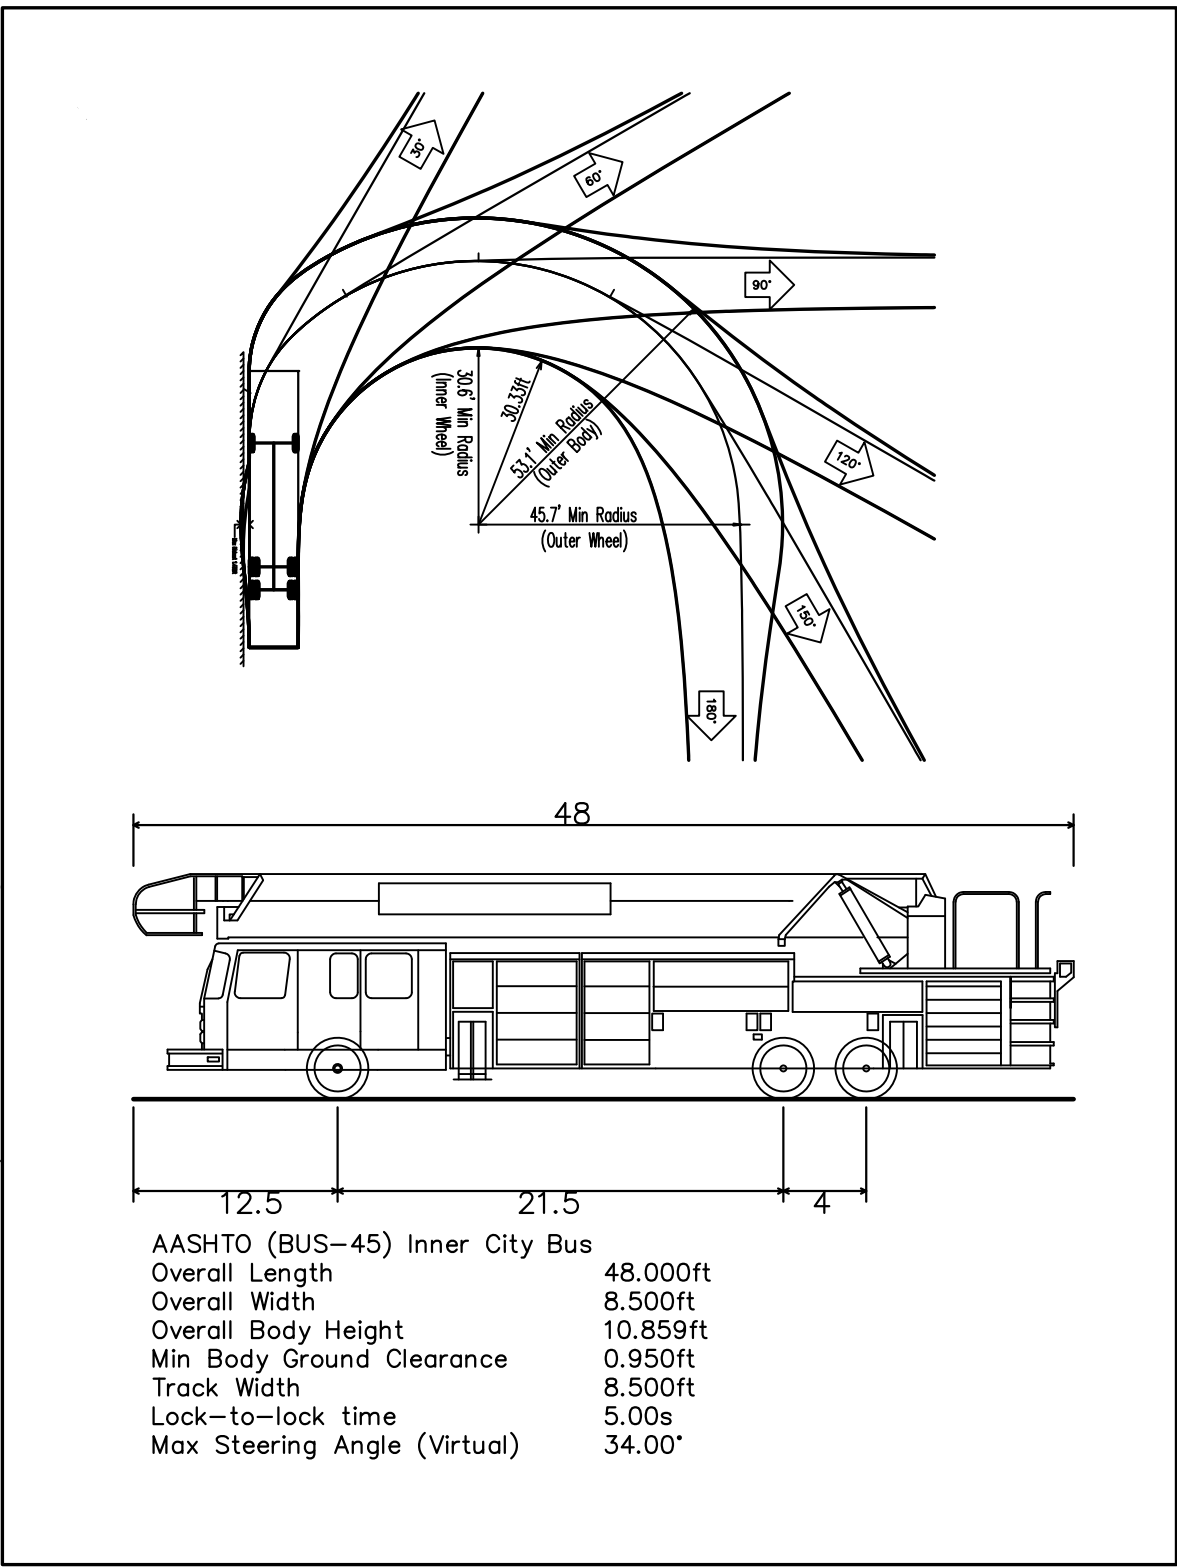


FIRE ACCESS PLAN
for
EASD - ADVENTURES PROGRAM
1480 Reckinger Road
Aurora, Illinois

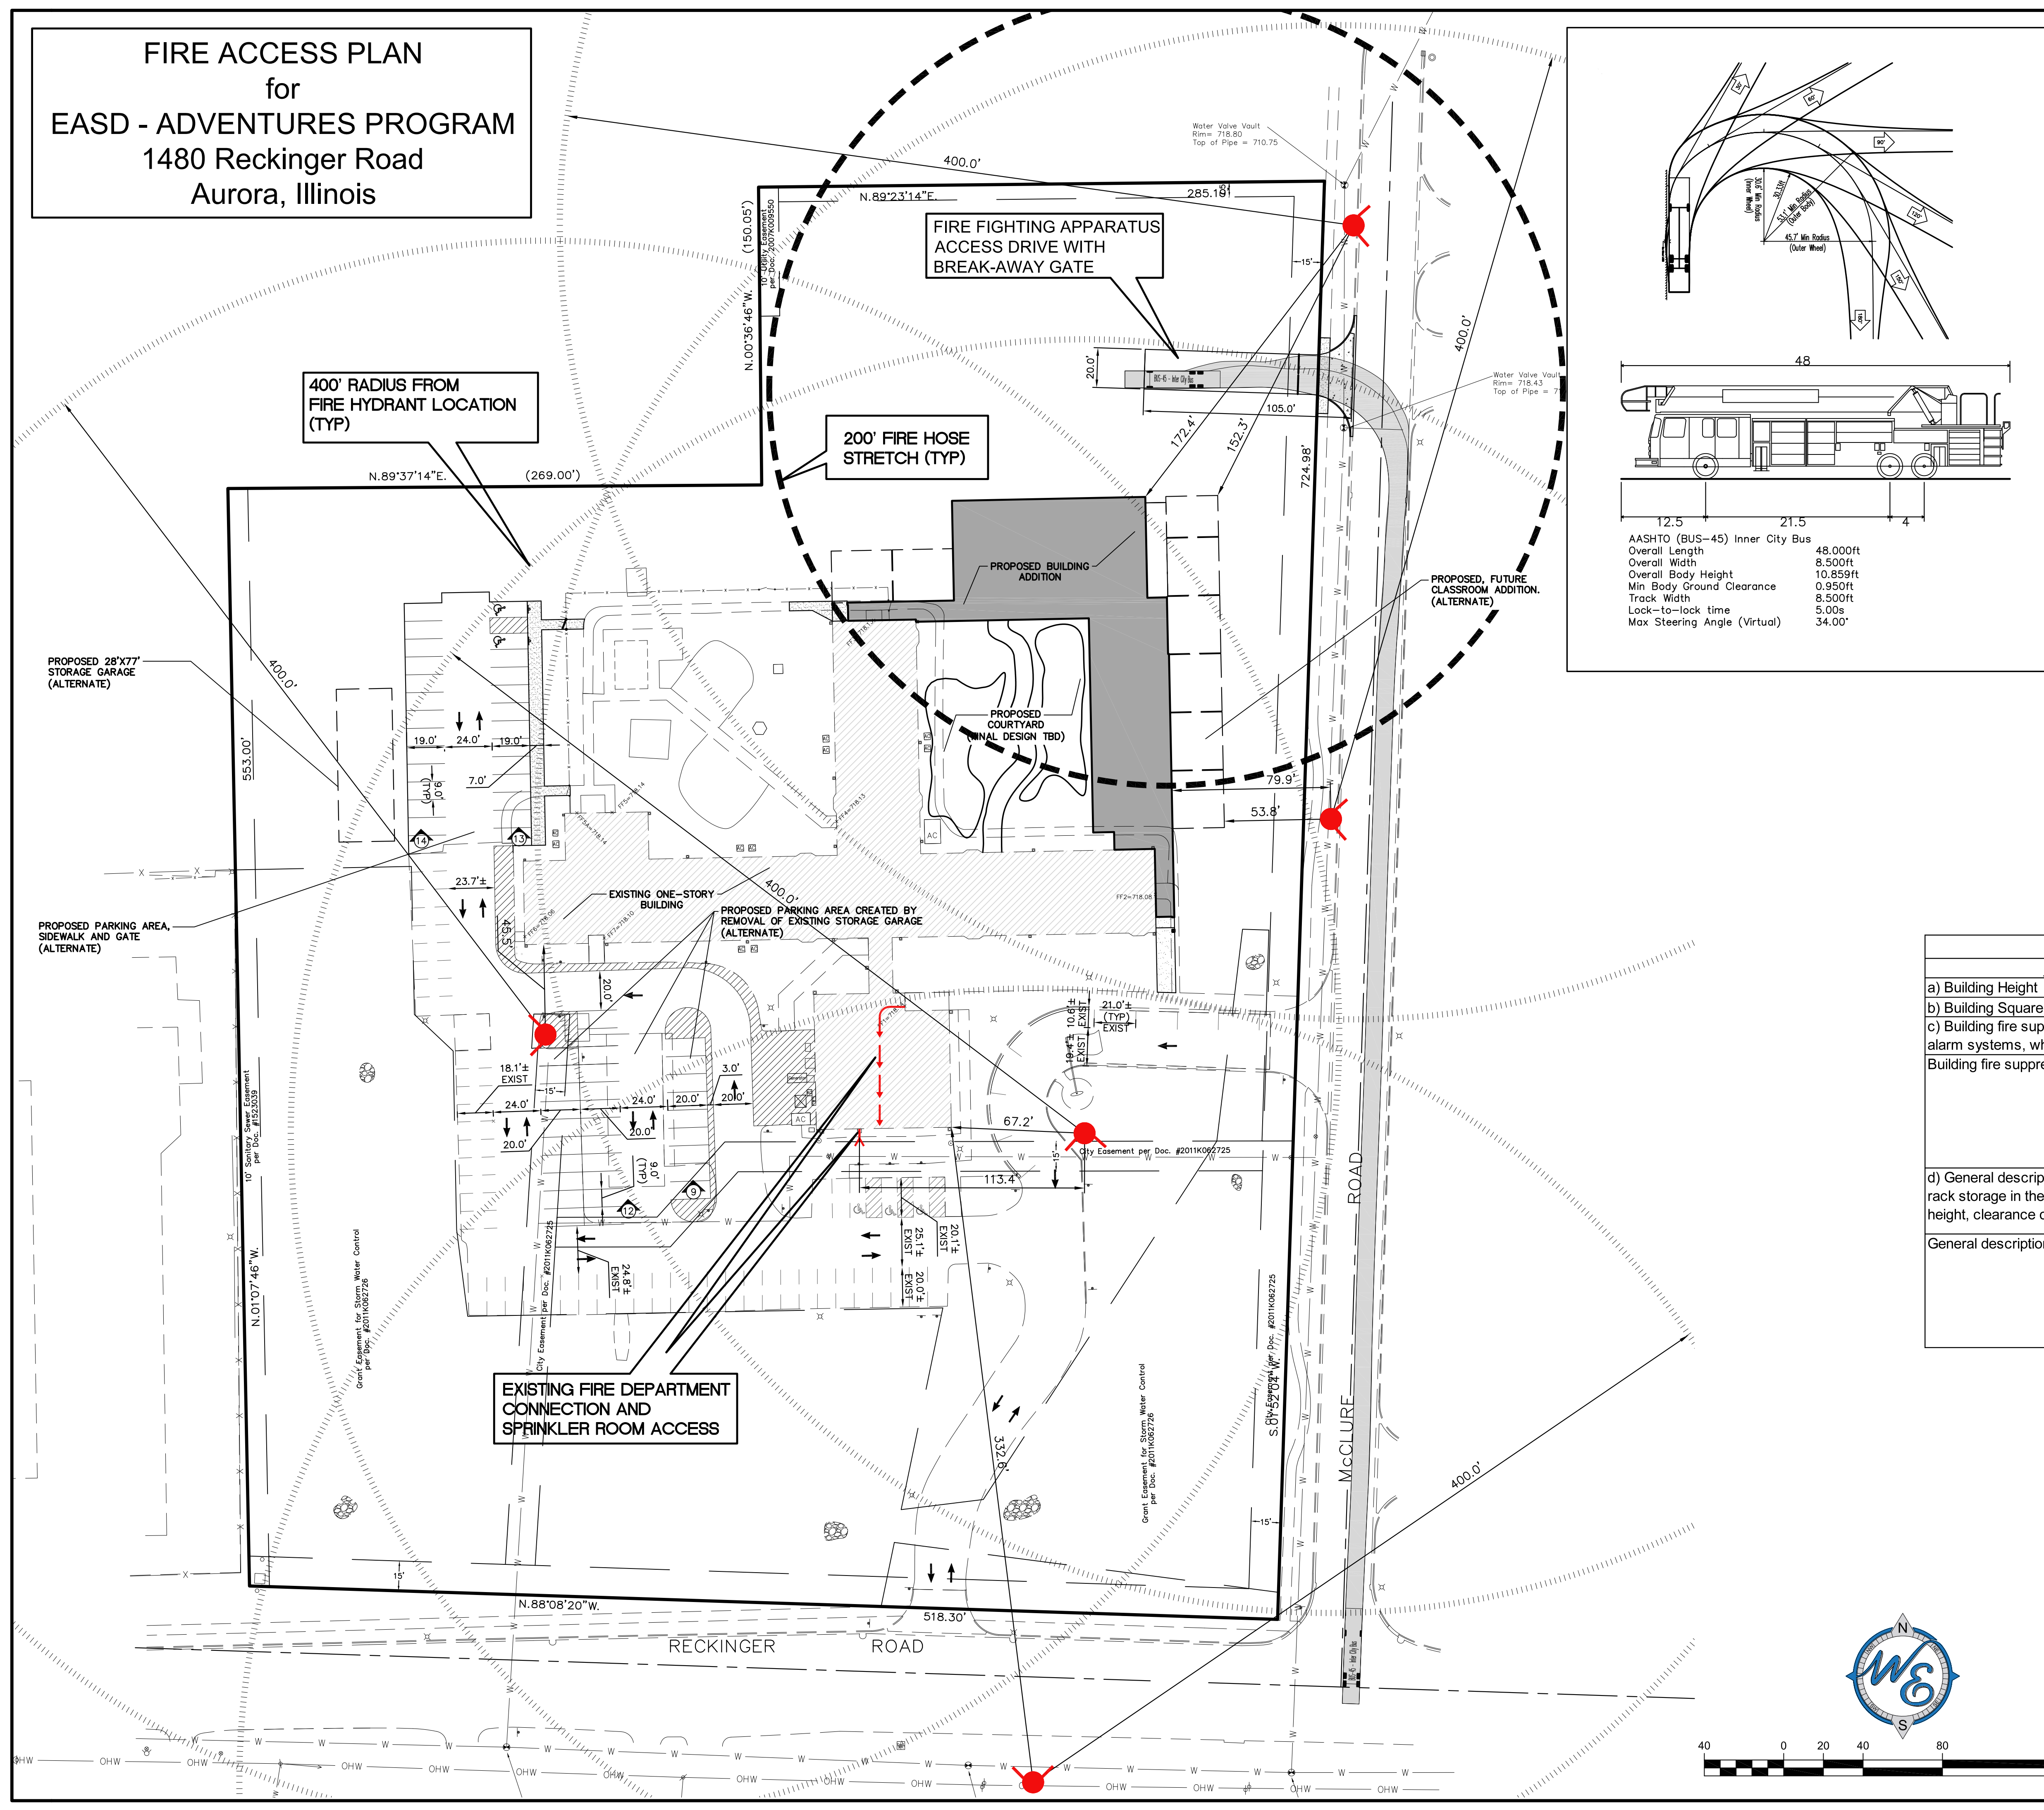

GENERAL NOTES:
1. THESE PLANS ARE BASED ON THE TOPOGRAPHIC SURVEY (SURVEY PROJECT #677071 DATED 07/14/20)
PREPARED BY: ASM CONSULTANTS, INC
16 E WILSON STREET, BATAVIA, IL 60510
(630) 879-0200
2. PRIOR TO CONSTRUCTION, CONTRACTOR TO CONTACT THE DESIGN ENGINEER AND ARCHITECT TO VERIFY THAT THEY ARE WORKING FROM THE MOST CURRENT SET OF PLANS AND SPECIFICATIONS.

LEGEND			
DESCRIPTION	EXISTING	DESCRIPTION	PROPOSED
Light Post	X	CATCH BASIN	INLET
Yard Light	*	STORM MANHOLE	
Utility Pole	+	SANITARY MANHOLE	
Pole Anchor	-	VALVE VAULT	
Telephone Pedestal	o	FIRE HYDRANT	
Manhole	o	FLARED END SECTION	
Catch Basin	o	ELECTRICAL POWER POLE	
Curb Inlet	o	OVERHEAD TRAFFIC SIGNAL	
Water Valve Vault	o	TRAFFIC SIGNAL MANHOLE	
Sanitary Cleanout	o	OVERHEAD ELECTRIC WIRES	
Fire Hydrant	o	TRANSFORMER PAD	
Electrical Meter	o	TELEPHONE PEDestal	
Gas Meter	o	TELEPHONE MANHOLE	
Water Meter	o	CABLE TELEVISION PEDestal	
Downspout	o	COMMONWEALTH EDISON MANHOLE	
Miscellaneous Traffic Sign	o	B/BOX	
Electrical Outlet	o	LIGHT POLE	
Chain Link Fence	X	BOLLARD POLE	
Wood Fence	X	GAS MARKER	
Overhead Wire(s)	X	ELECTRIC MARKER	
Underground Sanitary Line	X	TELEPHONE MARKER	
Underground Comm. Line	X	WATER MAIN	
Underground Gas Line	X	GAS MAIN	
Underground Storm Line	X	ELECTRIC LINE	
Underground Water Line	X	TELEPHONE LINE	
Underground Electric Line	X	CABLE TV LINE	
Top of Foundation	TF	SANITARY SEWER	
Finished Floor	FF	STORM SEWER	
Invert	Inv.	GUY POLE	
Top of Pipe	T/P	CONFIDENTIAL TREE W/DIAMETER	
Deciduous Tree and size in inches	25'	WOOD FENCE	
Non Deciduous Tree and size in inches	25'	CHAIN LINK FENCE	
Bush	25'	METAL GUARDRAIL	
Handicap Parking Space	25'	CONCRETE SURFACE	
Manhole Info. Label	25'	CONTOUR LINE	
		FINISHED FLOOR ELEVATION	
		PAVEMENT ELEVATION	
		MATCH EXISTING ELEVATION	
		GROUND ELEVATION	
		TOP OF WALK ELEVATION	
		TOP OF CURB ELEVATION	
		TOP OF RETAINING WALL ELEVATION	
		FLOW LINE ELEVATION	
		RIM ELEVATION	
		DOWNSPOUT LOCATION	
		PERVIOUS AREA SLOPE DIRECTION	
		PAVEMENT SLOPE DIRECTION	
		OVERLAND OVERFLOW DIRECTION	
		INLET PROTECTION	
		INLET BASKET FILTER	

Fire Access Plan Data Table			
Description	Value	Unit	
a) Building Height	20'-0" (max)	feet	
b) Building Square Footage (typical)	Total 44,098	square feet	
c) Building fire suppression information including any proposed use of sprinkler systems, fire alarm systems, whether fire extinguishers are needed: Building fire suppression information including any proposed use of sprinkler systems, fire alarm systems			
d) General description of business to be conducted within each building including: will there be rack storage in the building, will there be storage of combustible materials over twelve feet in height, clearance of sprinkler heads and stored materials (18 inch minimum): General description of business to be conducted within each building including: will there be rack storage			



FIRE ACCESS PLAN

CHECKED BY: J.MILLER
DESIGN BY: H.WITTENKELLER
DRAWN BY: H.WITTENKELLER
DATE: SEPTEMBER 30, 2020
SCALE: 1" = 40'
PROJECT NO.: 20-065

1 of 1

CORDOGAN, CLARK & ASSOCIATES
960 Ridgeway Ave
Aurora, IL 60506
E.A.S.D. - ADVENTURES PROGRAM
1480 Reckinger Road
Aurora, Illinois

Prepared For:

Prepared By:

watermark-engineering.com | 2631 Ginger Woods Pkwy | Aurora, IL 60502 | (630) 375-1900