


HINMAN AVE AND 2ND AVE SEWER SEPARATION & WATER MAIN REPLACEMENT

JANUARY, 2023

GENERALLY LOCATED: SECTION 27, T38N, R8E

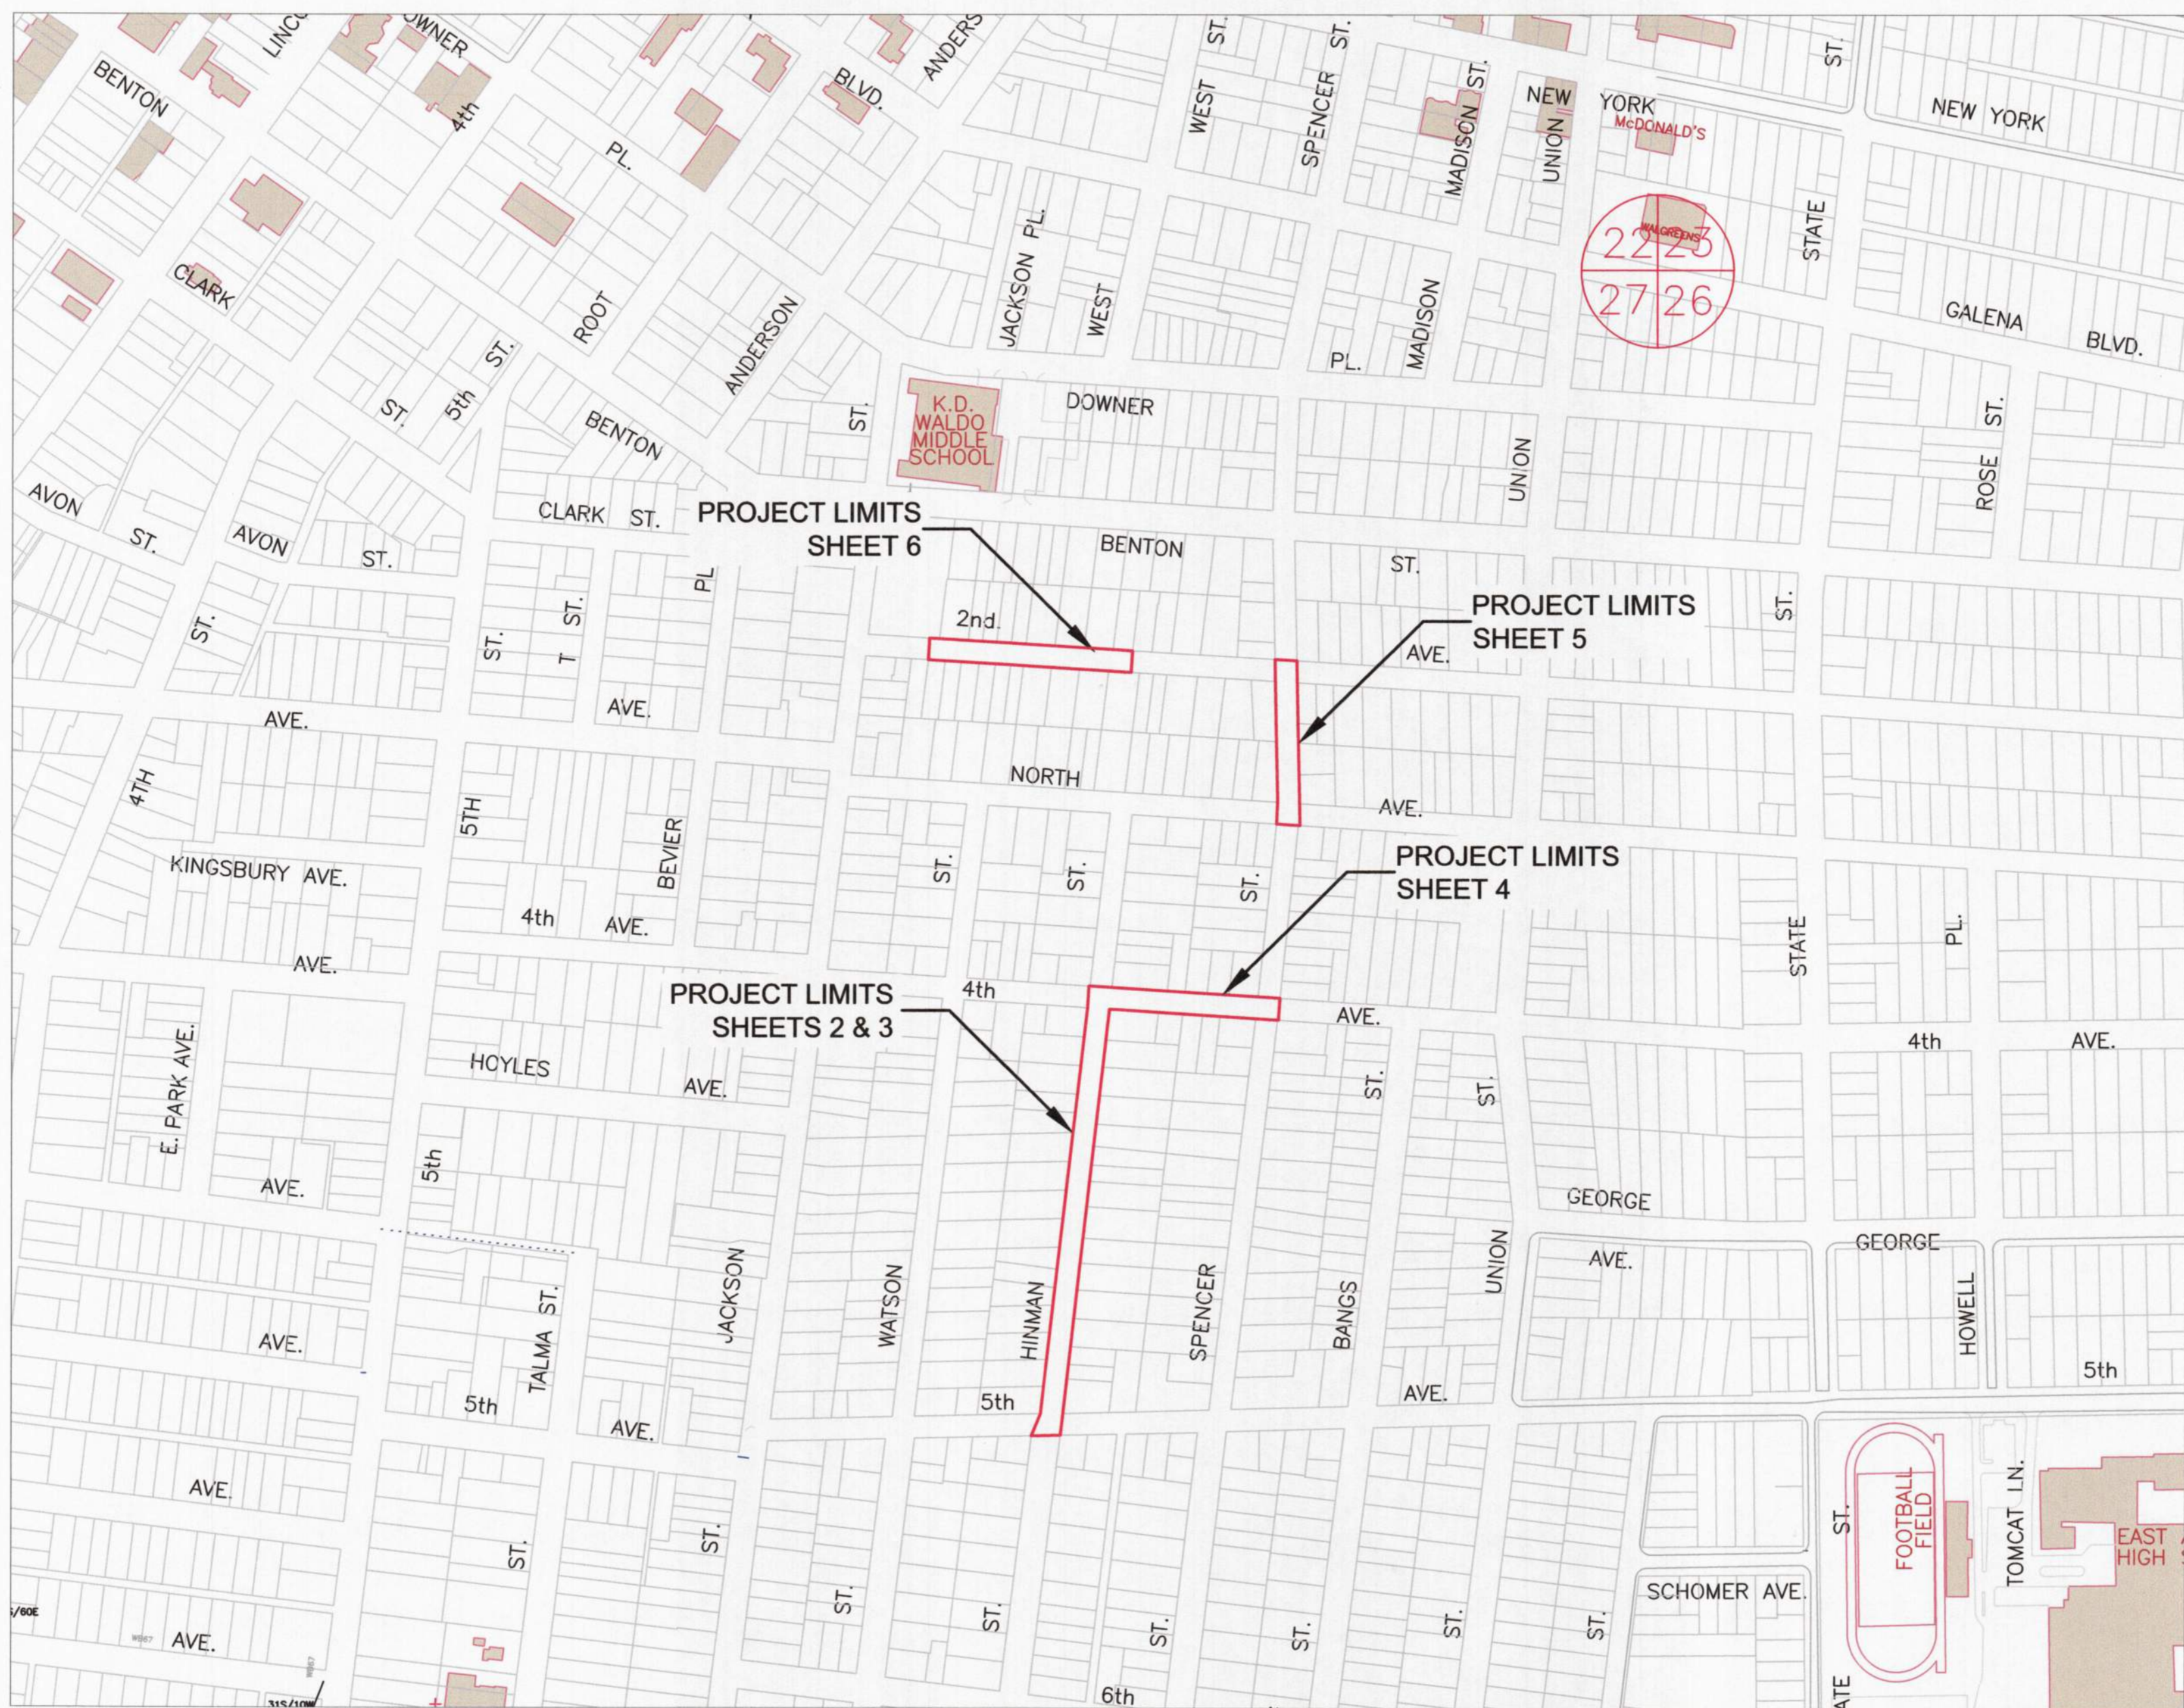

INDEX OF SHEETS

- 1 COVER SHEET
- 2-6 PLAN AND PROFILE SHEETS
- 7-12 STANDARD DETAIL SHEETS

PLANS PREPARED BY:

CITY OF AURORA

DEPARTMENT OF PUBLIC WORKS, DIVISION OF ENGINEERING
77 S. BROADWAY AVE. - AURORA, IL

PHONE: 630-256-3200 FAX: 630-256-3229

REVISIONS:

DESIGNED BY: KTM	DRAWN BY: MH	CHECKED BY: KTM	APPROVED BY: KTM	HORIZ. SCALE: N/A	VERT. SCALE: N/A	DATE: JAN 2023
------------------	--------------	-----------------	------------------	-------------------	------------------	----------------

STAMP
ILLINOIS REGISTERED PROFESSIONAL
ENGINEER No.
LICENSE EXPIRES



2/14/23
DATE

062-59993
NOVEMBER 30, 2023