 
 


INDEX OF SHEETS	
SHEET NUMBER	SHEET TITLE
1	COVER
2	LEGEND
3	GENERAL NOTES
4	PLAN AND PROFILE
5	PLAN AND PROFILE
6	PLAN AND PROFILE
7	EROSION CONTROL DETAILS
8	FORCEMAIN DETAILS
9	TRAFFIC CONTROL DETAILS


WHITE EAGLE
FORCEMAIN
FOR
CITY OF AURORA
AURORA, ILLINOIS



PLAN & PROFILE

UTILITIES	
UTILITY TYPE	COMMON NAME
WATER & SEWER	CITY OF AURORA
ELECTRIC	COMED
TELEPHONE	AT&T
GAS	NICOR
CABLE	COMCAST

(CONTRACTOR TO BE RESPONSIBLE FOR ANY ADJUSTMENTS TO BE MADE.)

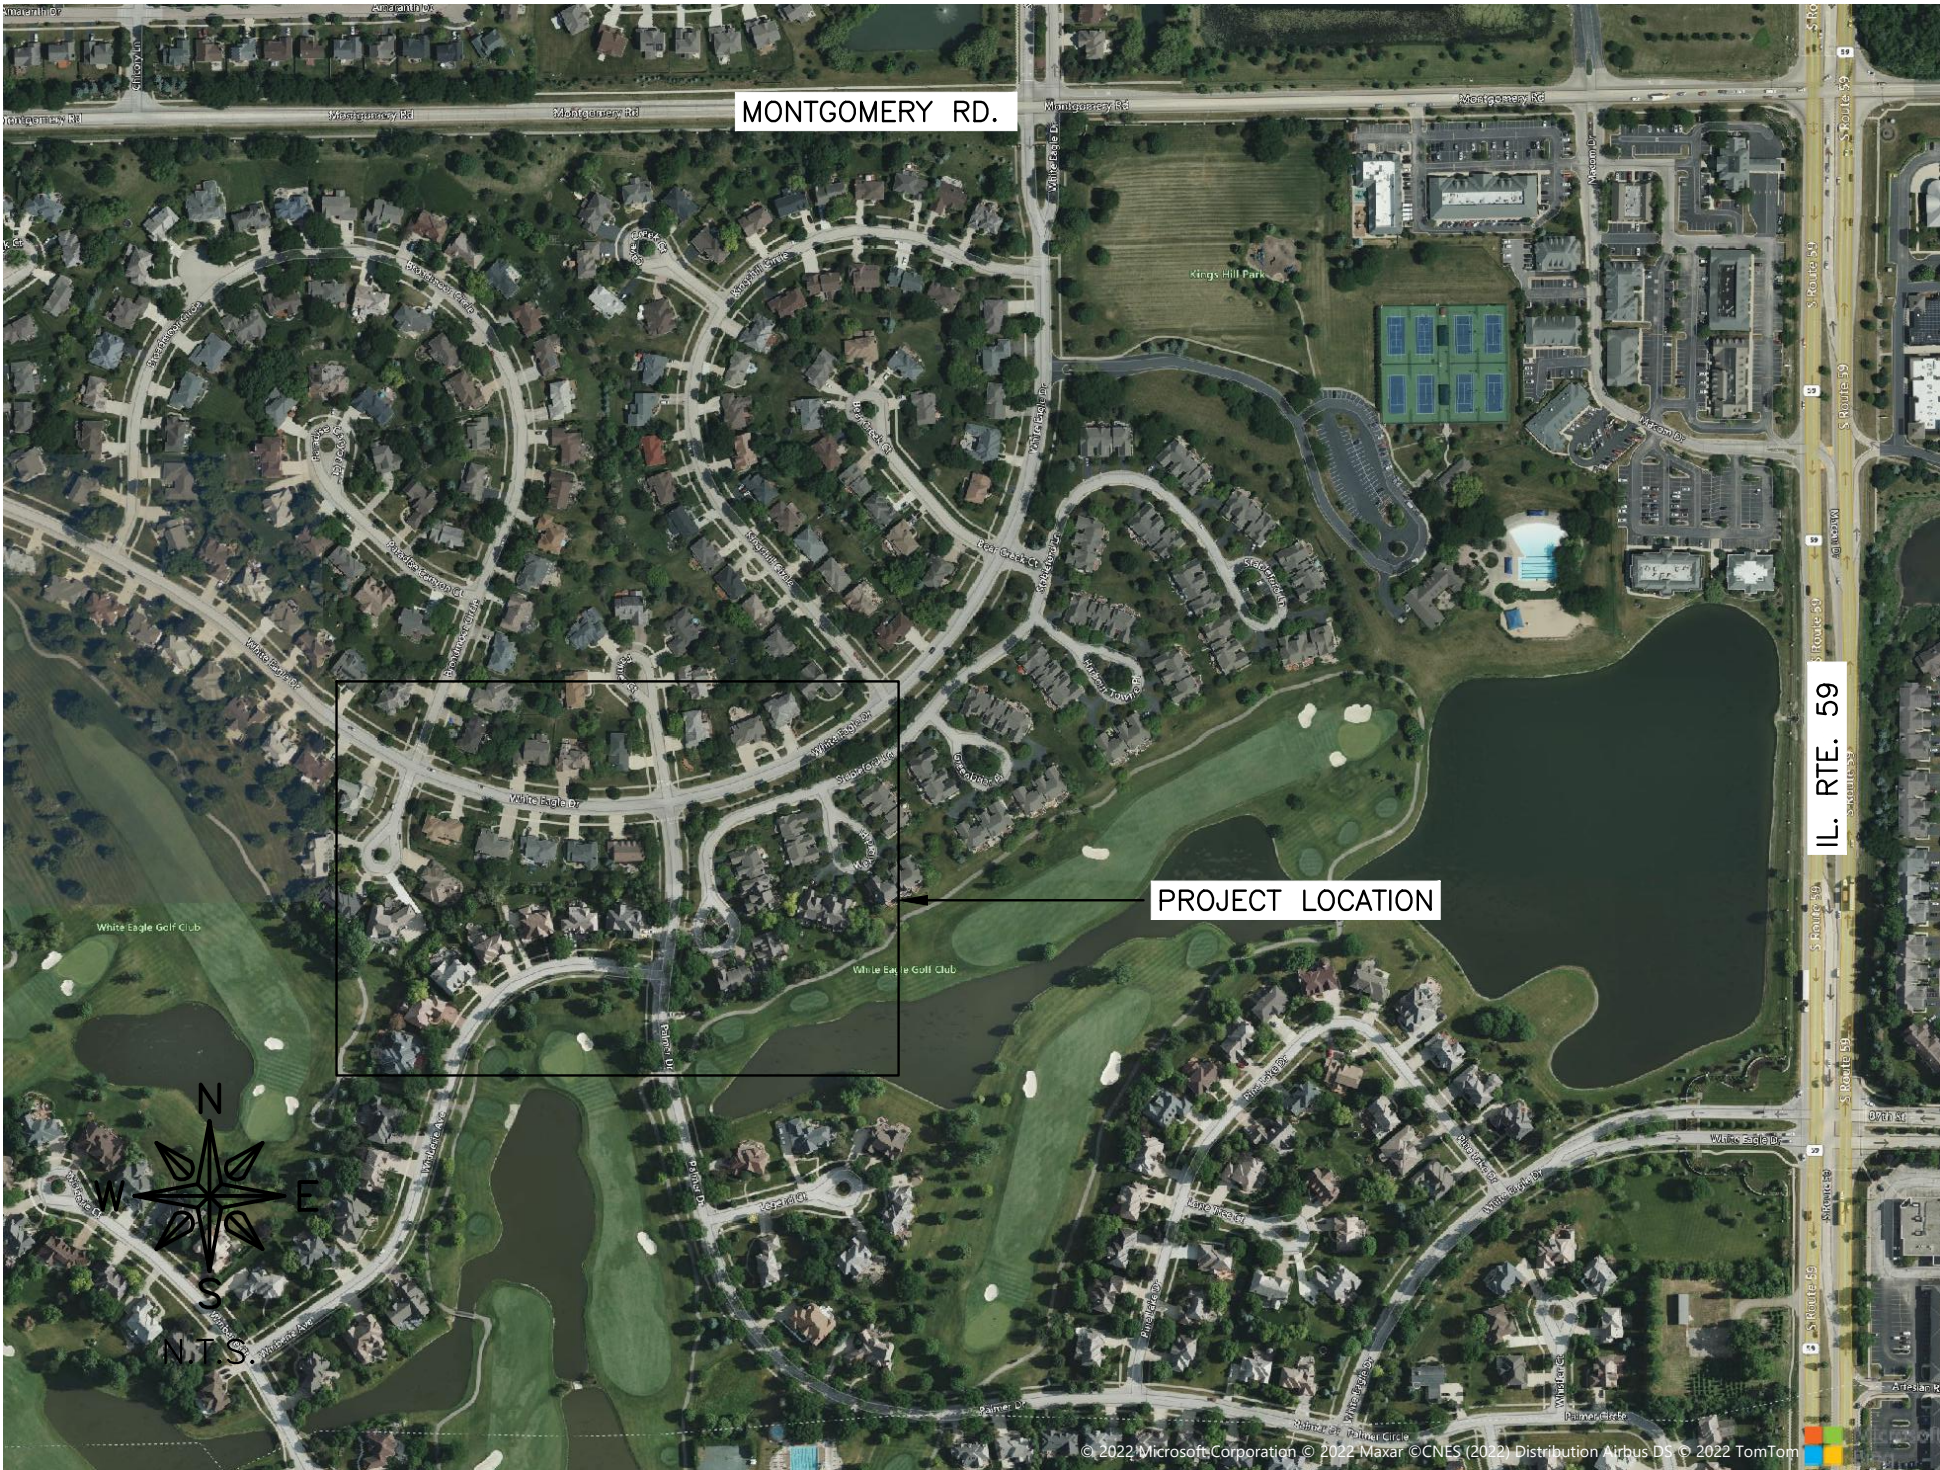

LOCATION MAP

FEHR GRAHAM
ENGINEERING & ENVIRONMENTAL

ILLINOIS

IOWA

WISCONSIN

ILLINOIS PROFESSIONAL DESIGN FIRM NUMBER: 184003525



BID SET

ORIGINAL SET FOR PROJECT: 22-694		DATE CREATED: 3-10-2023
REVISIONS		
REV. NO.	DESCRIPTION	DATE