



PLANS FOR THE PROPOSED
JACKSON ST & SIMMS ST SEWER SEPARATION AND
5TH AVE WATER MAIN REPLACEMENT
JACKSON ST. FROM 5TH AVE. TO SIMMS ST.


MARCH 2025

GENERALLY LOCATED IN THE N. 1/2 OF SEC 27 T38N, R8E

INDEX OF SHEETS

- 1 COVER SHEET
2-4 PLAN AND PROFILE
5-10 STANDARD DETAILS

LEGEND		
	EXISTING	PROPOSED
SANITARY SEWER	—) —	—) —
STORM SEWER	— > —	— > —
WATER MAIN	— W —	— W —
FORCE MAIN	— FM —	— FM —
UNDERDRAIN	— UD —	— UD —
OVERHEAD LINE	— OH —	— OH —
CABLE TV LINE	— CATV —	— CATV —
GAS LINE	— GAS —	— GAS —
TELEPHONE LINE	— T —	— T —
ELECTRIC LINE	— E —	— E —
FENCE	— X —	— X —
MAJOR CONTOUR	— — —	— — —
MINOR CONTOUR	— — —	— — —
HIGH WATER LEVEL	— HWL —	— HWL —
NORMAL WATER LEVEL	— NWL —	— NWL —
PAYMENT FLOW DIRECTION	— — —	— — —
SPOT ELEVATION	X 882.6 TC	X 882.6 TC
TOP OF CURB ELEVATION	X 882.6 T/F	X 882.6 T/F
TOP OF FOUNDATION ELEVATION	X 882.6 FL	X 882.6 FL
GUTTER ELEVATION	X 882.6 P	X 882.6 P
PAVEMENT ELEVATION	X 882.6 P	X 882.6 P
EDGE OF PAVEMENT	— — —	— — —
CURB AND GUTTER	— — —	— — —
RIGHT-OF-WAY	— — —	— — —
SANITARY MANHOLE	— — —	— — —
SANITARY CLEANOUT	— — —	— — —
STORM MANHOLE	— — —	— — —
CATCH BASIN	— — —	— — —
INLET	— — —	— — —
FLARED END SECTION	— — —	— — —
FIRE HYDRANT	— — —	— — —
VALVE VAULT	— — —	— — —
VALVE BOX	— — —	— — —
STREET LIGHT	— — —	— — —
POWER POLE	— — —	— — —
STREET SIGN	— — —	— — —
ELECTRIC BOX	— — —	— — —
TELEPHONE BOX	— — —	— — —
TELEPHONE MANHOLE	— — —	— — —
B-BOX	— — —	— — —
GAS VALVE	— — —	— — —
TRAFFIC HANDHOLE	— — —	— — —
ELECTRIC HANDHOLE	— — —	— — —
TREE W/ DIAMETER	— — —	— — —
MAILBOX	— — —	— — —
STRUCTURE TO BE REMOVED	— — —	— — —
PLUG EXISTING PIPE	— — —	— — —
UTILITY CROSSING	— — —	— — —
EXPLORATORY EXCAVATION LOCATION	— — —	— — —
SANITARY MANHOLE REHABILITATION NUMBER	— — —	— — —
SOIL BORING LOCATION WITH IDENTIFICATION NUMBER & ELEVATION	— — —	— — —

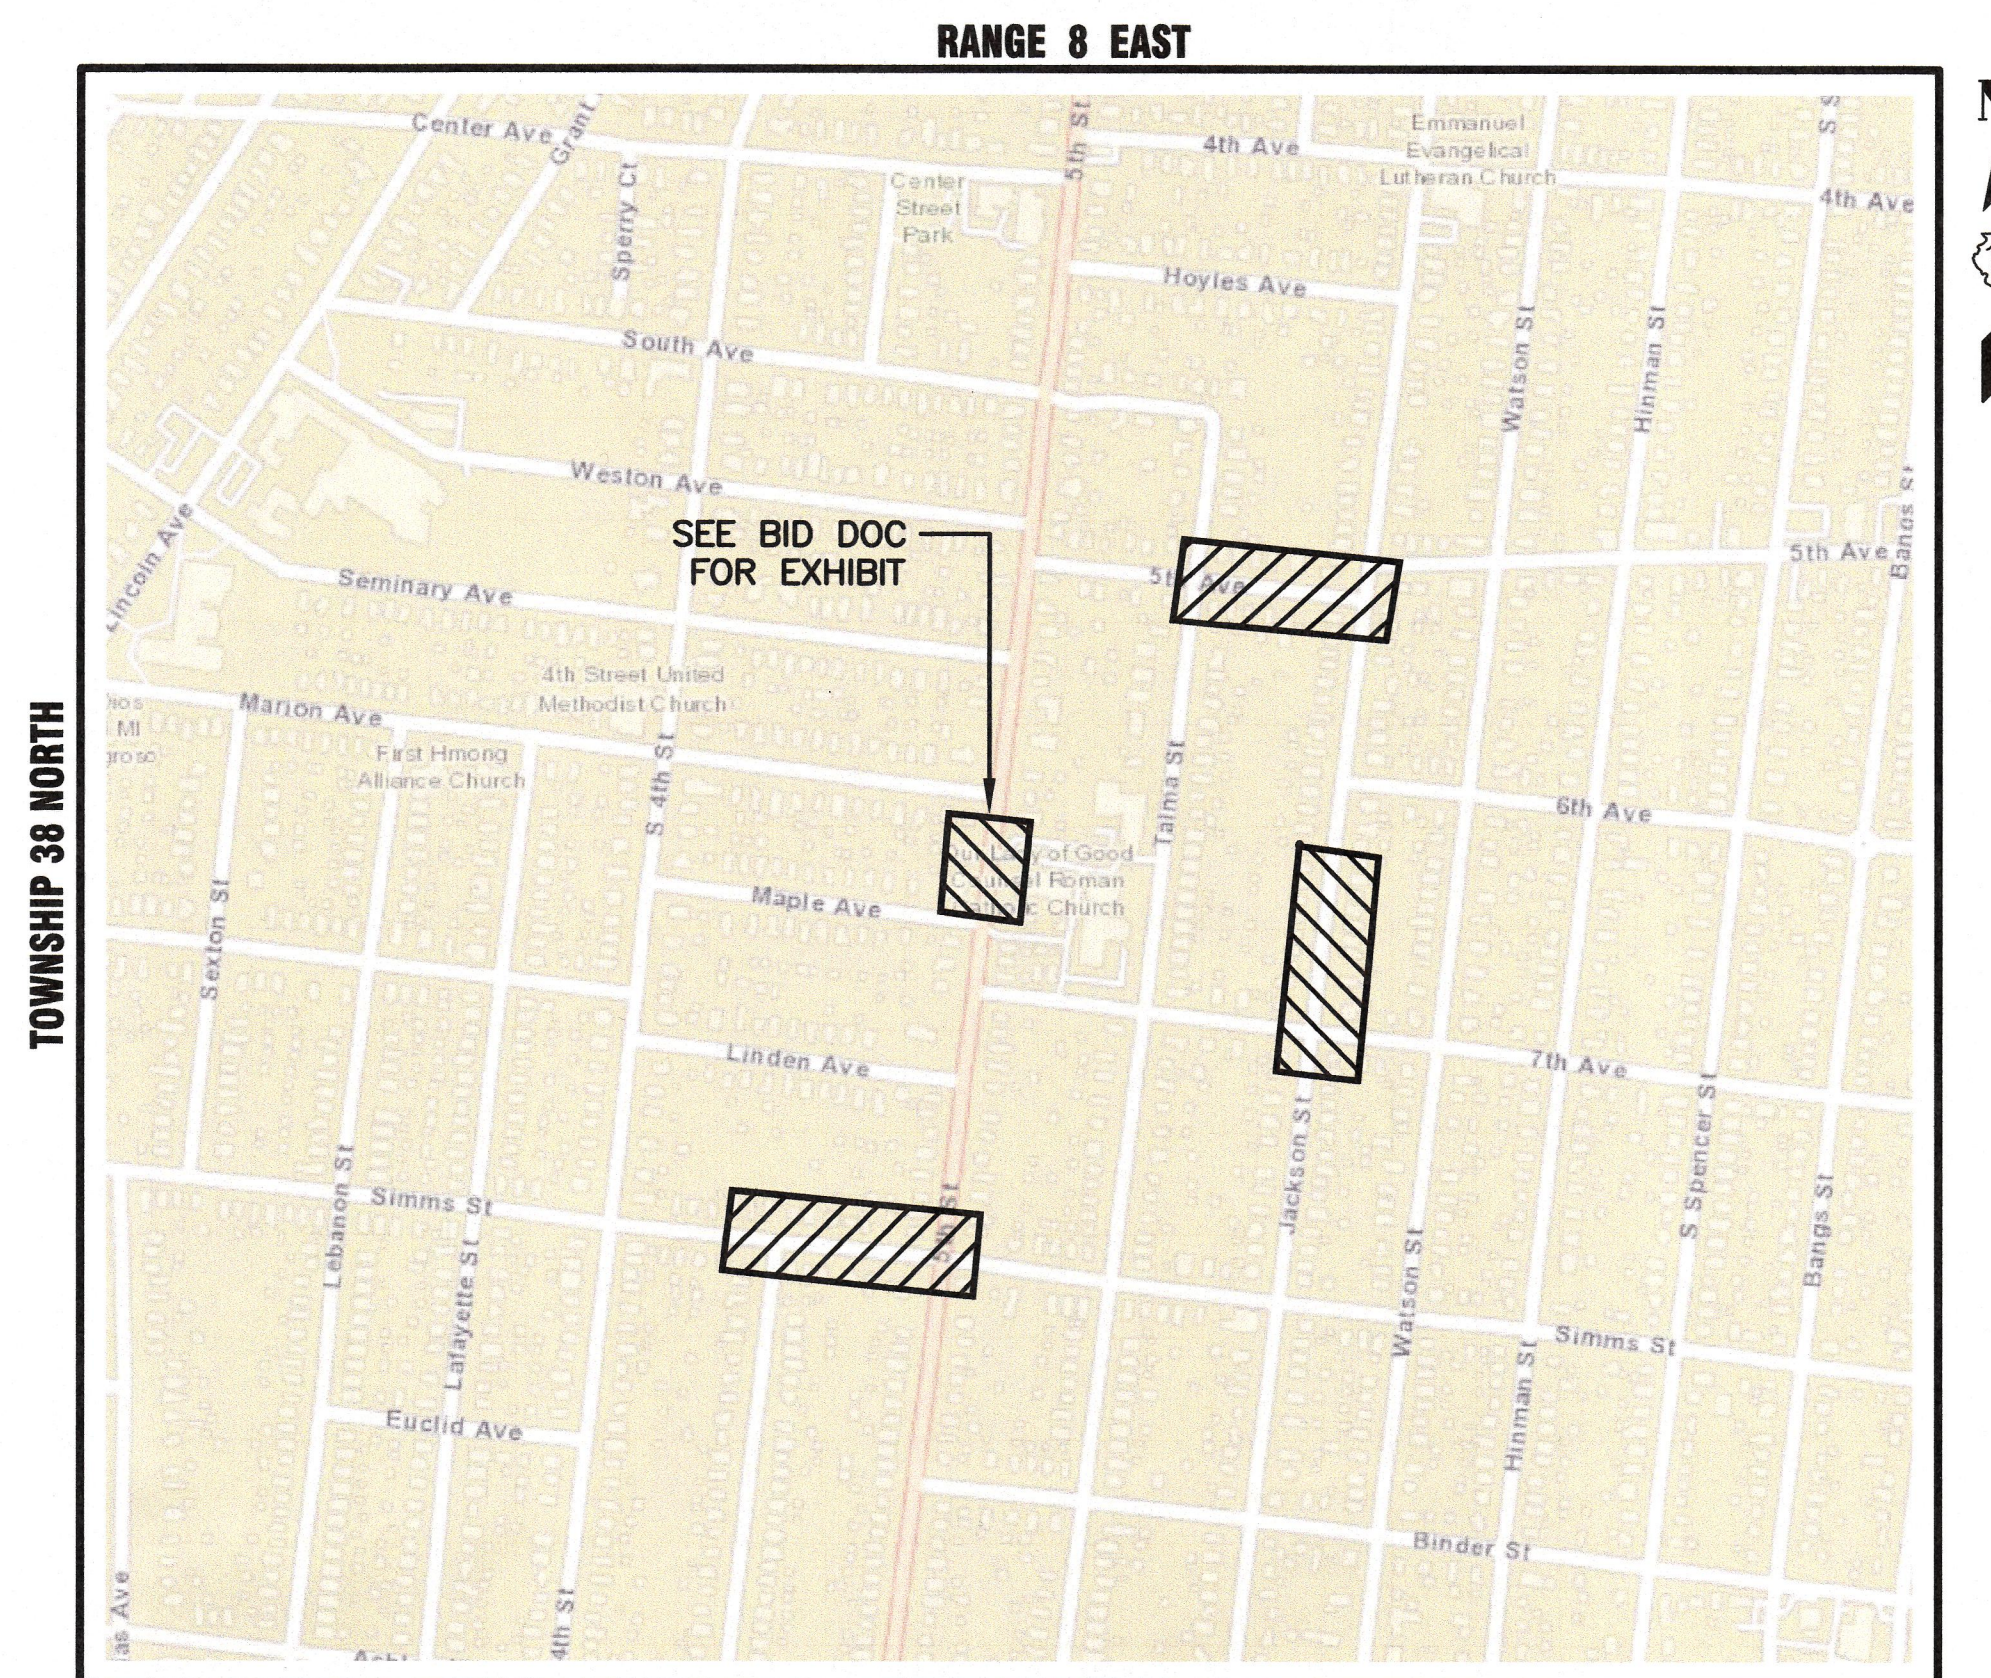

KANE COUNTY - AURORA TOWNSHIP
THIRD PRINCIPAL MERIDIAN

LOCATION MAP
NOT TO SCALE



J.U.L.I.E.
JOINT UTILITY LOCATION INFORMATION FOR EXCAVATION
811 OR 1-800-892-0123

CONSTRUCTION AND MAINTENANCE TO BE IN
ACCORDANCE WITH ALL APPLICABLE REGULATORY
REQUIREMENTS AND STANDARDS

PRINTED BY THE AUTHORITY
OF THE CITY OF AURORA

PLANS PREPARED BY:

CITY OF AURORA

DEPARTMENT OF PUBLIC WORKS - ENGINEERING DIVISION
77 S. BROADWAY AVE, AURORA, IL 60505

PHONE: 630-256-3200 FAX: 630-256-3229

REVISIONS:


DESIGNED BY: OSC	DRAWN BY: AHB	CHECKED BY: KTM	APPROVED BY: KTM	HORIZ. SCALE: N/A	VERT. SCALE: N/A	DATE: MAR 2025
------------------	---------------	-----------------	------------------	-------------------	------------------	----------------

STAMP

ILLINOIS REGISTERED PROFESSIONAL

ENGINEER No.

LICENSE EXPIRES

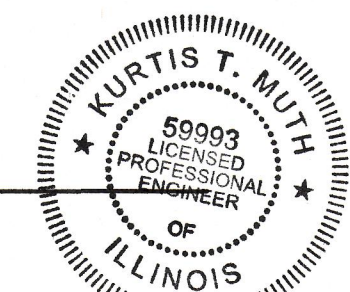

DATE

062.070660

NOVEMBER 30, 2025