


**FIRE ACCESS PLAN FOR
AURORA FIRE STATION #7
824 KENILWORTH PLACE**

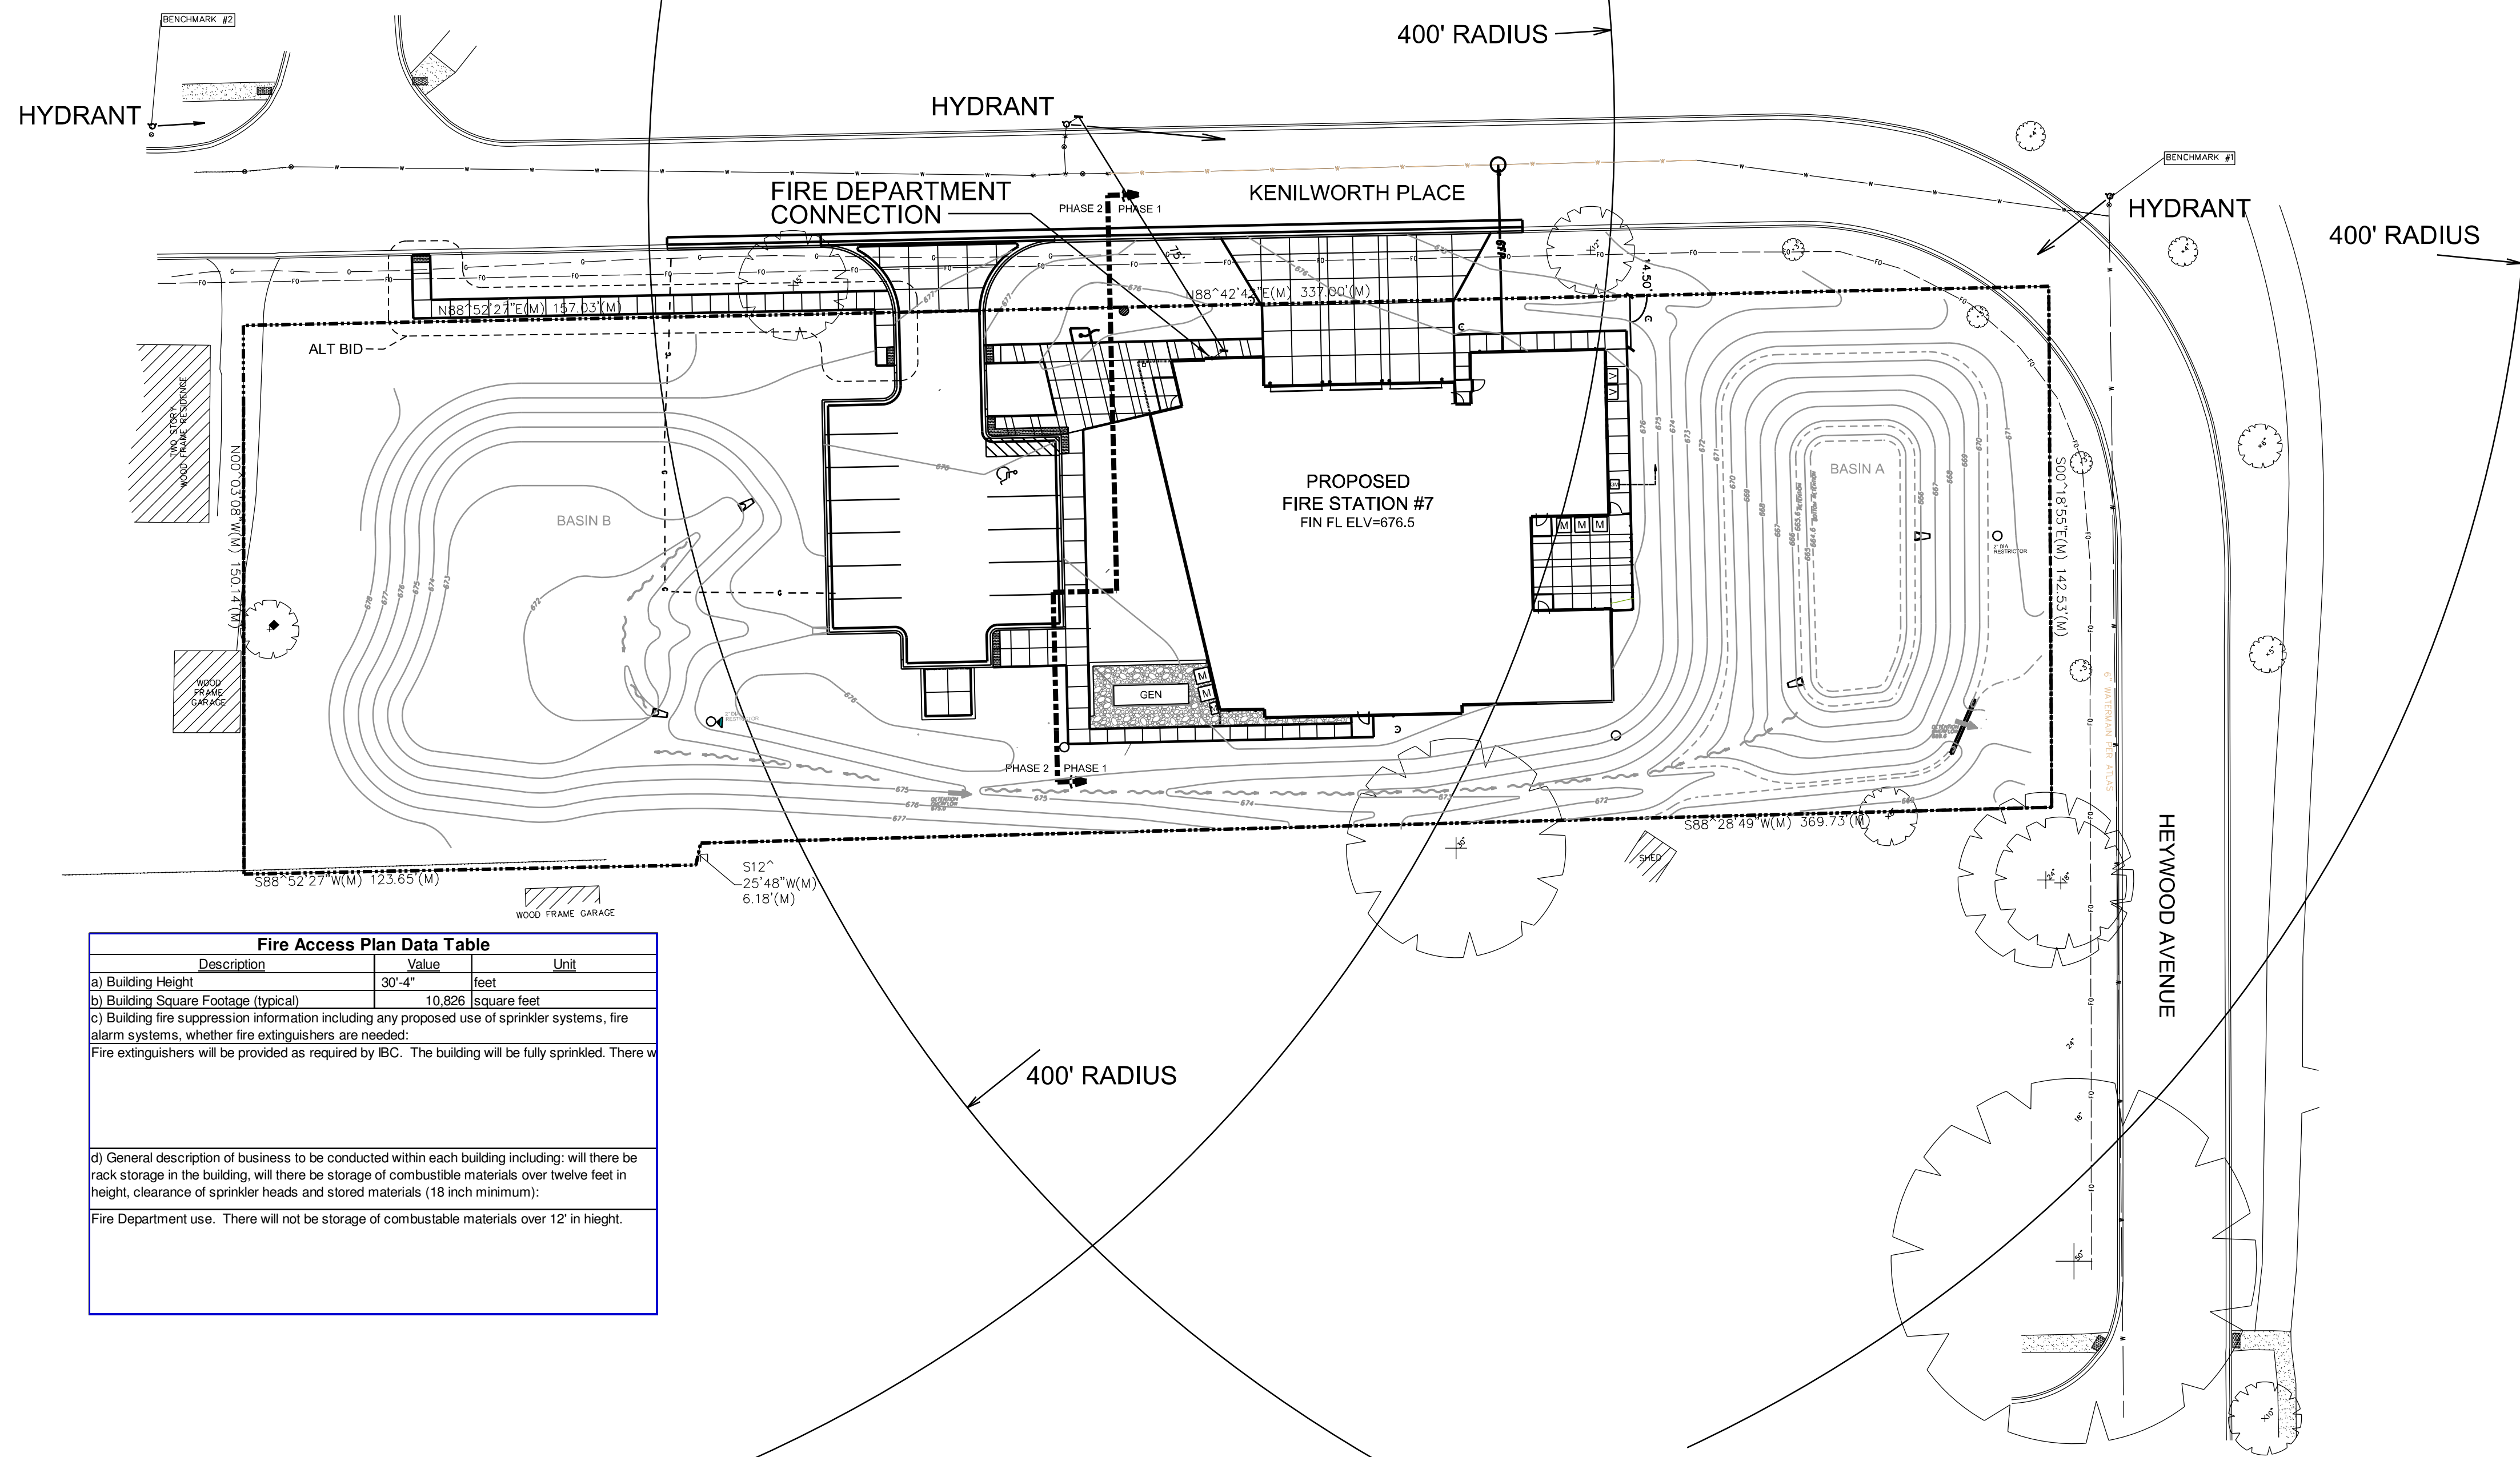

Fire Access Plan Data Table		
Description	Value	Unit
a) Building Height	30'-4"	feet
b) Building Square Footage (typical)	10,826	square feet
c) Building fire suppression information including any proposed use of sprinkler systems, fire alarm systems, whether fire extinguishers are needed: Fire extinguishers will be provided as required by IBC. The building will be fully sprinkled. There w		
d) General description of business to be conducted within each building including: will there be rack storage in the building, will there be storage of combustible materials over twelve feet in height, clearance of sprinkler heads and stored materials (18 inch minimum): Fire Department use. There will not be storage of combustible materials over 12' in height.		

AURORA FIRE DEPARTMENT
AURORA FIRE STATION #7
824 KENILWORTH AVENUE, AURORA, ILLINOIS 60506
ZONING SUBMITTAL

SEAL

SEAL

SCALE

NO. DESCRIPTION DATE

REVISIONS

DRAWN BY: GJR

APPROVED BY: GJR

CHECKED BY: GJR

DATE: 02/07/17

FIRE ACCESS PLAN
SCALE: 1" = 30'

TITLE: **FIRE ACCESS PLAN**

PROJECT NO. 50074101

CF-1

SHEET NO.