

FINAL PLAN

PETITIONER:
PANATTONI DEVELOPMENT COMPANY, INC
6250 NORTH RIVER ROAD
SUITE 4050
ROSEMONT, ILLINOIS, 60018

[illegible][illegible]

FINAL PLAN
SULLIVAN ROAD INDUSTRIAL
 AURORA, ILLINOIS

**CONSULTING ENGINEERS
SITE DEVELOPMENT ENGINEERS
LAND SURVEYORS**

Phone: (847) 938-9999



SPACECO INC.


FILENAME:
10570-FINAL-PLAN


DATE:
08/27/21

JOB NO.
10570

SHEET

FP
1 OF 1

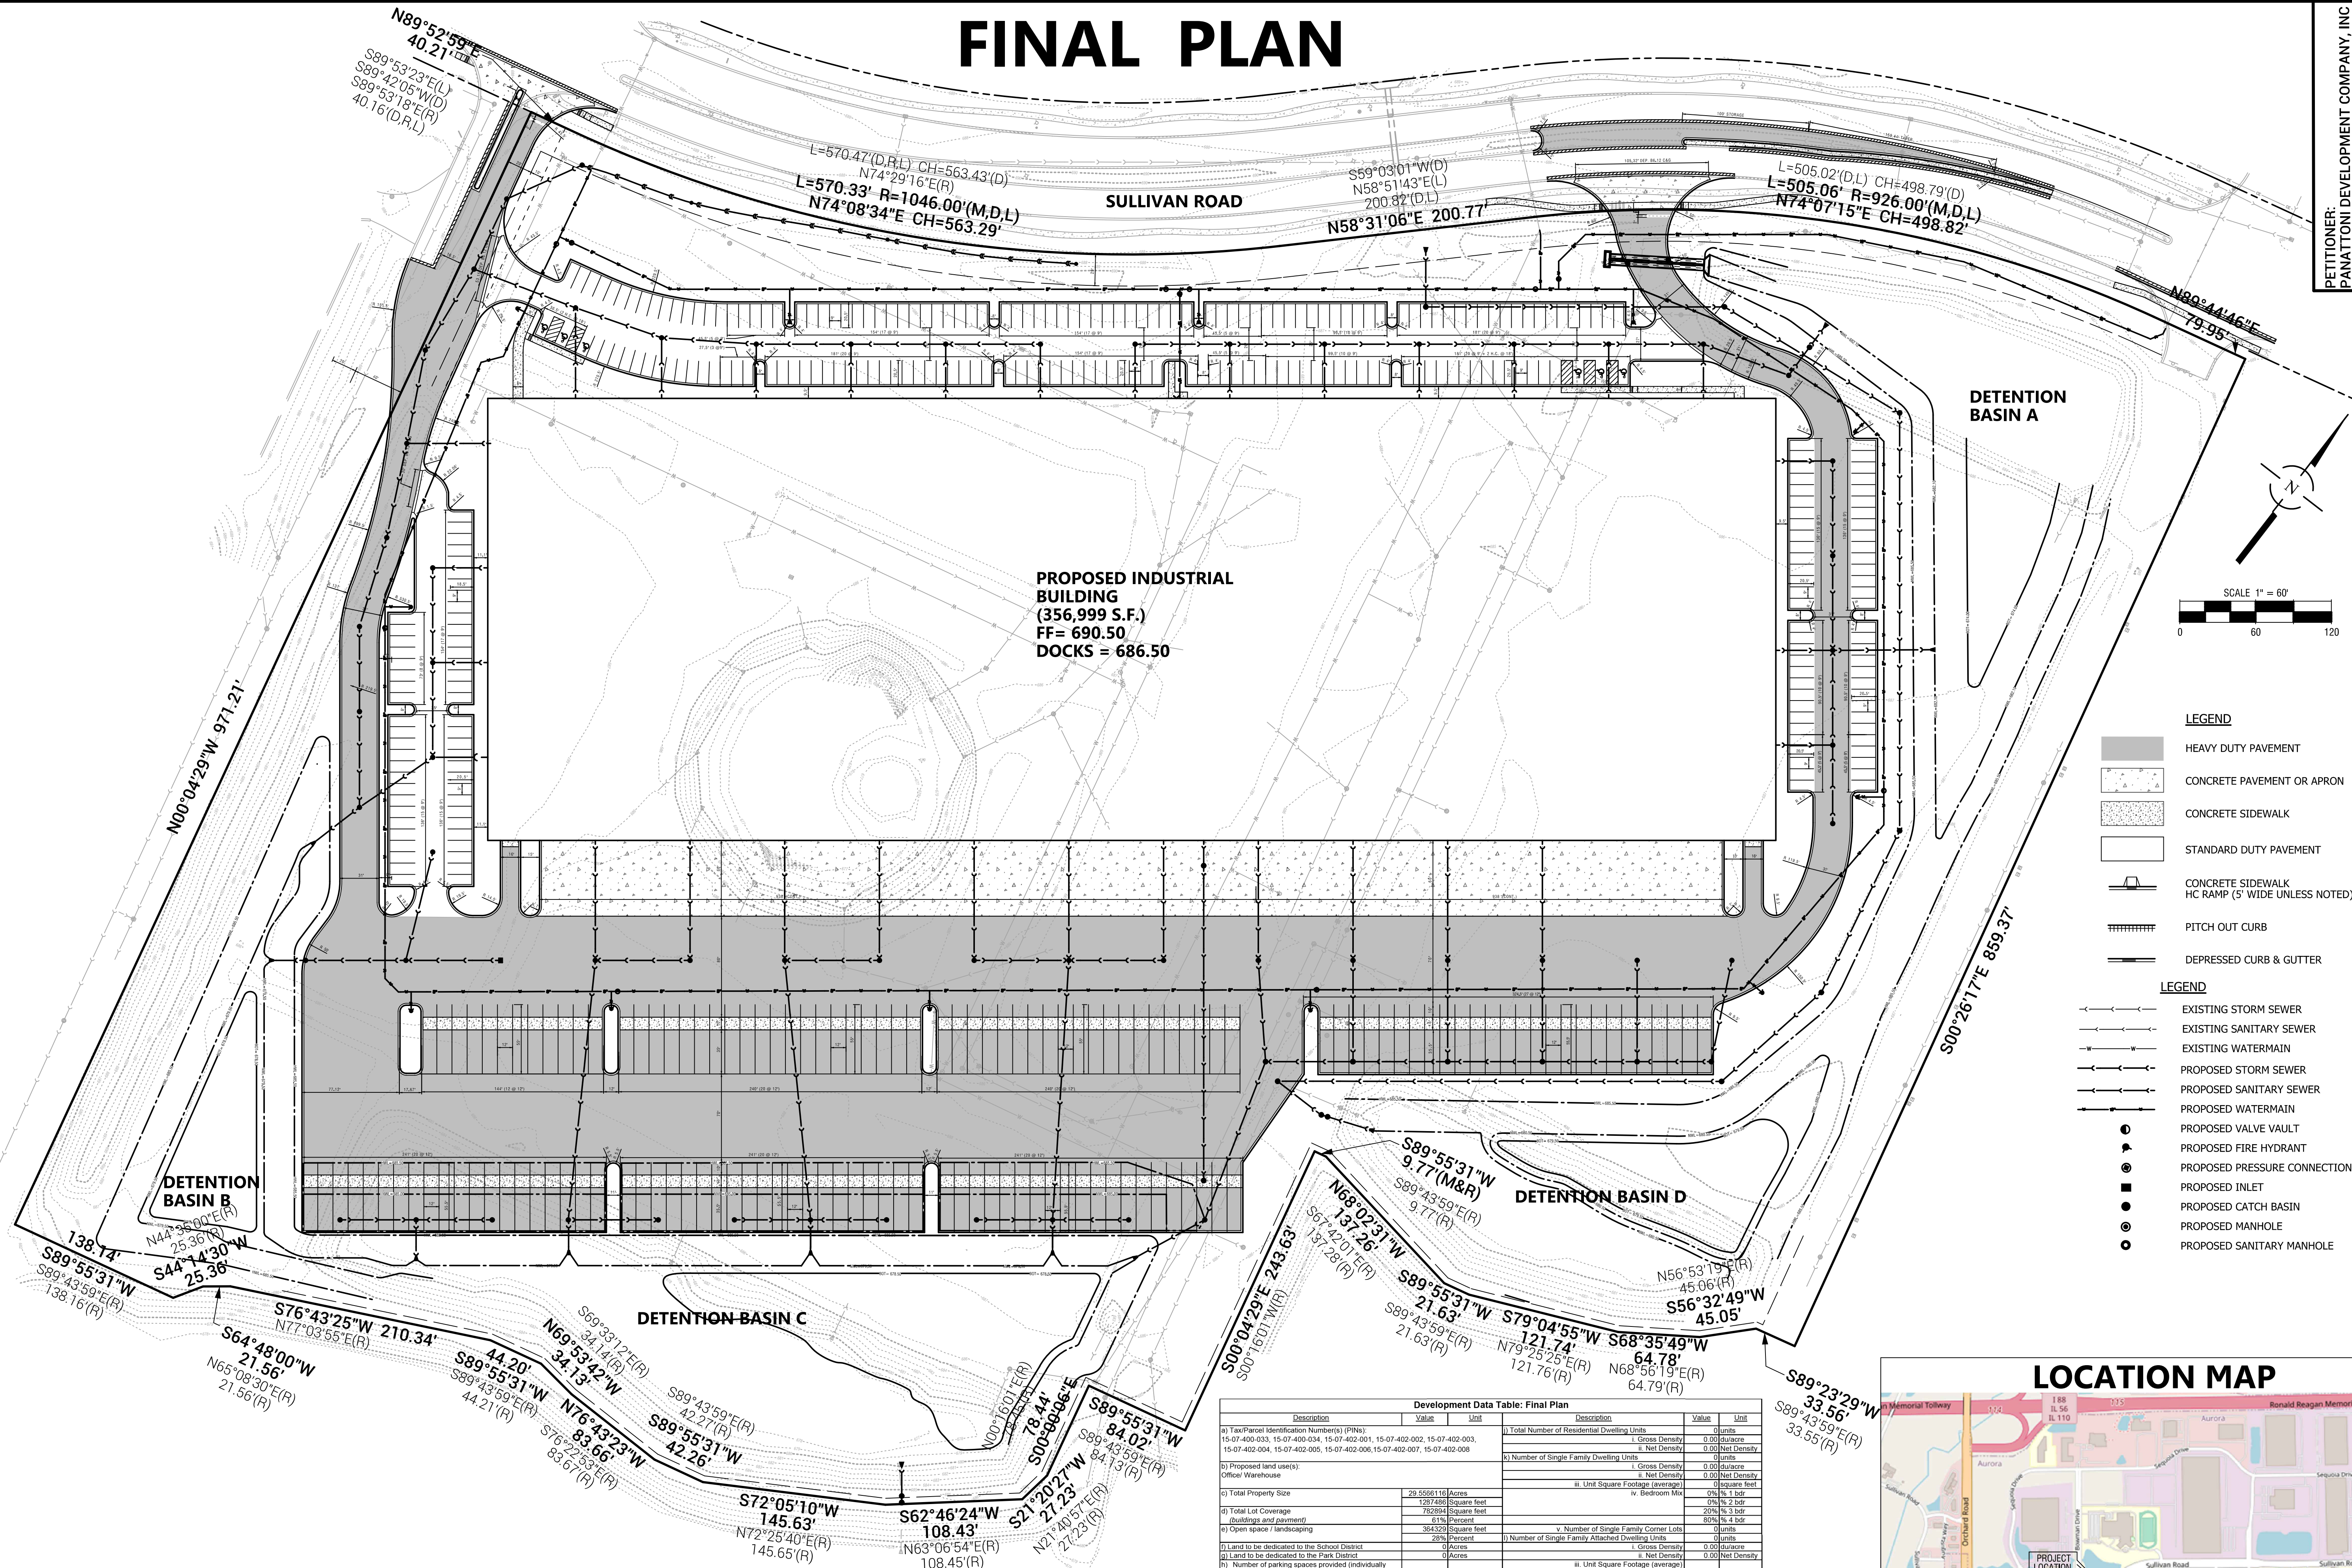

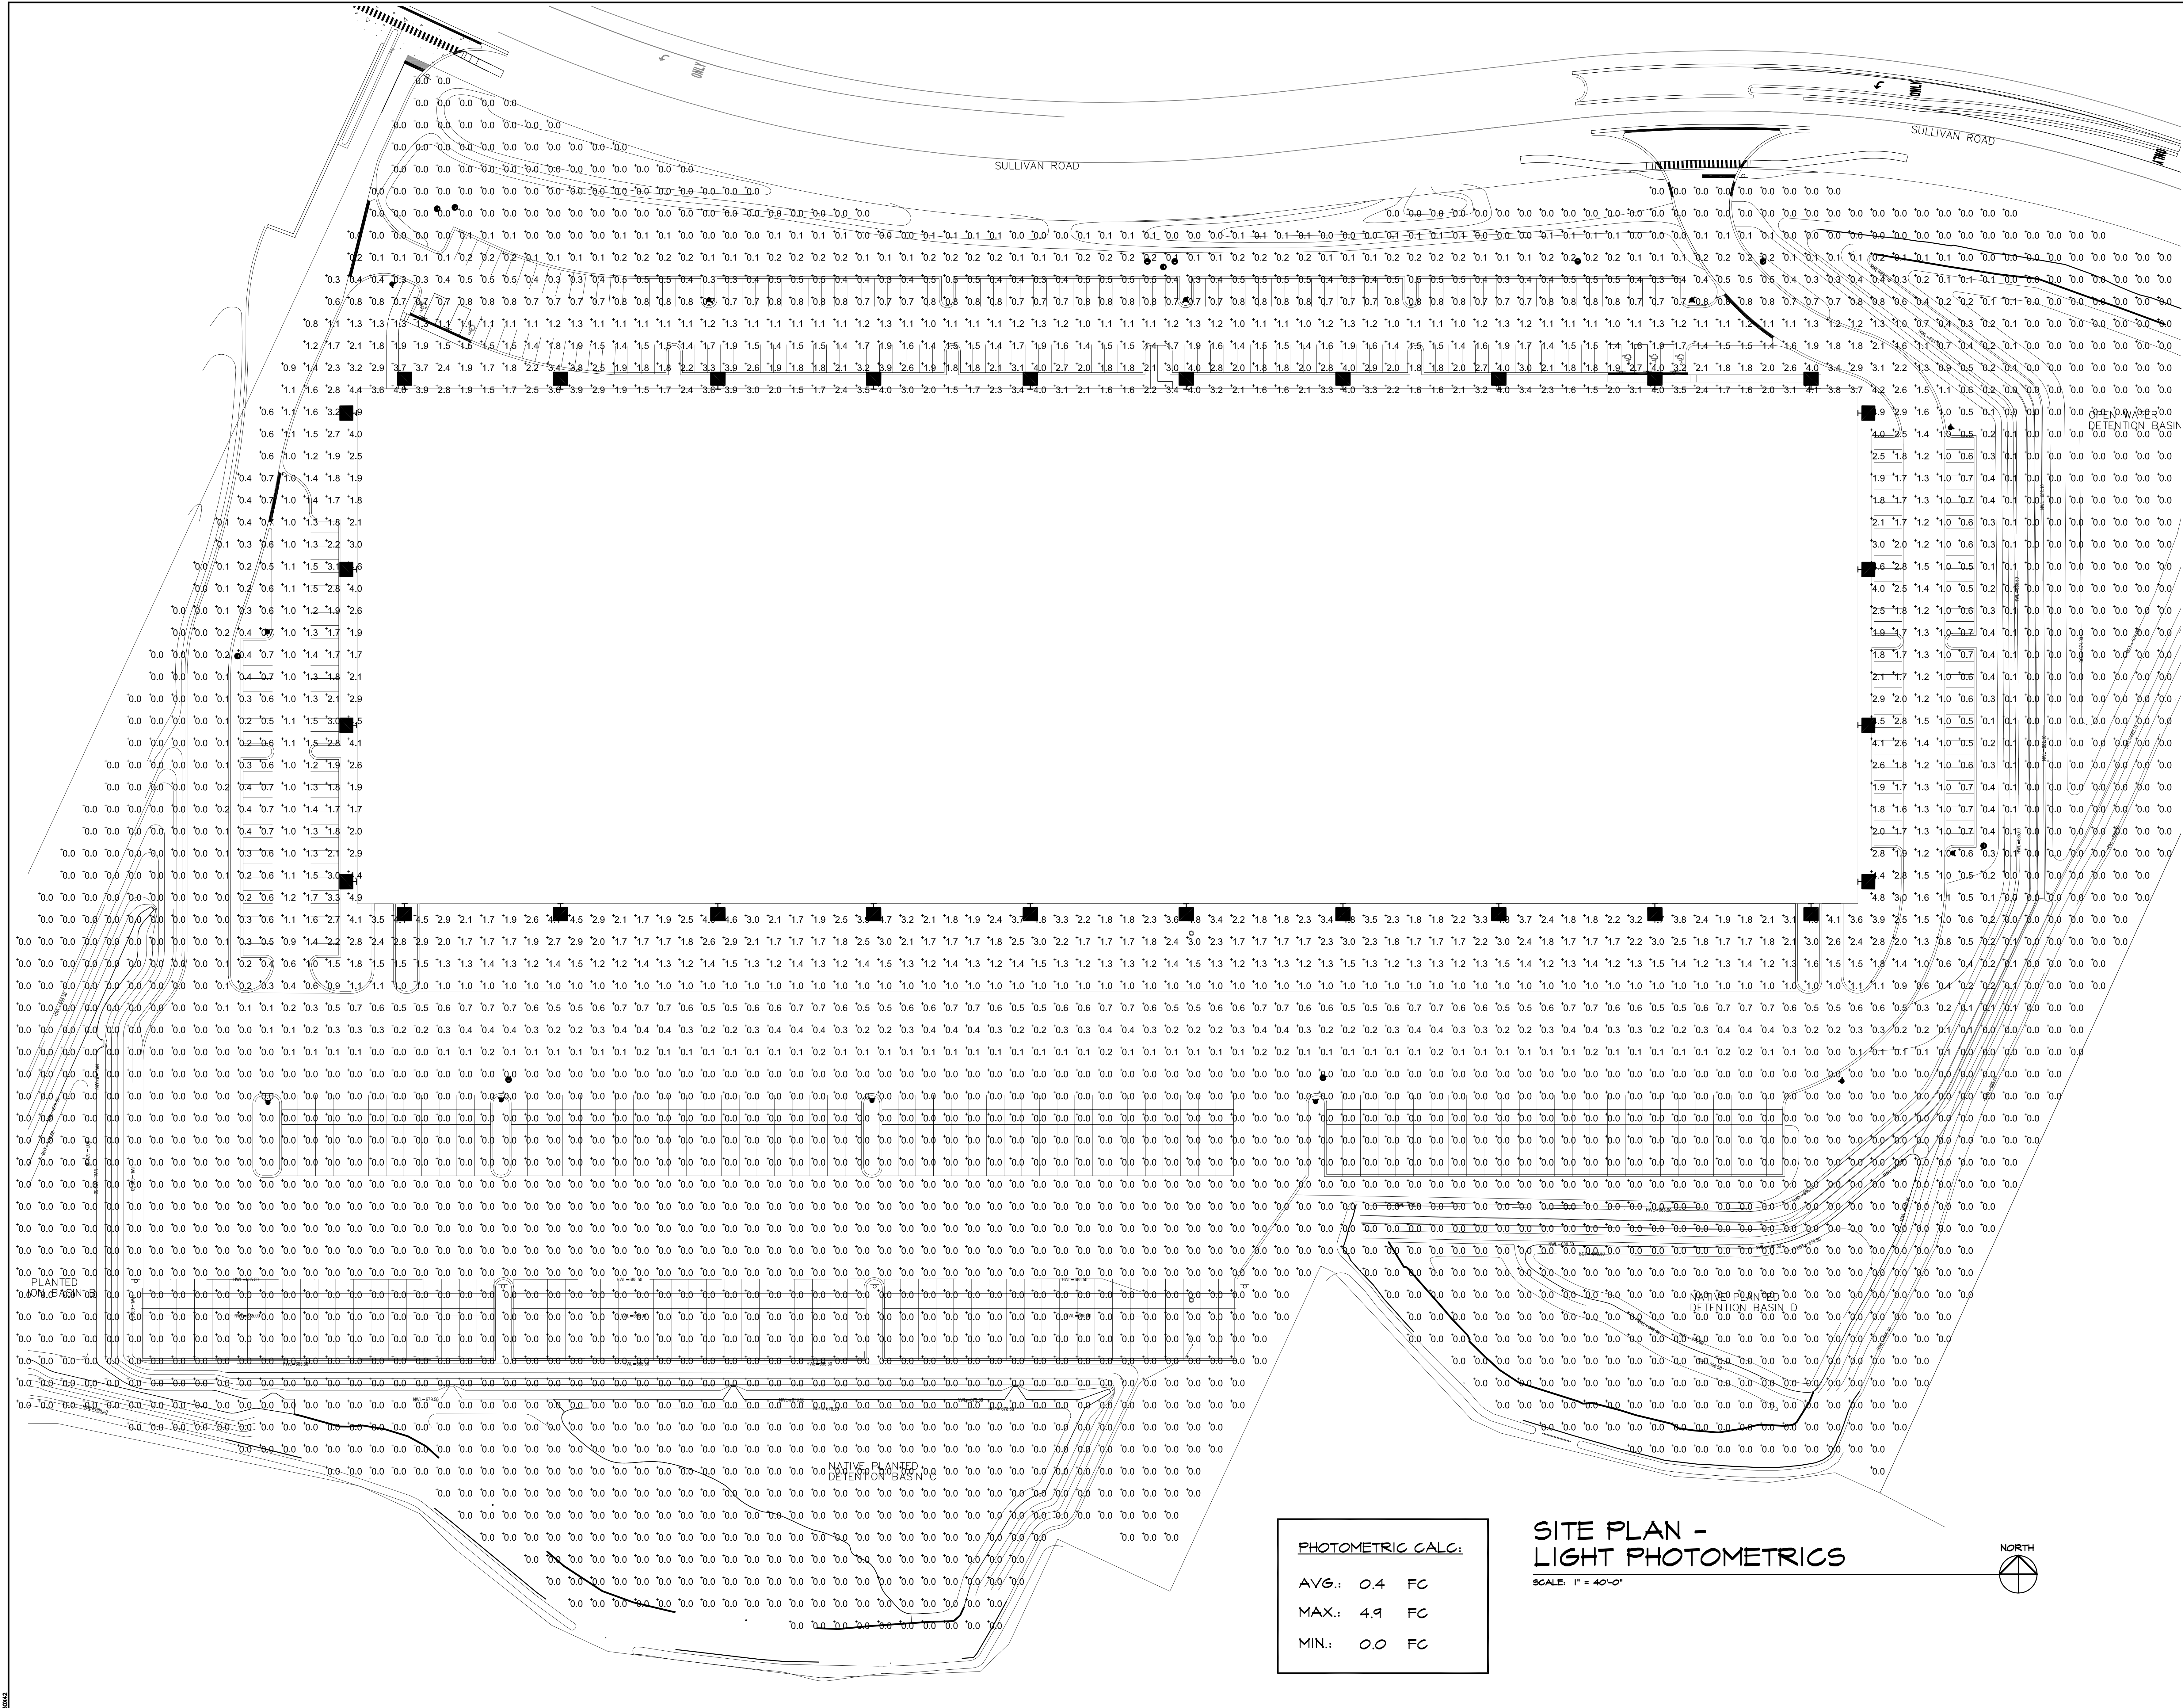

ABC Electrical Construction and Design L.L.C.

817 S. Kildare Ave
Chicago, IL 60624
P: 773.826.2620
F: 773.826.2620
www.abcelectric.com

DESIGN REGISTRATION NO.
184.005384

PROJECT:

Sullivan Road Industrial
Aurora, Illinois

REGISTRATION:

NO. 02/27/21

DESCRIPTION: ISSUE FOR PERMIT

DATE: 10/20/21

RE-USE FOR PERMIT

Expiration: 11/30/23

CHECKED BY: JD.

DRAWN BY: A.O.

SCALE: AS NOTED

DATE: -

SHEET TITLE:

Site Plan -
Light
Photometrics


SHEET NUMBER:

EP.1



Specifications

EPA (ft ² @0°):	0.57 ft ² (0.05 m ²)
Length:	21.8" (55.4 cm) (SPA mount)
Width:	13.3" (33.8 cm)
Height:	3.0" (7.6 cm) Main Body 7.2" (18.4 cm) Arm
Weight (max):	25.0 lbs (11.3 kg)

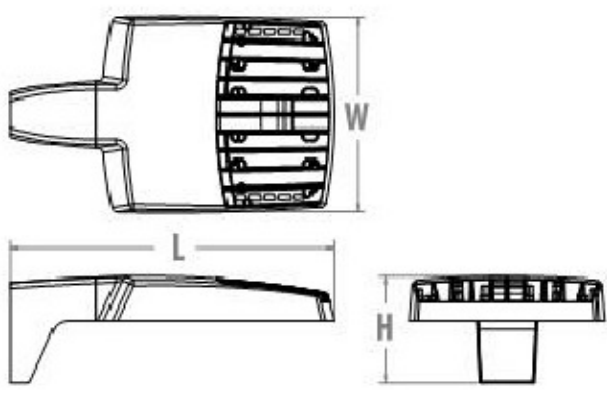

Catalog Number	
Notes	
Type	

Introduction

The new RSX LED Area family delivers maximum value by providing significant energy savings, long life and outstanding photometric performance at an affordable price. The RSX1 delivers 7,000 to 17,000 lumens allowing it to replace 70W to 400W HID luminaires.

The RSX features an integral universal mounting mechanism that allows the luminaire to be mounted on most existing drill hole patterns. This "no-drill" solution provides significant labor savings. An easy-access door on the bottom of mounting arm allows for wiring without opening the electrical compartment. A mast arm adaptor and an adjustable integral slip-fitter are also available.


Ordering Information

Series	Performance Package	Color Temperature	Distribution	Voltage	Mounting
RSX1 LED	P1 P2 P3 P4	30K 3000K 40K 4000K 50K 5000K	R3 Type 1 Wide R4 Type 1 Wide R5 Type 5 Wide RSS Type 5 Short AFR Automotive Front Row	120V ¹ 120V-277V ¹ 480V ¹ 480V-480V ² (use specific voltage for options as noted) 120 ³ 277 ¹ 208 ⁴ 347 ⁴ 240 ⁵ 480 ⁵	SPA Square pole mounting (Min. 3.0" x 3.0" for 1 at 90°, Min. 3.5" x 3.5" for 2, 3, 4 at 90°) RPA Round pole mounting (3.7" min pole dia. for 1, 2, 3 or 4 at 90°) MA Mast arm adaptor (fits 2-3/4" x 10" horizontal truss) IS Adjustable slipfitter (fits 2-3/8" OD truss) ⁴ WSA Wall bracket

Options		Finish	
Shipped Installed			
HS	House-side shield	DOBBD	Dark Bronze
PE	Photocell, button style ^{1,2}	DBLXD	Black
PEX	Photocell external threaded, adjustable ^{1,2}	DNAXD	Natural Aluminum
PIR	Seven-wire twist-lock receptacle only (no controls) ^{1,3,4}	DNWDX	White
CE34	Conduit entry 3/4" NPT (Qty 2)	DOBTD	Textured Dark Bronze
SF	Single face (120, 277, 347) ¹	DBLTD	Textured Black
DF	Double face (208, 240, 480) ¹	DNAXD	Textured Natural Aluminum
SPD20KV	20KV Surge pack (10KV standard)	DNWDX	Textured White
FAO	Field adjustable output		
DMG	0-10V load wires extended (no controls)		
Shipped Separately (requires some field assembly)			
E6S	External glare shield		
E6V	External glare full view (360° around light aperture)		
GBY	Grid spikes ¹⁰		
*Note: Sensor coverage pattern is affected when luminaire is tilted.			

LIGHT FIXTURE SPECIFICATION

Sullivan Road Industrial
Aurora, Illinois

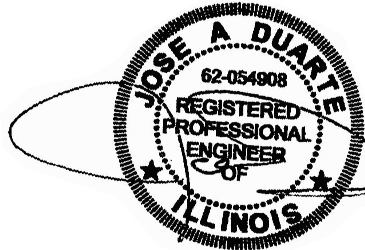

Expiration: 11/30/23

REVISION:	DATE:	DESCRIPTION:
NO.	09/27/21	ISSUE FOR PERMIT
	10/28/21	RE-ISSUE FOR PERMIT

CHECKED BY:	J.D.
DRAWN BY:	A.O.
SCALE:	AS NOTED
DATE:	-

SHEET TITLE:
Specs & Details

SHEET NUMBER:
EP.2