


LANDSCAPE PLAN

for the Aurora University Learning Commons

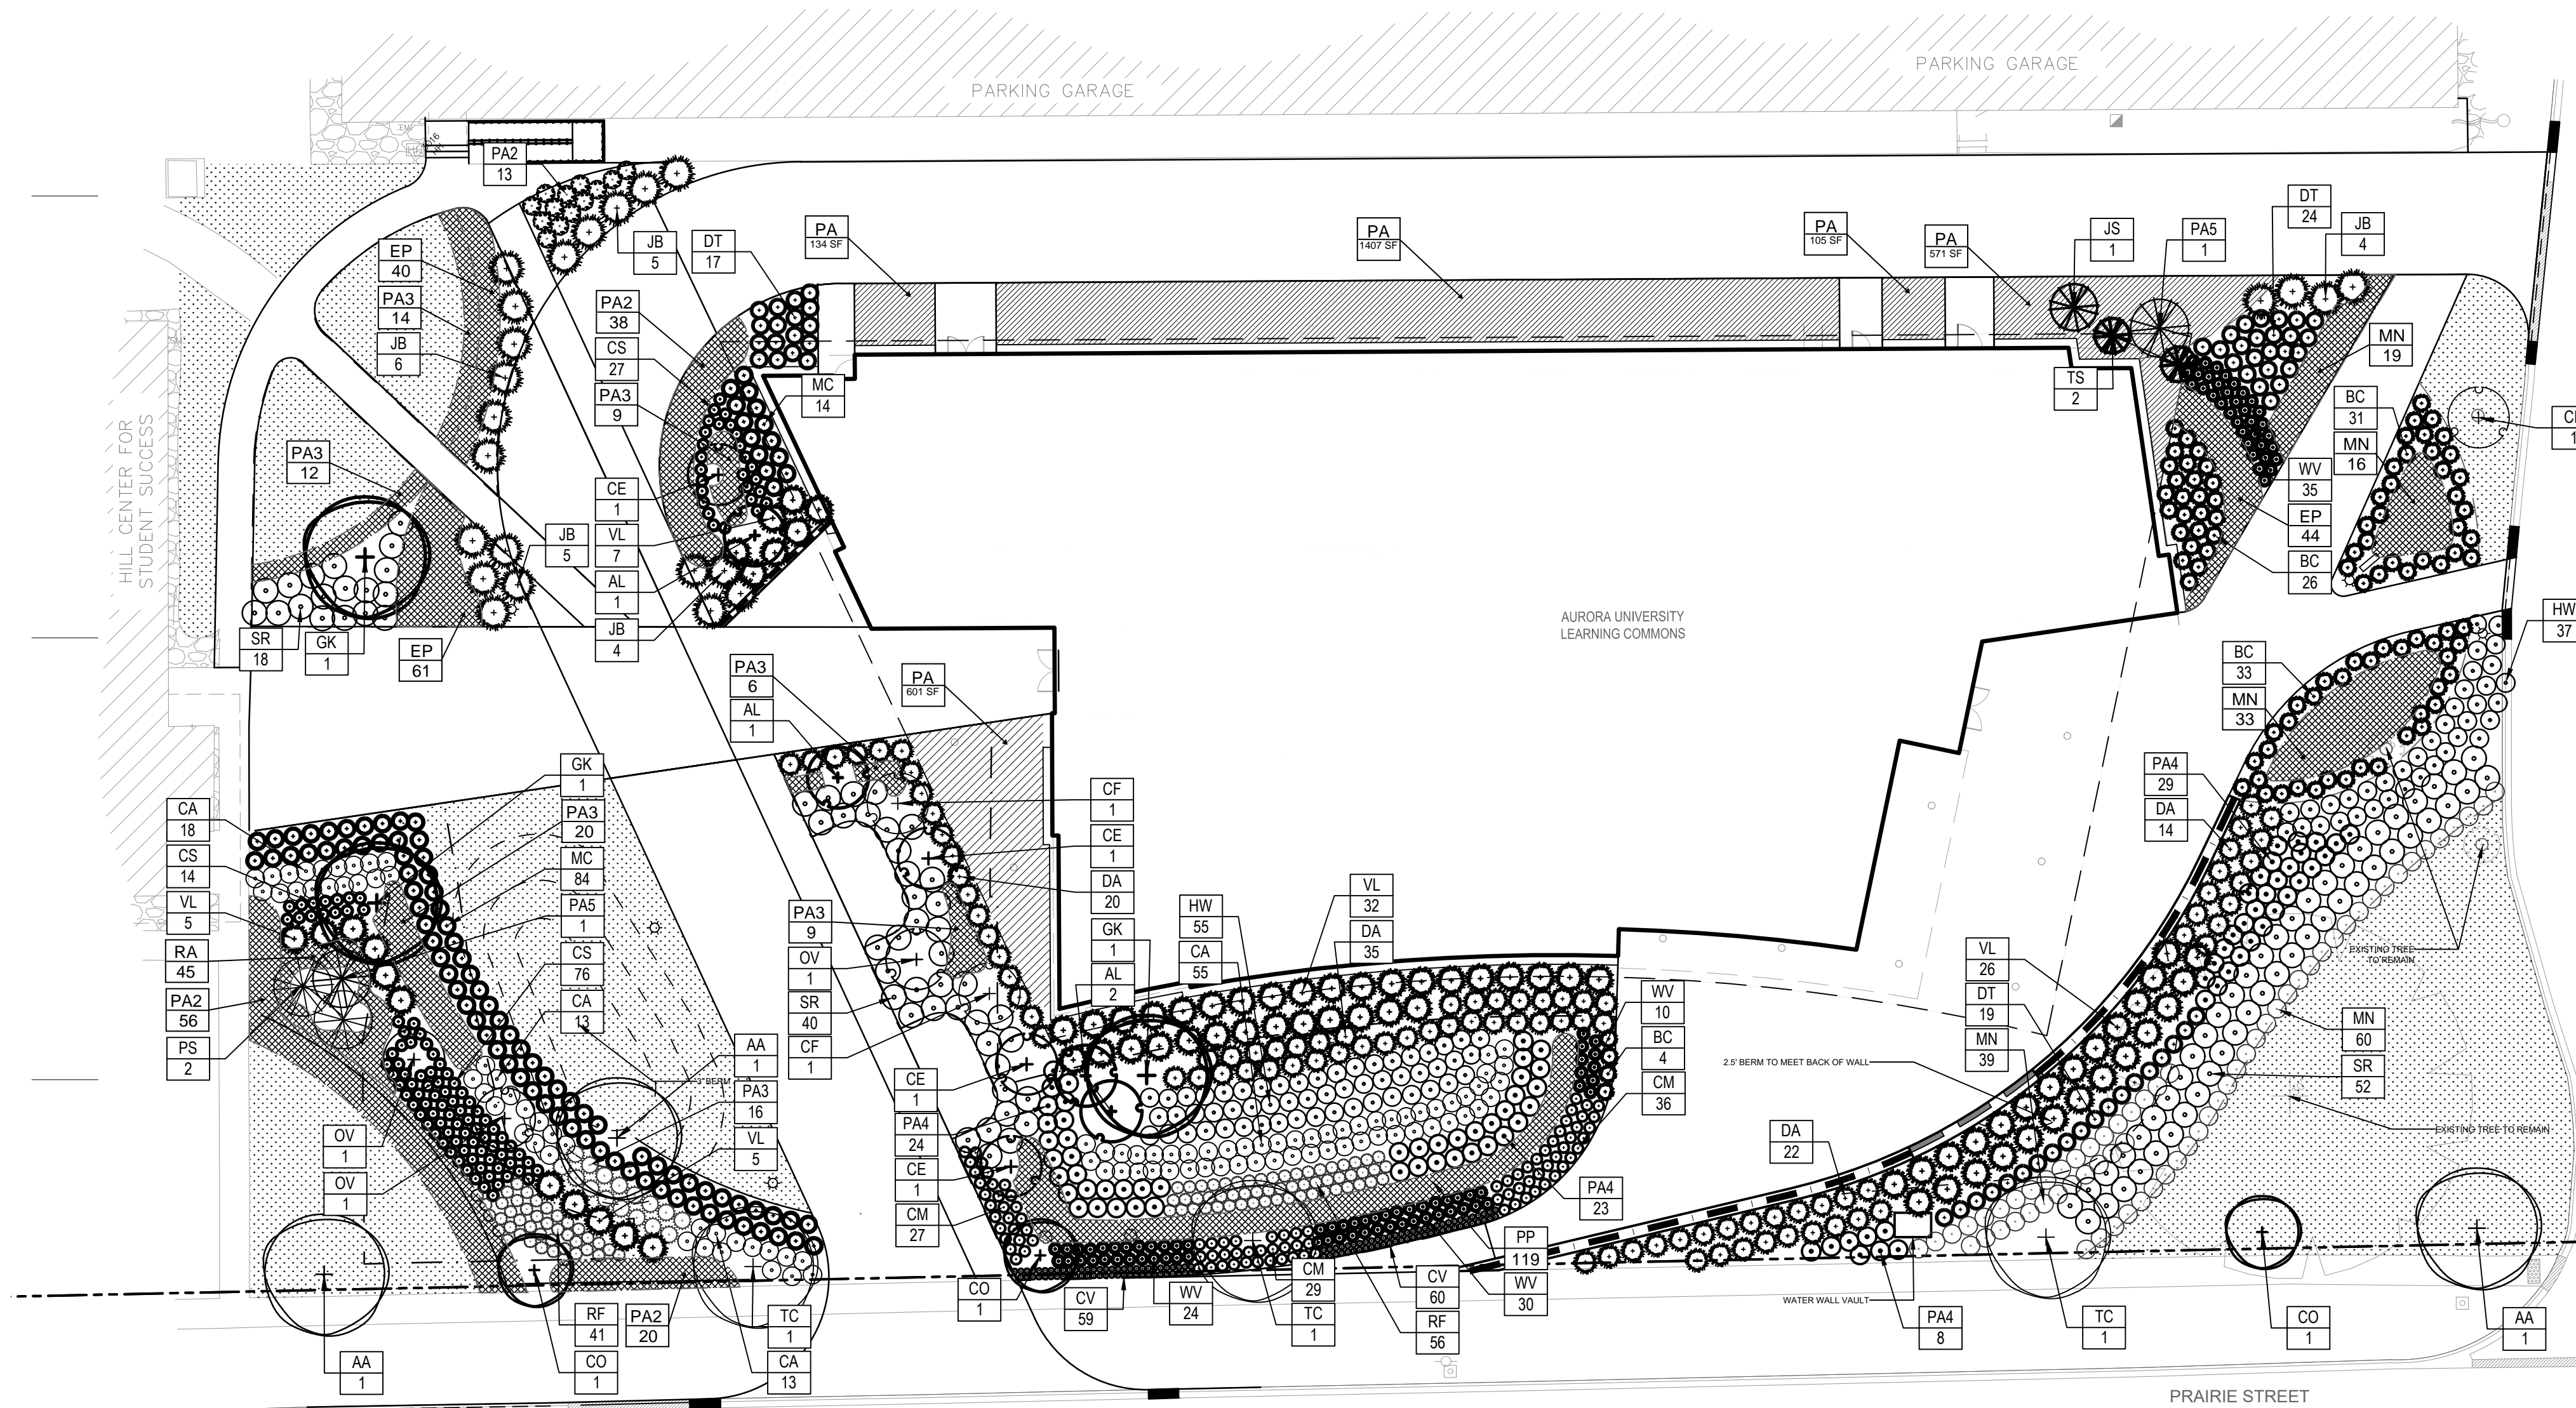


Landscape Implementation Data Table: Plant List by Category							
	QTY	Percent	SYM	BOTANICAL NAME (Family / Genus / Species)	COMMON NAME	SIZE	COMMENTS
Canopy Trees	3	25%	GK	Gymnodiax Delous	Kentucky Coffeetree	3' CAL	
	3	25%	CO	Calix Cordatilis	Common Hackberry	3' CAL	
	3	25%	AA	Acer X Freemanii 'Jeffersred'	Autumn Blaze Freeman Maple	3' CAL	
	3	25%	TC	Tilia Cordata	Littleleaf Linden	3' CAL	
	Total:	12	100%				
Evergreen Trees	2	25%	TS	Thuja Occidentalis 'Smaragd'	Emerald Green Arborvitae	5-8' HT	
	2	25%	PA5	Picea Abies	Norway Spruce	8-10' HT	
	2	25%	FS	Picea Glauca 'Alberta Globe'	Alberta Globe Dwarf White Spruce	8' HT	
	1	14%	JS	Juniperus Sppulorum 'Seynoid'	Skyrocket Juniper	8-10' HT	
	Total:	7	100%				
Understory Trees	4	29%	AL	Amelanchier laevis	Allegheny serviceberry multitrunk	6-8' HT	
	3	21%	CF	Cornus Florida	Flowering Dogwood	6-8' HT	
	4	33%	GE	Cercis Canadensis	Eastern Redbud Multitrunk	6-8' HT	
	3	21%	OV	Ostrya Virginiana	American Hophornbeam	3' CAL	
	Total:	14	100%				
Deciduous Shrubs	110	29%	SR	Symphoricarpos X 'Solfe'	Proud berry Coral Berry	2 GAL	
	99	26%	CA	Ceanothus Americanus	New Jersey Tea	2 GAL	
	92	24%	HW	Hydrangea Arborescens	Smooth Hydrangea	2 GAL	
	84	23%	FA4	Physocarpus Alamosi	Dwarf Ninebark	2 GAL	
	Total:	385	100%				
Evergreen Shrubs	91	24%	DA	Distylium X Picta/H'	Blue Cascade Distylium	2 GAL	
	90	25%	BC	Berberis Thunbergii 'Crimson Pynny'	Crimson Pynny Japanese Barberry	2 GAL	
	76	20%	VL	Viburnum Rhytidophyllum	Leatherleaf Viburnum	2 GAL	
	74	20%	JB	Juniperus Horizontalis 'Blue Rug'	Blue Rug Juniper	2 GAL	
	Total:	358	100%				
Perennials	99	26%	WV	Weigela Florida 'Verveig'	Ivy Monet Weigela	2 GAL	
	Total:	385	100%				
Perennials	146	20%	EP	Echinacea X Purple Emperor	Purple Coneflower	2 GAL	
	132	18%	MY	Monarda Filibacea	Wildfire Mountains Wild Bergamot	2 GAL	
	86	12%	PA3	Perovskia Abrotanoides	Russian Sage	2 GAL	
	117	16%	PA2	Pycnanthemum Albescens	Mountain Mint	2 GAL	
	119	16%	PP	Phlox Pilosa	Dowry Phlox	2 GAL	
Ornamental Grasses	142	19%	RF	Rudbeckia	Black Eyed Susan	2 GAL	
	Total:	742	100%				
	117	24%	CS	Calamagrostis X Autiflora 'Strick'	Karl Foerster Feather Reed Grass	2 GAL	
	92	19%	CM	Carex Muskingumensis	Palm Sedge	2 GAL	
	119	24%	CV	Carex Vulpinoidea	Fox Sedge	2 GAL	
Ornamental Grasses	96	20%	MC	Muhlenbergia Capillaris	Pink Muhly Grass	2 GAL	
	80	12%	DT	Deschampsia X Cespitosa	Tufted Hair Grass	2 GAL	
	Total:	496	100%				


	CTE Value	Count Provided	Total CTEs Provided
Canopy Trees	1	12	12
Evergreen Trees	1/3	7	2
Understory Trees	1/3	14	5
Deciduous Shrubs	1/20	385	19
Evergreen Shrubs	1/20	385	19
	Total:	803	58

Landscape Data Table: Planting Material Key	
Note: Symbols are blackline for proposed drawings for existing	
Canopy Trees (minimum size 2.5 caliper) Count:	12
Evergreen Trees (minimum size 6 feet) Count:	7
Understory Trees (minimum size 2.5 caliper or 8 feet if multi-stemmed) Count:	14
Evergreen Shrubs (minimum of 18 inches) Count:	365
Deciduous Shrubs (minimum of 18 inches) Count:	385
Ornamental Grasses Count:	486
Perennials Count:	742
Annuals Count:	
Groundcover Square Footage:	2818
Turf (seeded) Square Footage:	
Turf (sod) Square Footage:	9759
Native Prairie Planting Square Footage:	
Native Wetland Planting Square Footage:	


PROJECT VICINITY MAP

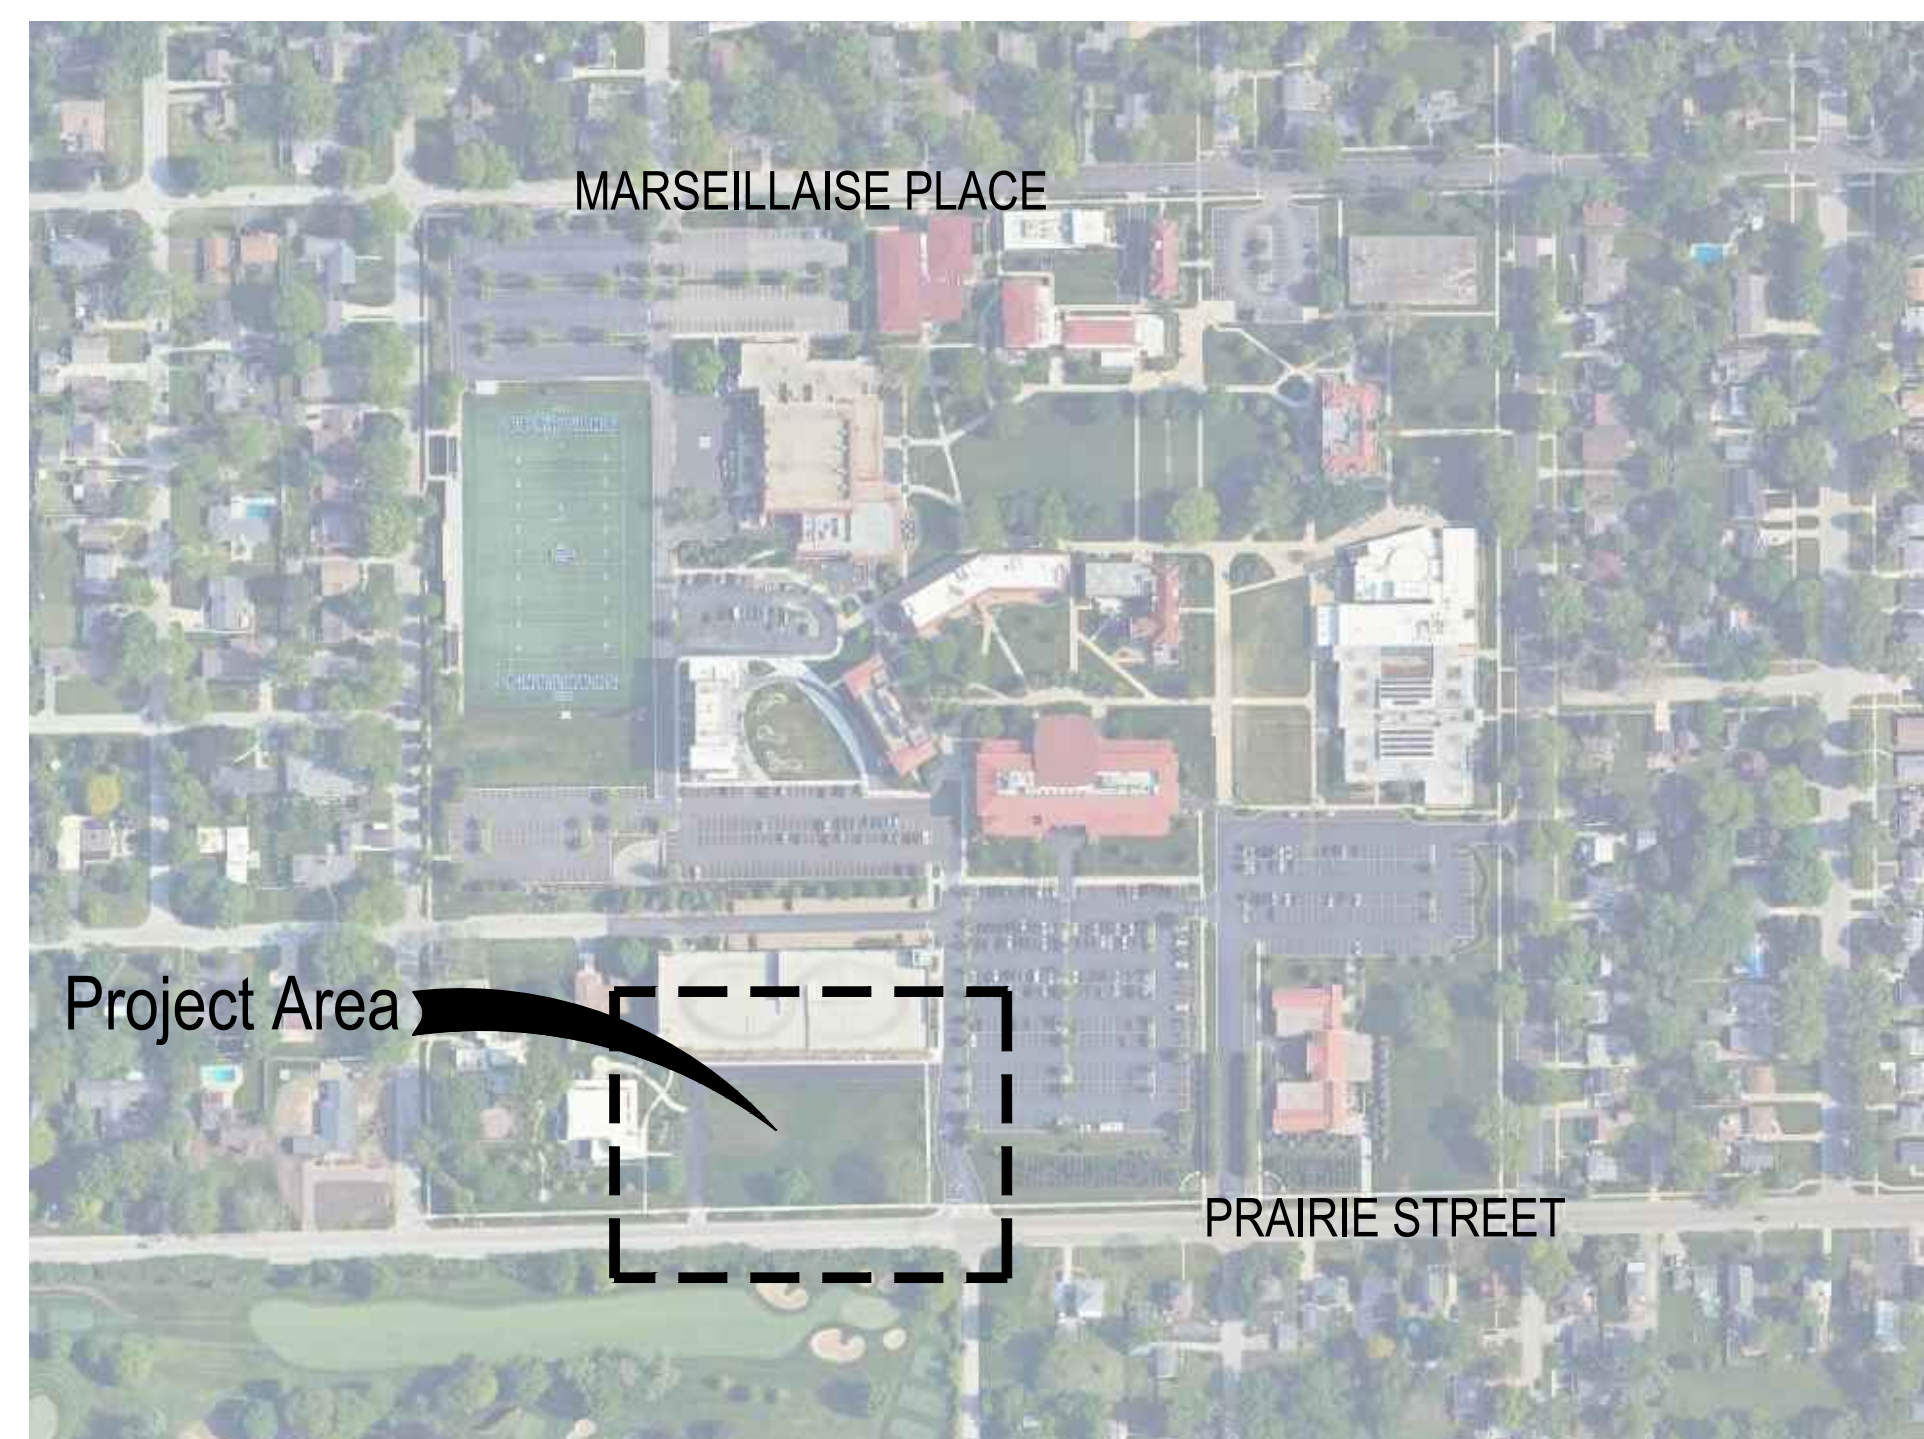

LEGEND OF SYMBOLS

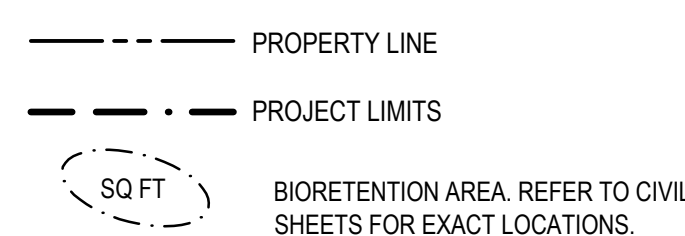


PAVING DETAILS

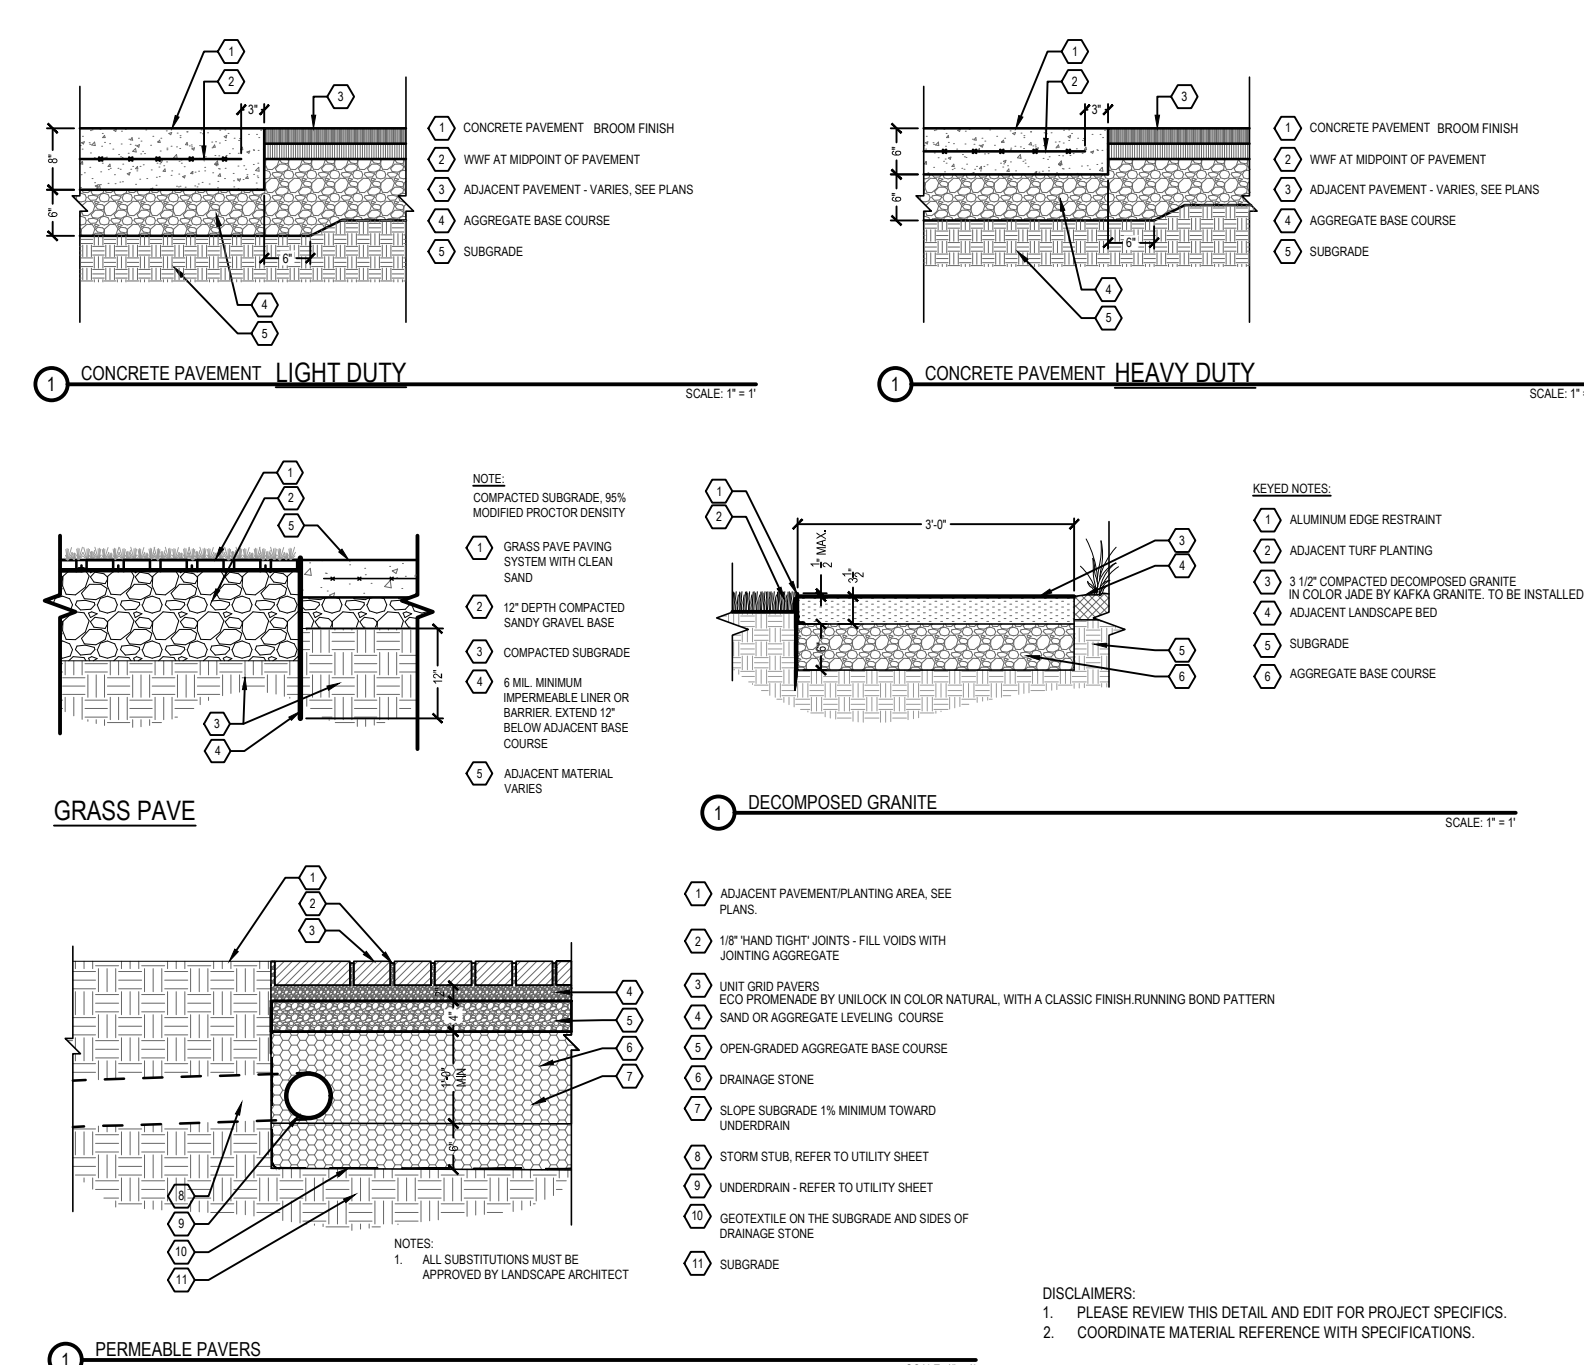

DISCLAIMERS:

 1. PLEASE REVIEW THIS DETAIL, AND EDIT FOR PROJECT SPECIFIC
2. COORDINATE MATERIAL REFERENCE WITH SPECIFICATIONS.



Aurora University Learning Commons
1419 Prairie Street
Aurora, IL, 60506

SMITHGROUP

35 EAST WACKER
SUITE 900
CHICAGO, IL 60601
312.641.0770
smithgroup.com

LANDSCAPE PLAN
for the Aurora University
Learning Commons

ISSUED FOR	DATE
------------	------

PLANNING & ZONING RESUBMISSION	05.13.2025
PLANNING & ZONING RESUBMISSION	05.06.2025
PLANNING & ZONING RESUBMISSION	04.02.2025
PLANNING & ZONING SUBMISSION	03.20.2025


SEALS AND SIGNATURES

KEYPLAN



SHEET TITLE

LANDSCAPE PLAN

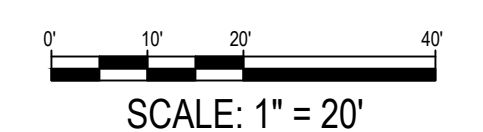

PROJECT NUMBER

SHEET NUMBER

2-7



35 EAST WACKER
SUITE 900
CHICAGO, IL 60601
312.641.0770
smithgroup.com

RETAINING WALL DETAILS

for the Aurora University
Learning Commons

ISSUED FOR	DATE
<i>PLANNING & ZONING RESUBMISSION</i>	<i>.05.13.2025</i>
<i>PLANNING & ZONING RESUBMISSION</i>	<i>05.06.2025</i>
<i>PLANNING & ZONING RESUBMISSION</i>	<i>04.02.2025</i>


SEALS AND SIGNATURES

KEYPLAN



SHEET TITLE


RETAINING WALL DETAILS

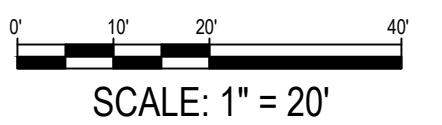

PROJECT NUMBER

2-7B

 SHEET NUMBER




SCALE: 1" = 1'

- 1 CONCRETE RETAINING WALL
- 2 STAINLESS STEEL WELDED SPILLWAY PAN
- 3 GRANITE VENEER BY ASL STONE COLOR: SUMMIT BLACK GRANITE. FINISH: HONED
- 4 PERMEABLE PAVERS. SEE SHEET C3.3.
- 5 IN GROUND LIGHT FIXTURE, SEE SITE LIGHTING AND ELECTRICAL PLANS.
- 6 STAINLESS STEEL TRENCH DRAIN. SEE CIVIL DRAWINGS.
- 7 WALL FOOTING
- 8 WATER VAULT TO CONTAIN PUMP, FILTER, AUTO FLOAT PUMP SHUT OFF DEVICE, FLOW CONTROLLER AND ANY OTHER NECESSARY PARTS. SEE SITE LAYOUT PLAN FOR SPECIFIC LOCATION.
- 9 BLACK FLEX PIPE IN PROTECTIVE SLEEVE
- 10 #5 @ 12 REBAR



SCALE: N/A

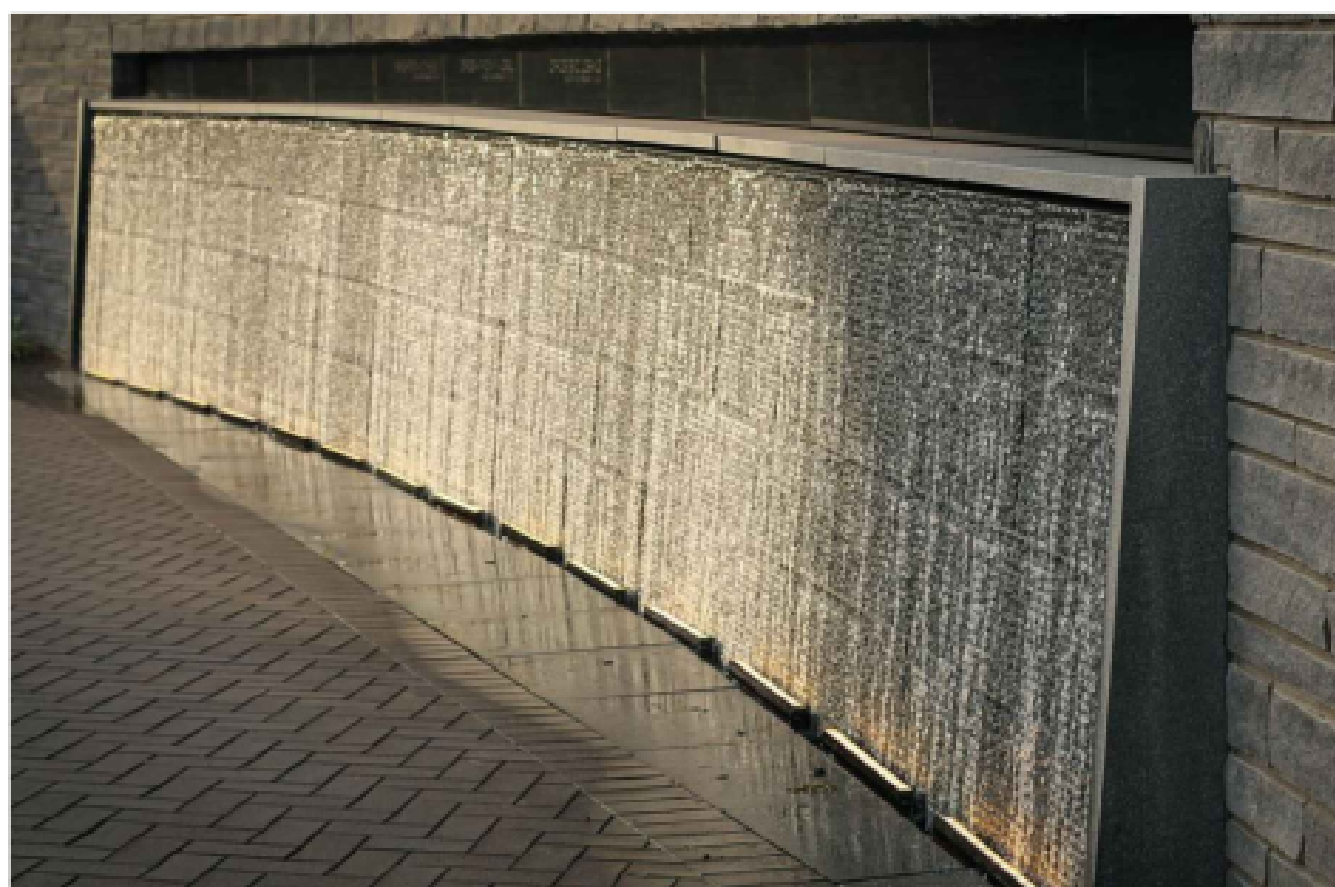

④ WATER WALL

SCALE: N/A