

CLARK ST. PUMP STATION

FOR

CITY OF AURORA AURORA, ILLINOIS

INDEX OF SHEETS

SHEET NUMBER	SHEET TITLE
1	COVER
2	LEGEND
3	GENERAL NOTES
4	SITE PLAN
5	STRUCTURAL MODIFICATIONS
6	LIFT STATION MODIFICATIONS
7	ELECTRICAL DEMOLITION PHOTOS
8	WET WELL AND VALVE VAULT ELECTRICAL PLAN
9	ELECTRICAL – PUMP STATION MODIFICATIONS
10	ELECTRICAL DETAILS
11	ELECTRICAL DETAILS



AURORA CITY COUNCIL

MAYOR	RICHARD C. IRVIN
ALDERMAN—AT—LARGE	SHERMAN J. JENKINS
ALDERMAN—AT—LARGE	RON WOERMAN
ALDERMAN – FIRST WARD	EMMANUEL LLAMAS
ALDERWOMAN – SECOND WARD	JUANY GARZA
ALDERMAN – THIRD WARD	TED MESIACOS
ALDERMAN – FOURTH WARD	BILL DONNELL
ALDERMAN – FIFTH WARD	CARL FRANCO
ALDERMAN – SIXTH WARD	MICHAEL SAVILLE
ALDERWOMAN – SEVENTH WARD	SCHEKETA HART—BURNS
ALDERWOMAN – EIGHTH WARD	PATTY SMITH
ALDERMAN – NINTH WARD	EDWARD BUGG
ALDERMAN – TENTH WARD	SHWETA BAID

UTILITIES

UTILITY TYPE	COMMON NAME
WATER & SEWER	CITY OF AURORA
ELECTRIC	COMED
TELEPHONE	AT&T
GAS	NICOR
CABLE	COMCAST

(CONTRACTOR TO BE RESPONSIBLE FOR ANY ADJUSTMENTS TO BE MADE.)

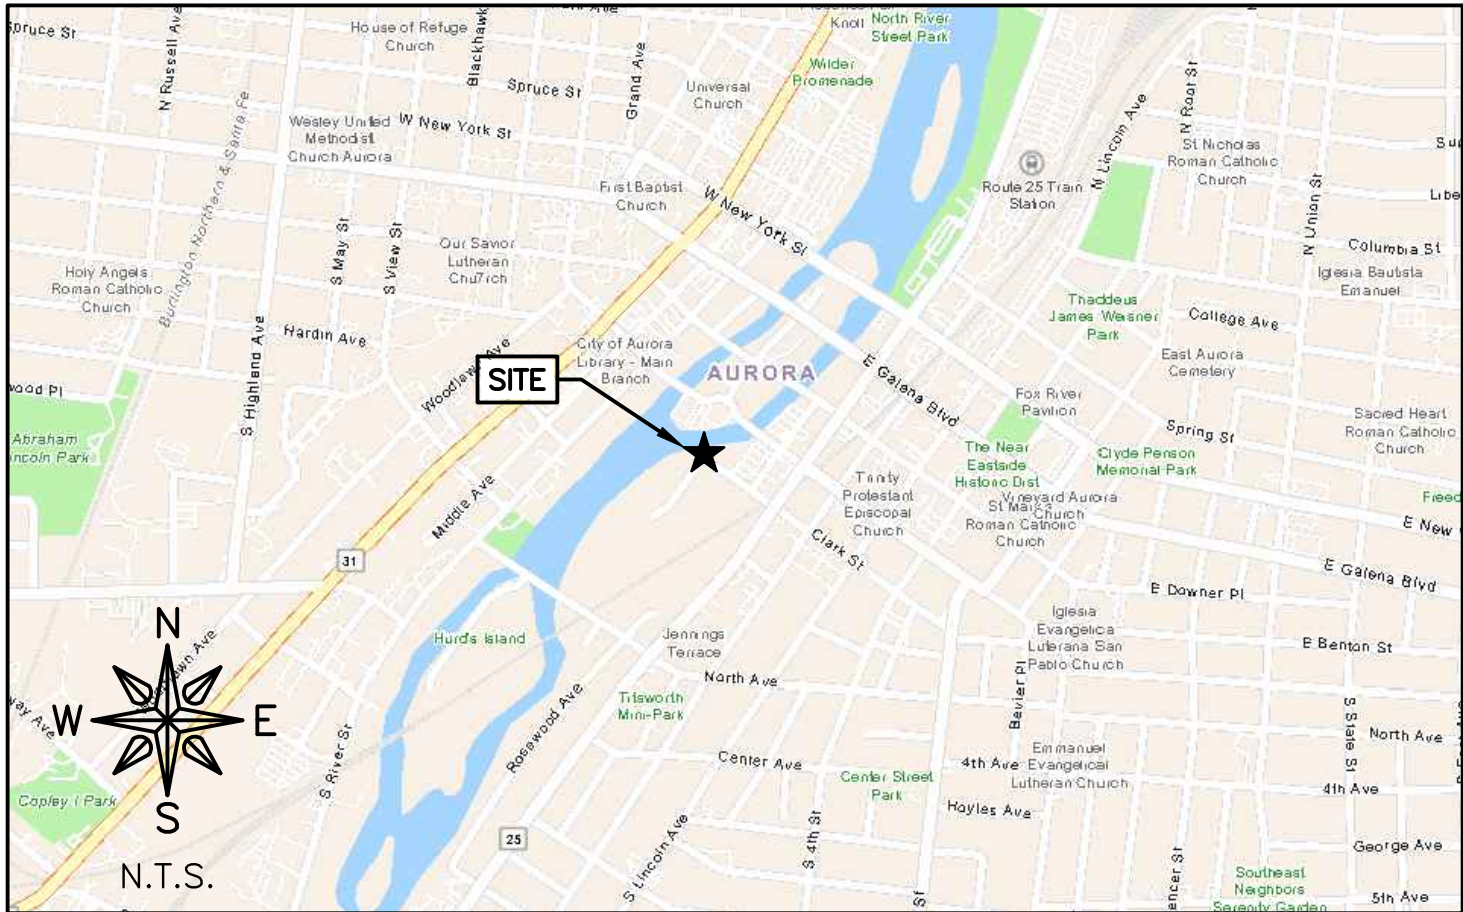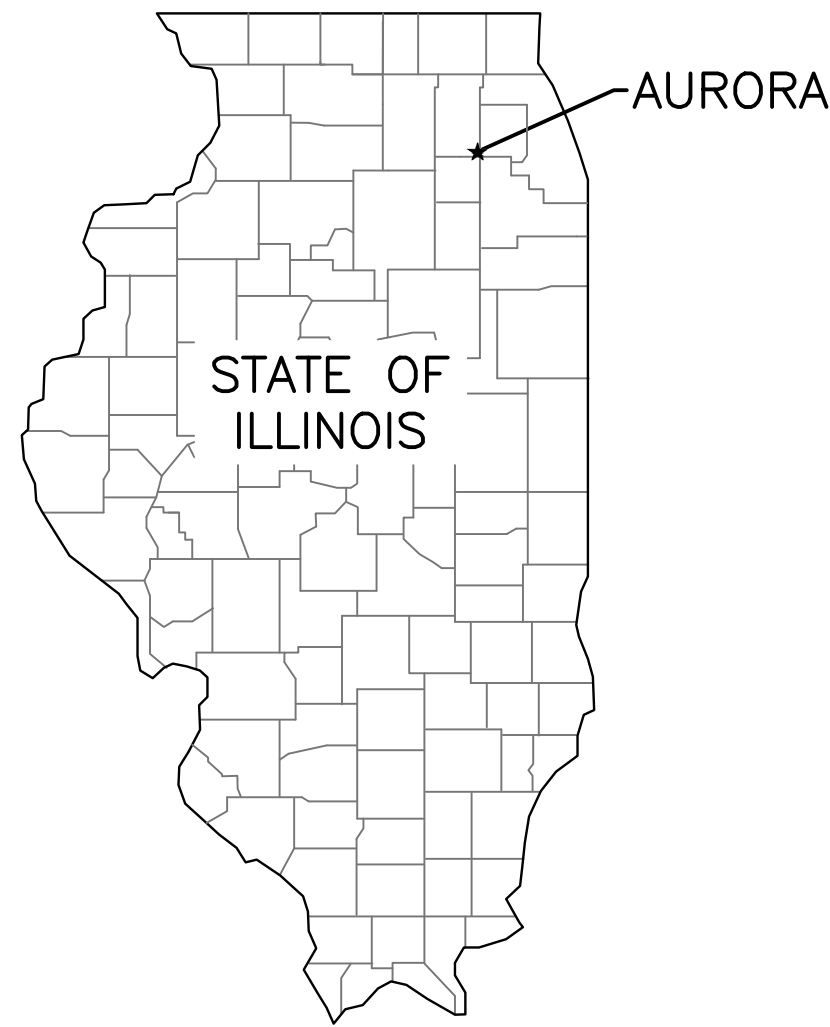

LOCATION MAP

FEHR GRAHAM
ENGINEERING & ENVIRONMENTAL

ILLINOIS

IOWA

WISCONSIN

ILLINOIS PROFESSIONAL DESIGN FIRM NUMBER: 184003525



BID SET

ORIGINAL SET FOR PROJECT: 22-694		DATE CREATED: 3-10-23
REVISIONS		
REV. NO.	DESCRIPTION	DATE

WHITE EAGLE LIFT STATION

FOR

CITY OF AURORA AURORA, ILLINOIS

Sheet List Table

SHEET NUMBER	SHEET TITLE
1	COVER
2	LEGEND
3	GENERAL NOTES
4	SITE PLAN
5	WET WELL & VALVE VAULT DEMOLITION
7	WET WELL, VALVE VAULT, & FLOW METER ELECTRICAL
8	CONTROL BUILDING ELECTRICAL MODIFICATIONS
10	ELECTRICAL DETAILS
11	ELECTRICAL DETAILS



AURORA CITY COUNCIL

MAYOR	RICHARD C. IRVIN
ALDERMAN-AT-LARGE	SHERMAN J. JENKINS
ALDERMAN-AT-LARGE	RON WOERMAN
ALDERMAN - FIRST WARD	EMMANUEL LLAMAS
ALDERWOMAN - SECOND WARD	JUANY GARZA
ALDERMAN - THIRD WARD	TED MESIACOS
ALDERMAN - FOURTH WARD	BILL DONNELL
ALDERMAN - FIFTH WARD	CARL FRANCO
ALDERMAN - SIXTH WARD	MICHAEL SAVILLE
ALDERWOMAN - SEVENTH WARD	SCHEKETA HART-BURNS
ALDERWOMAN - EIGHTH WARD	PATTY SMITH
ALDERMAN - NINTH WARD	EDWARD BUGG
ALDERMAN - TENTH WARD	SHWETA BAID


UTILITIES

UTILITY TYPE	COMMON NAME
WATER & SEWER	CITY OF AURORA
ELECTRIC	COMED
TELEPHONE	AT&T
GAS	NICOR
CABLE	CONCAST

 (CONTRACTOR TO BE RESPONSIBLE FOR ANY ADJUSTMENTS TO BE MADE.)

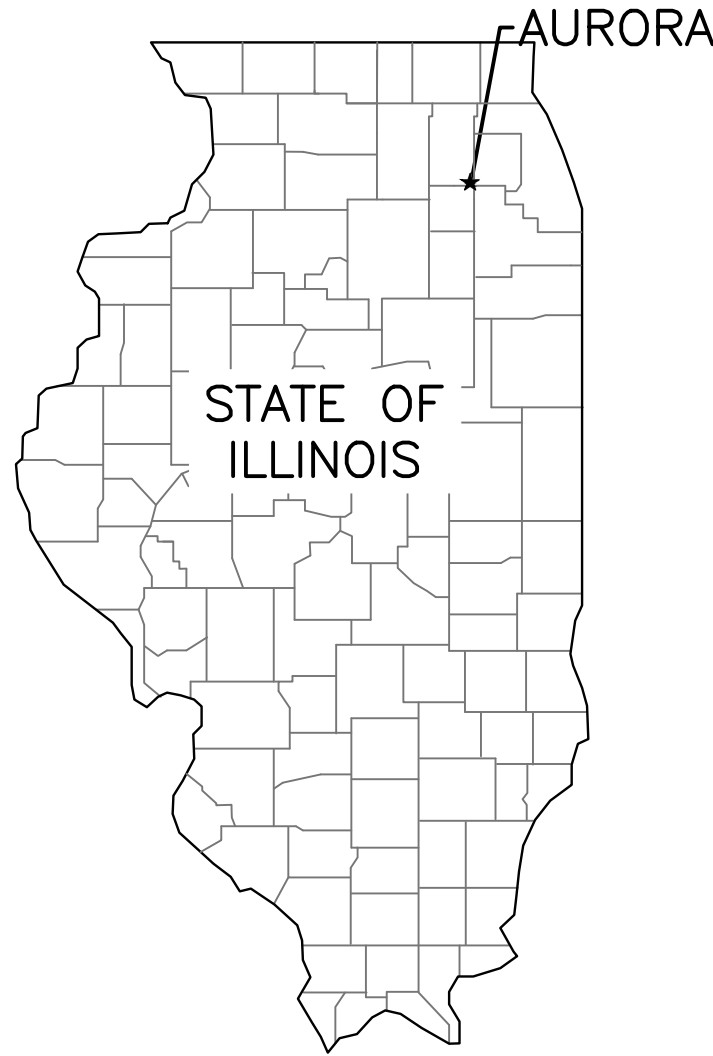

PLAN & PROFILE

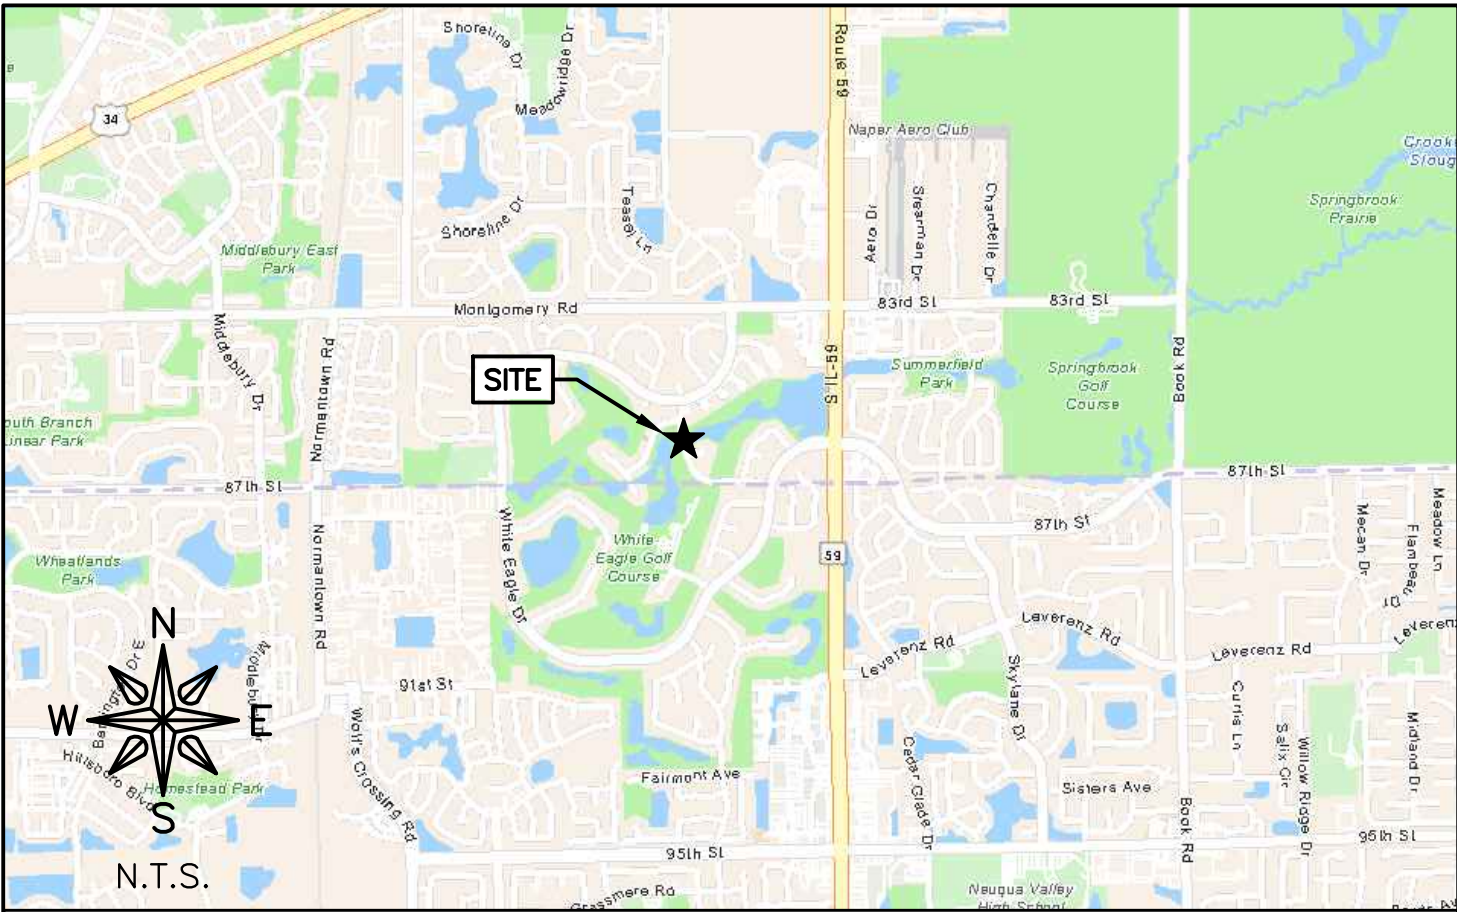

LOCATION MAP

FEHR GRAHAM
ENGINEERING & ENVIRONMENTAL

ILLINOIS IOWA WISCONSIN

ILLINOIS PROFESSIONAL DESIGN FIRM NUMBER: 184003525



BID SET

ORIGINAL SET FOR PROJECT: 22-694		DATE CREATED: 3-10-23
REVISIONS		
REV. NO.	DESCRIPTION	DATE