

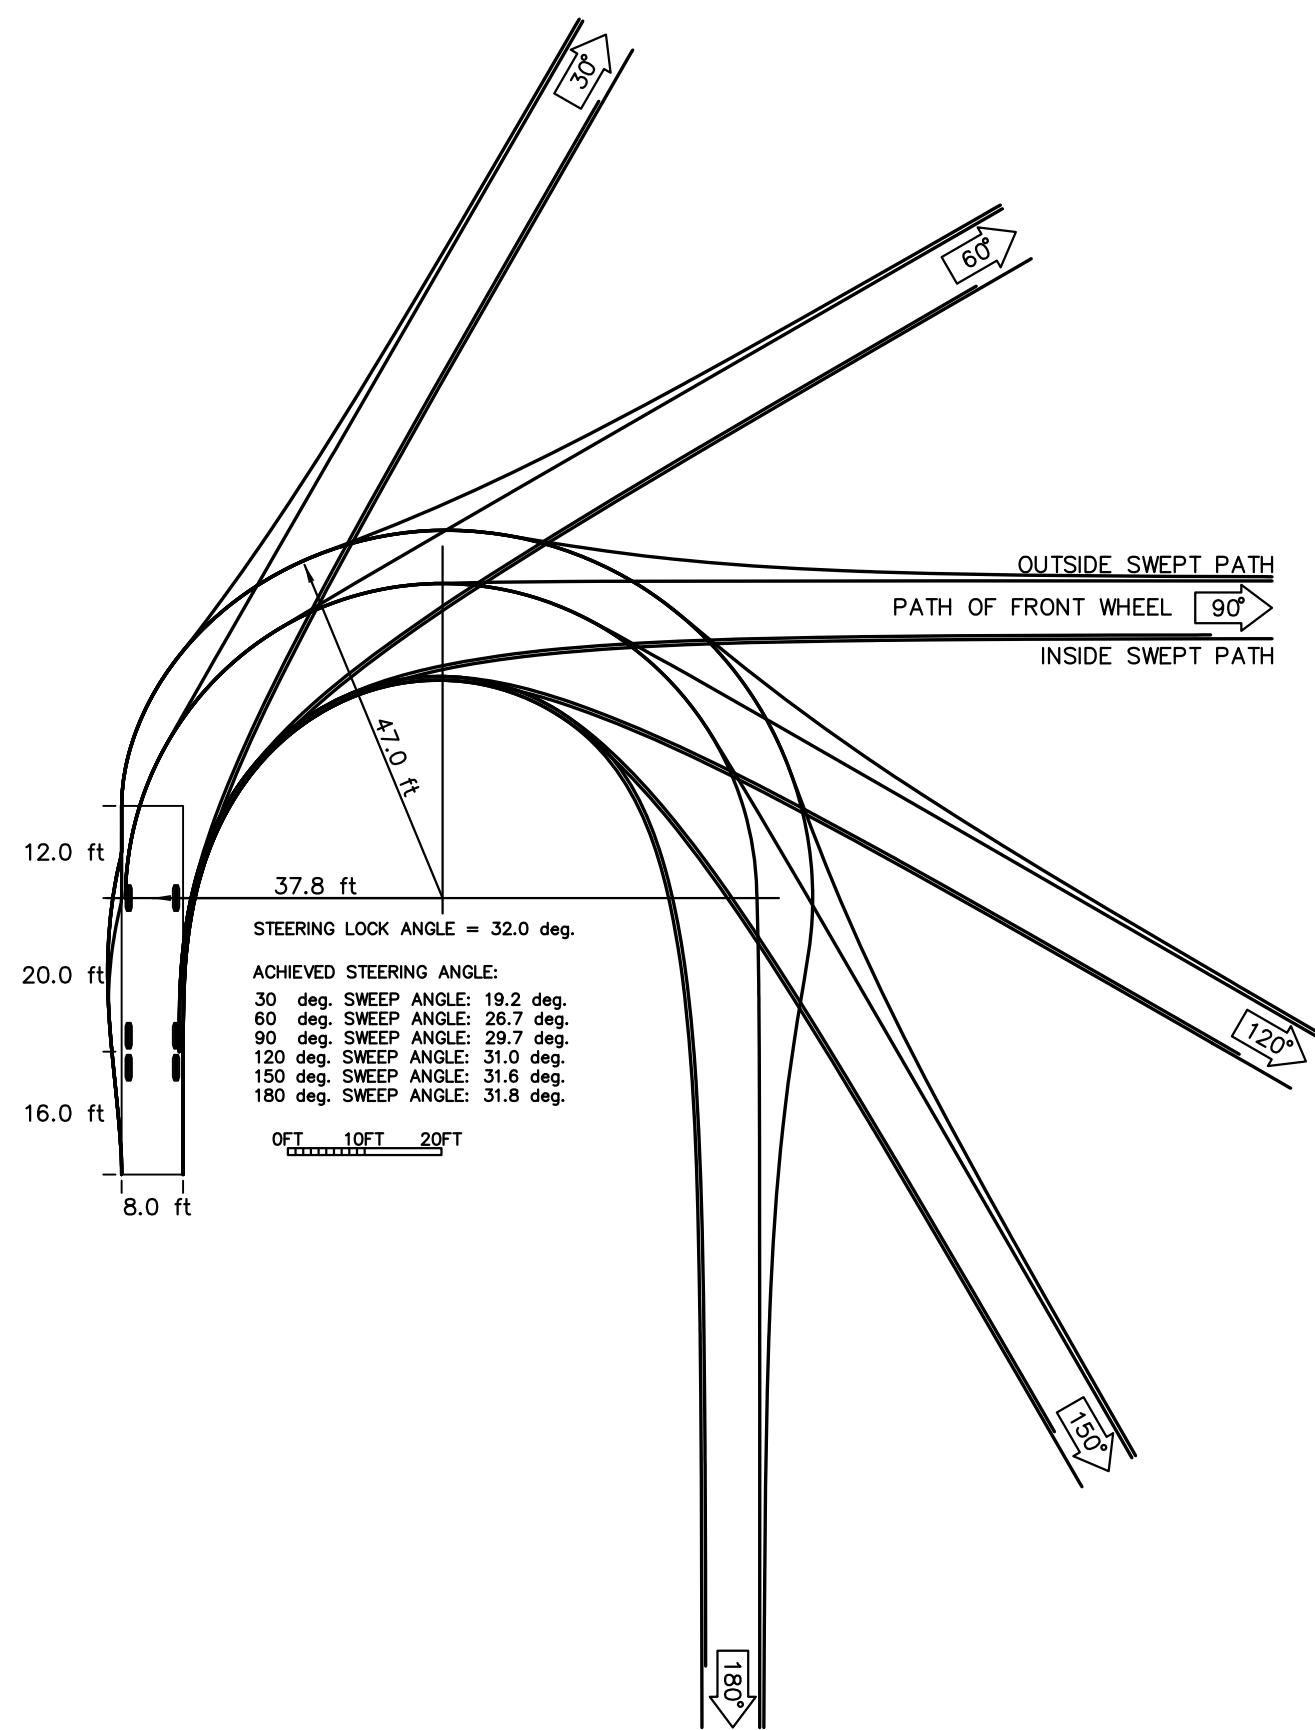
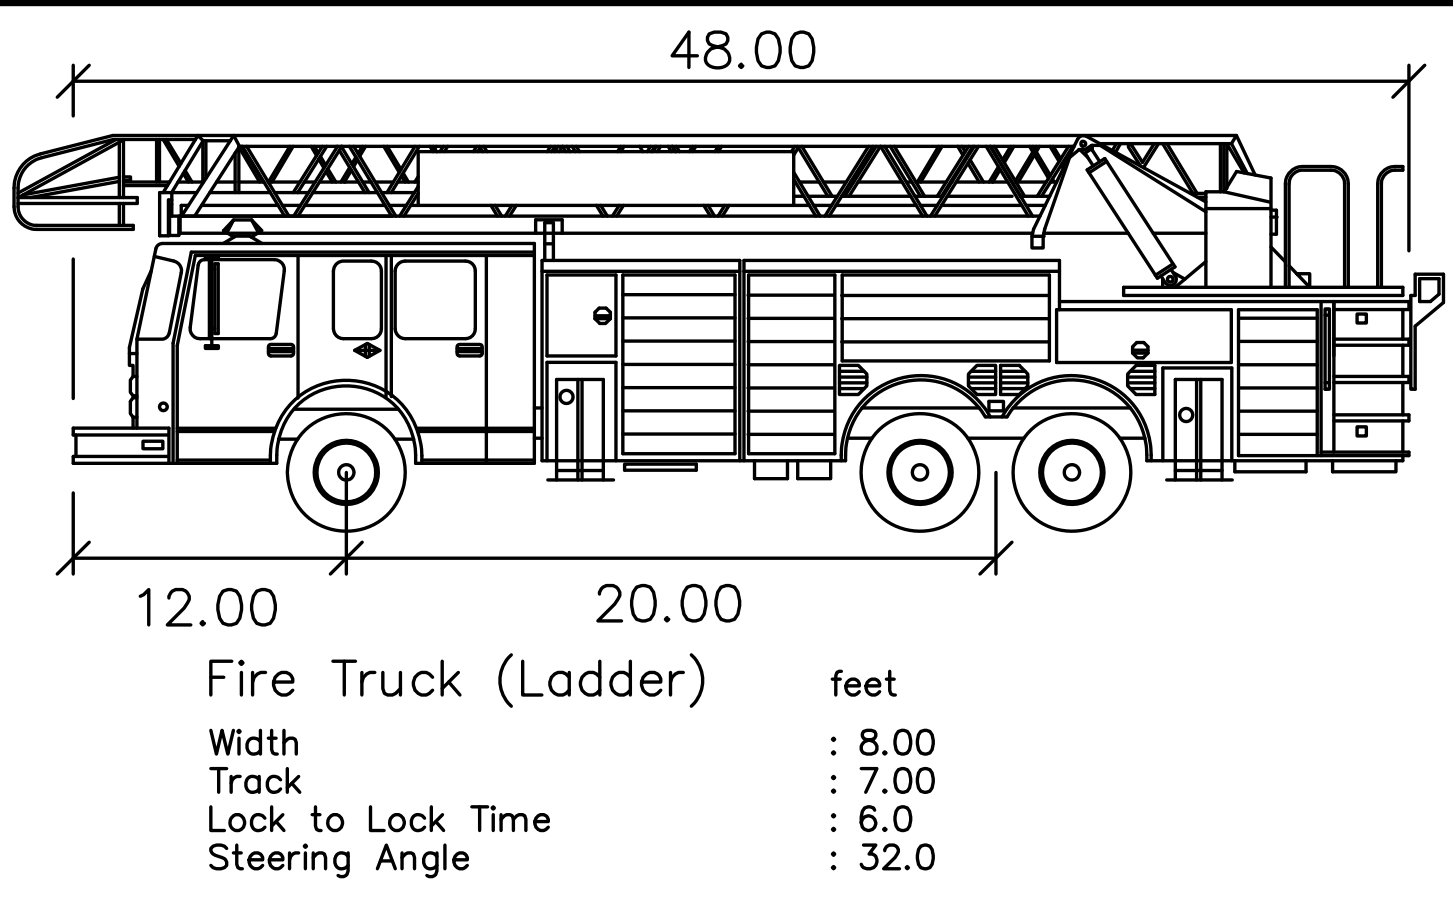


FIRE ACCESS PLAN
FOR
ORCHARD ROAD BUSINESS PARK (LOT 12)
2413 ORCHARD ROAD
AURORA, IL 60506

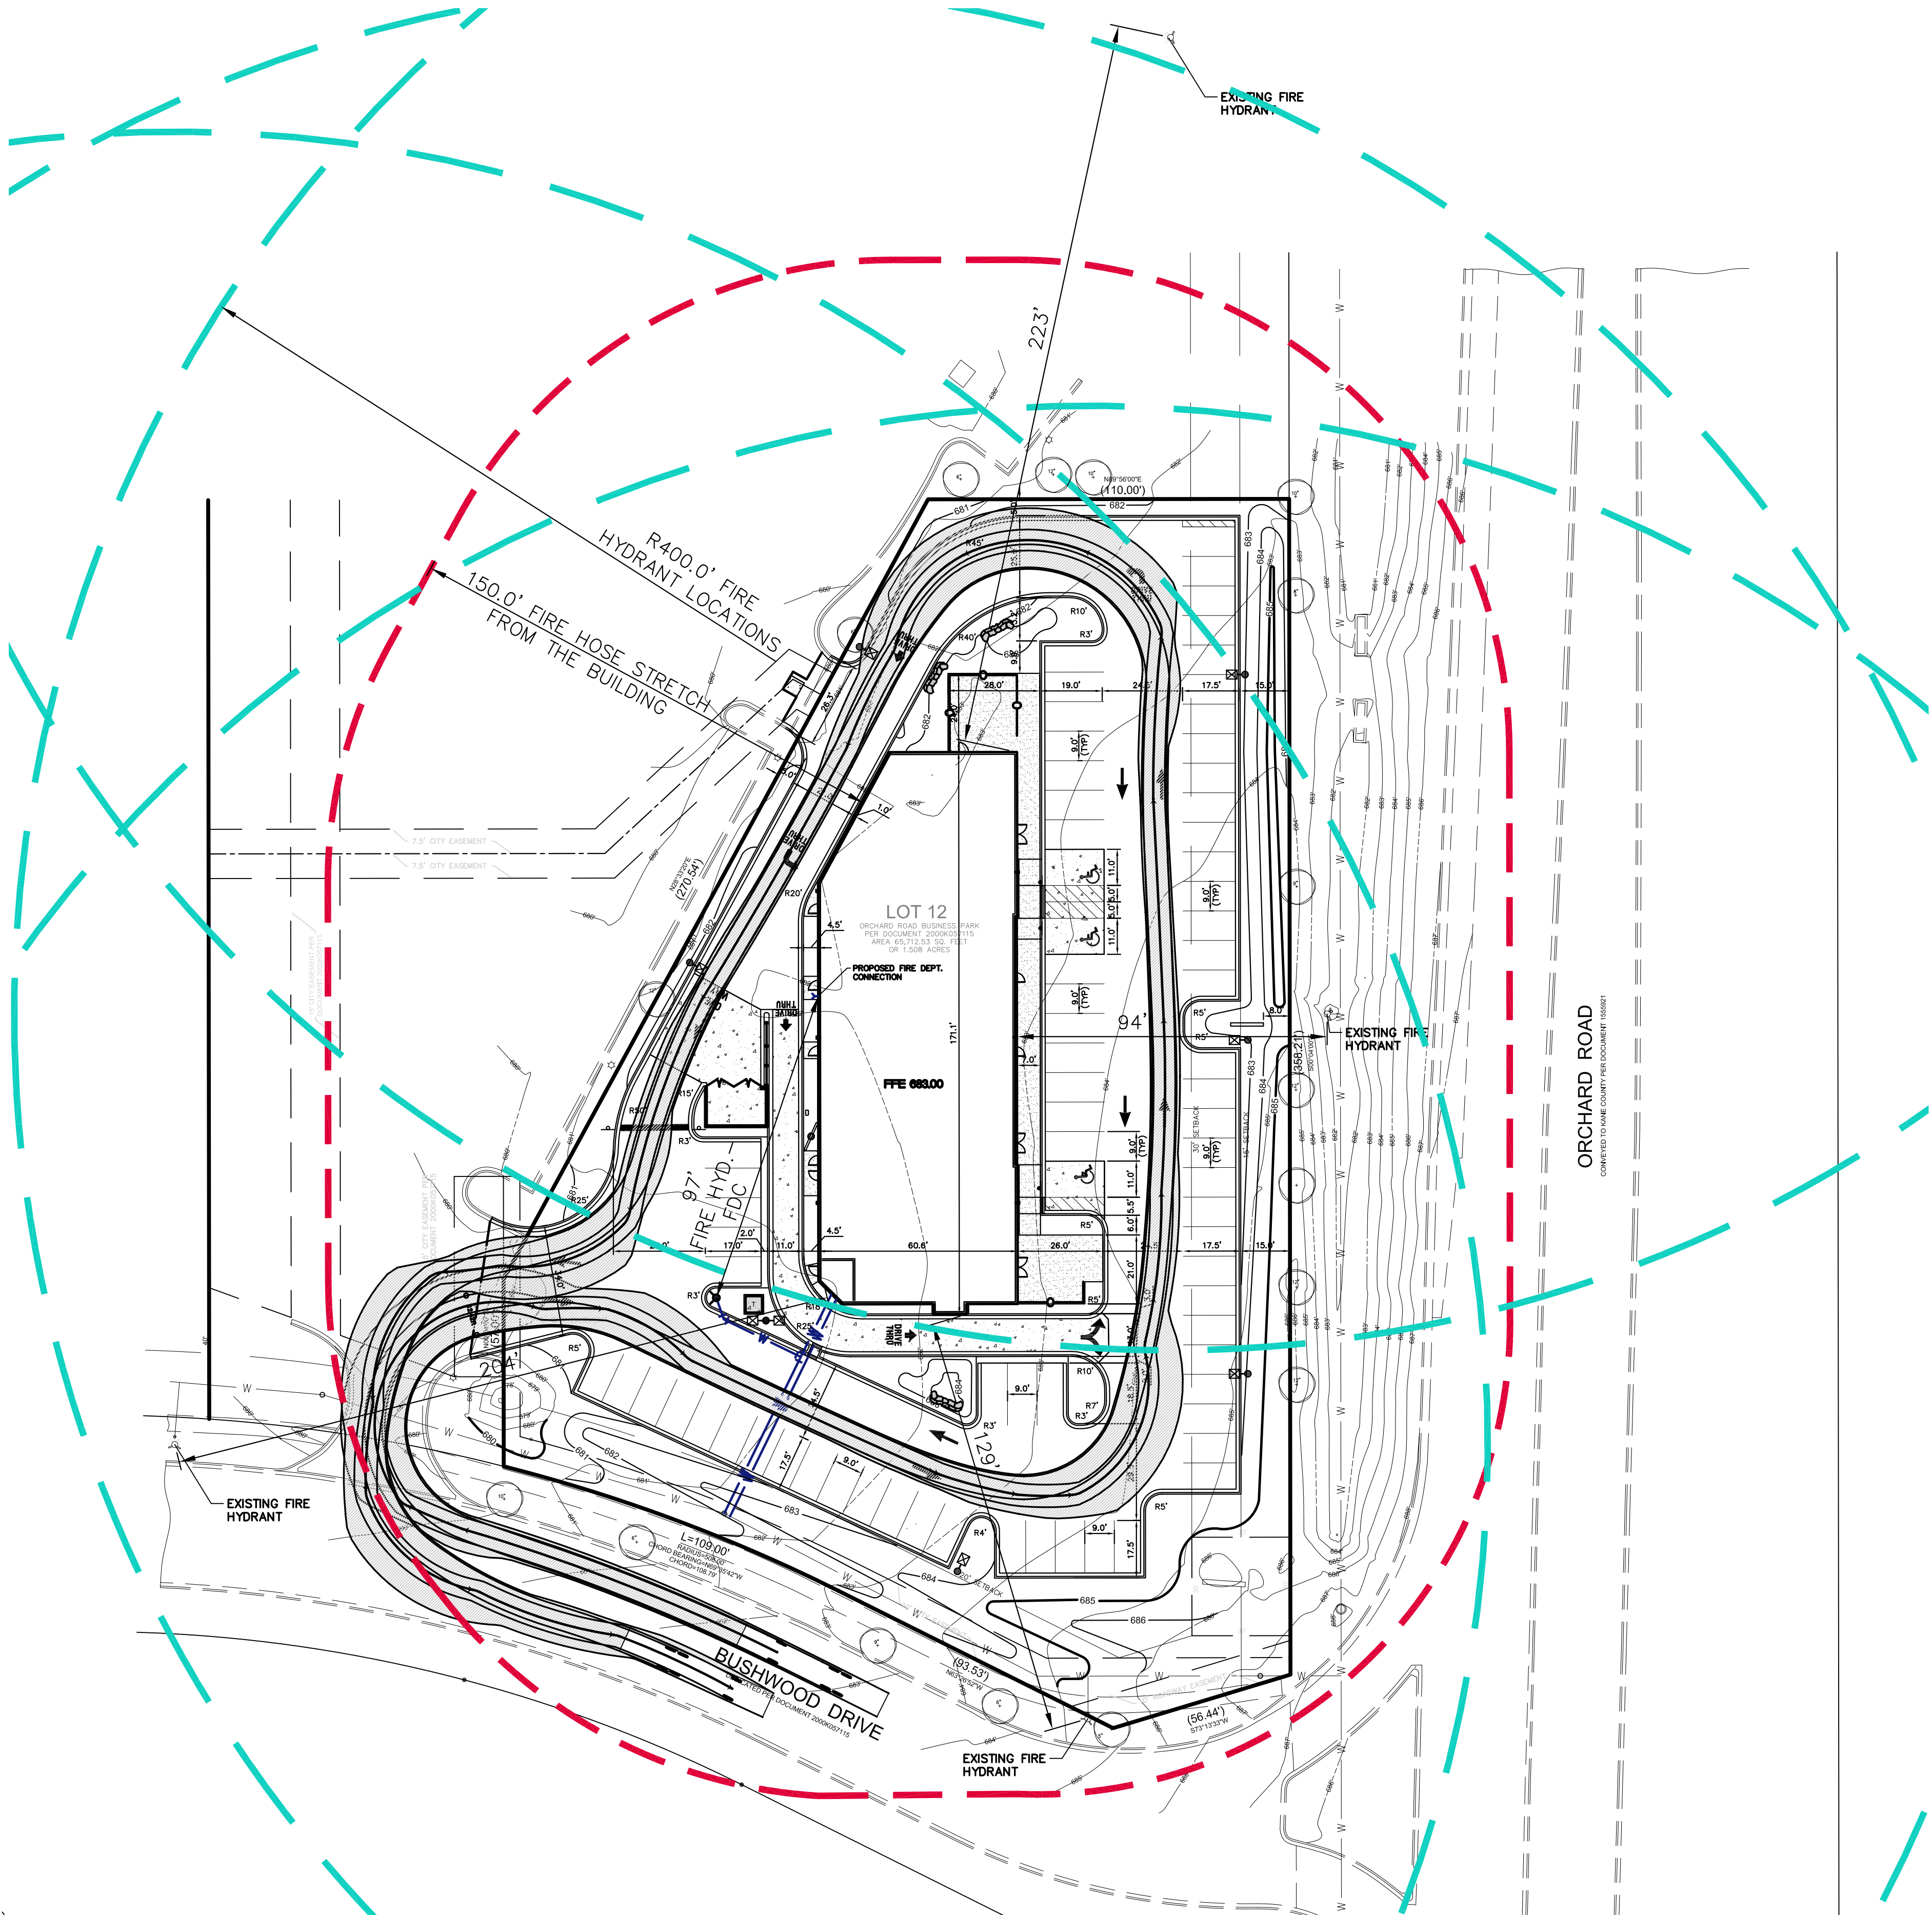

Orchard Road Business Park (Lot 12) Fire Access Plan Data Table		
Description	Value	Unit
a) Building Height	25	feet
b) Building Square Footage (typical)	9,720	square feet
c) Building fire suppression information including any proposed use of sprinkler systems, fire alarm systems, whether fire extinguishers are needed:	0.0000	
d) General description of business to be conducted within each building including: will there be rack storage in the building, will there be storage of combustible materials over twelve feet in height, clearance of sprinkler heads and stored materials (18 inch minimum):	(+/-) 10 FEET	

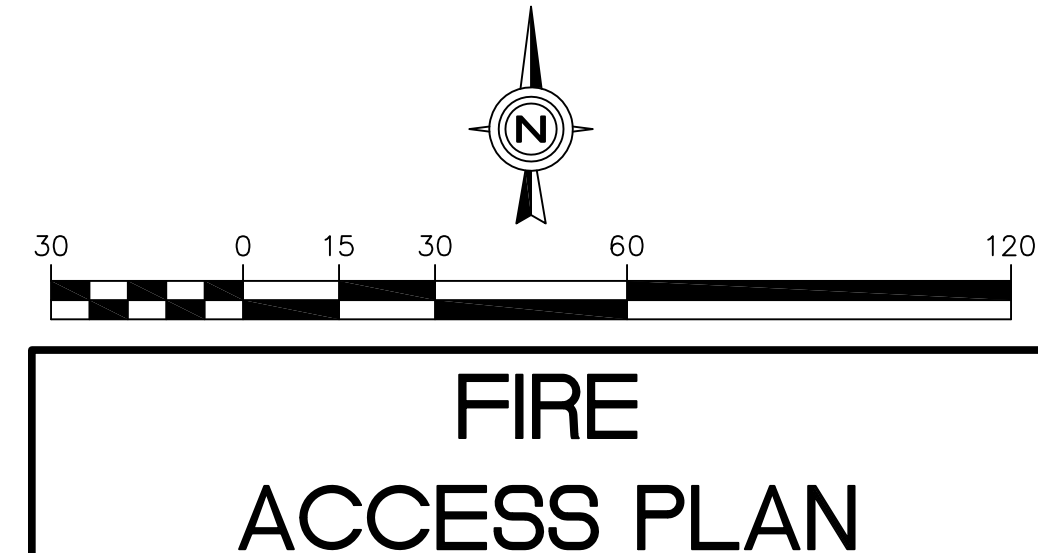

DATE	12/13/16
REVISIONS	PER C.O.A. REVIEW COMMENTS
NO.	1
NO.	2
Prepared For:	VEQUITY 400 N. State St., Suite 400 Chicago, IL 60654 STU'S LANDING - AURORA 2413 Bushwood Dr. Aurora, Illinois
Prepared By:	Watermark Engineering Resources, Ltd. O 2631 Ginger Woods Parkway, Suite 100, Aurora, IL 60502 phone 630-375-1800 fax 630-238-9800 www.watermark-engineering.com
CHECKED BY: B. PERRY	DESIGN BY: K. PRICE
DRAWN BY: K. PRICE	DATE: DECEMBER 5, 2016
SCALE: 1" = 30'	PROJECT NO.: 16-301
2-6	FIRE ACCESS PLAN