

Bid 23-62
White Eagle Force Main Improvements
Bid opening: July 12, 2023

ADDENDUM NO. 1
Page 1 of 4

TO: All Bidders

FROM: Engineering Division, City of Aurora

DATE: July 10, 2023

THIS ADDENDUM FORMS A PART OF THE BIDDING AND CONTRACT DOCUMENTS.

1. The two structure plan callout inverts on sheet 4 of 9 were corrected to reflect the profile view. Contour labels were added to the 3 plan and profile sheets. Please see the attached revised plan sheets 4 through 6 dated 7/10/2023.

Sincerely,





John D. Hoffmann, P.E.
Engineering Coordinator
City of Aurora Engineering Division

PLEASE ACKNOWLEDGE RECEIPT OF THIS ADDENDUM BY FILLING OUT THE FOLLOWING AND SENDING AN ORIGINAL OR FAX COPY OF THIS SHEET TO THE CITY OF AURORA ENGINEERING DIVISION AT 630/256-3229 OR PREFERRABLY BY E-MAIL AT hoffmannj@aurora.il.us IMMEDIATELY UPON RECIEPT.

COMPANY NAME _____

SIGNATURE OF COMPANY REPRESENTATIVE _____

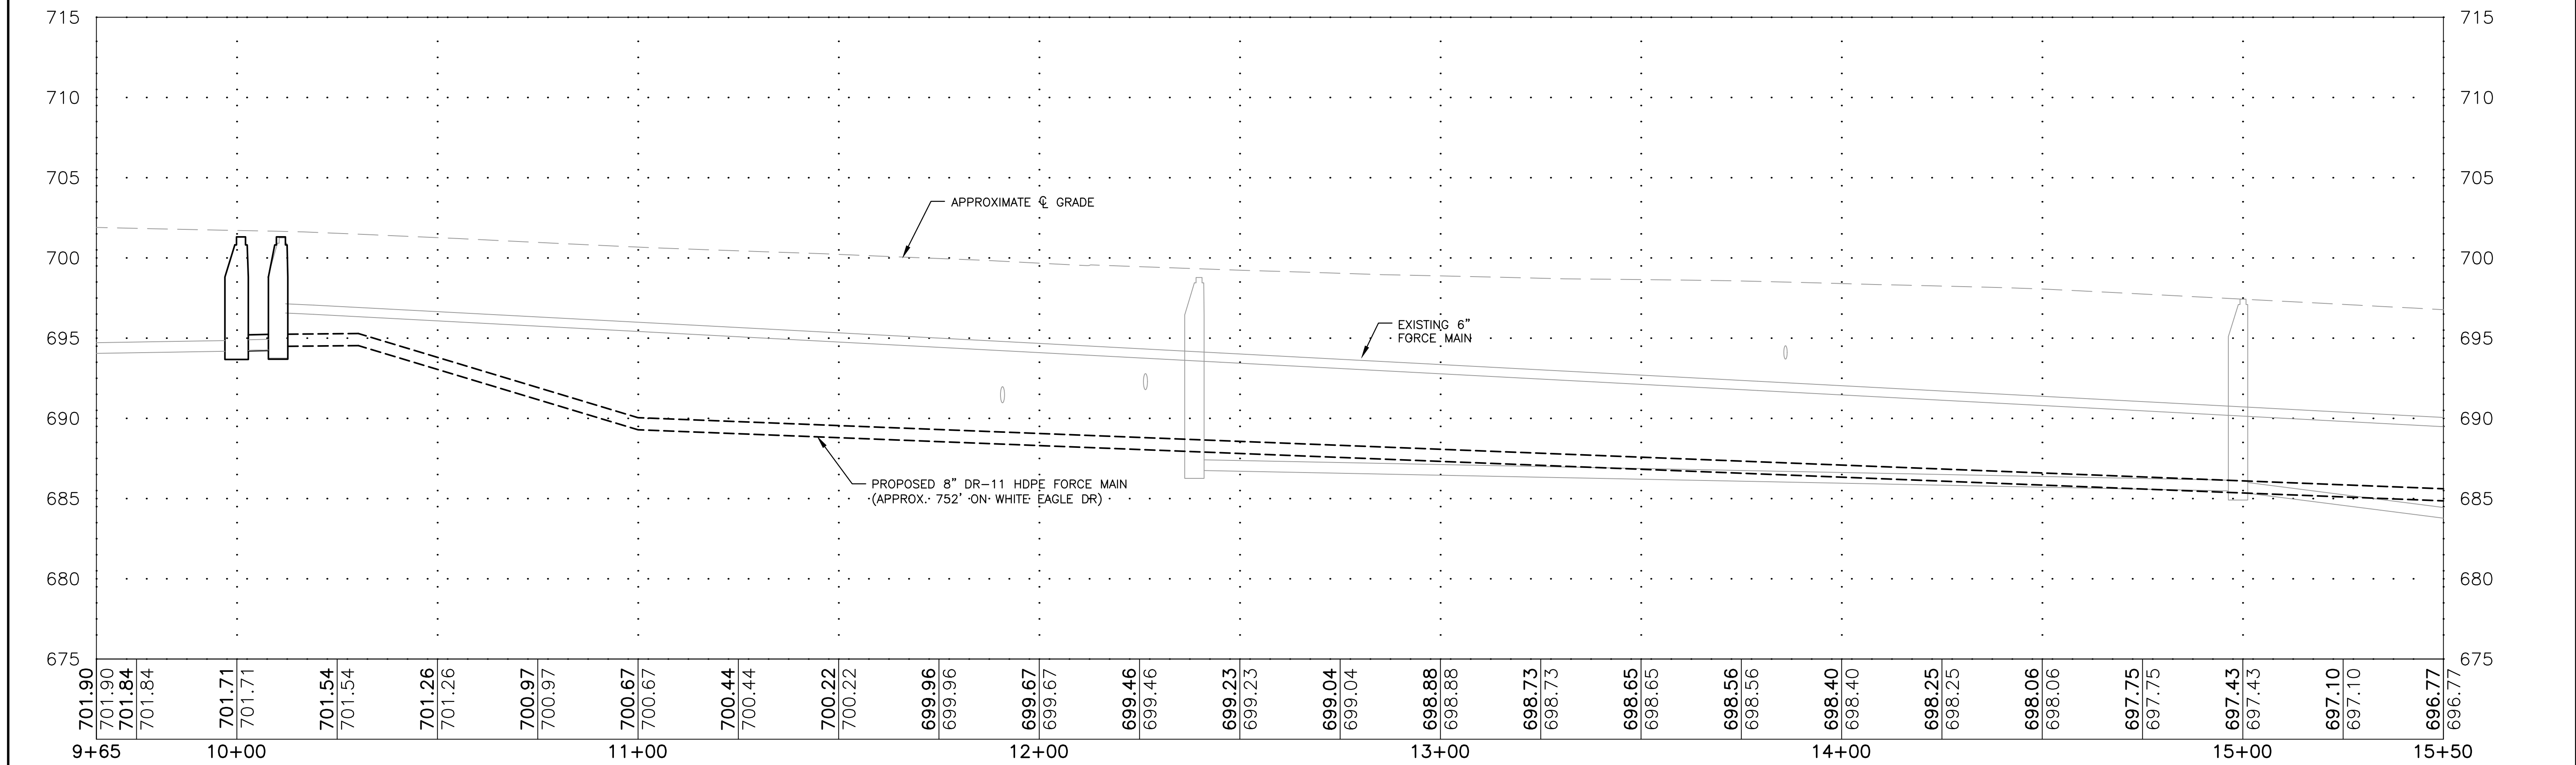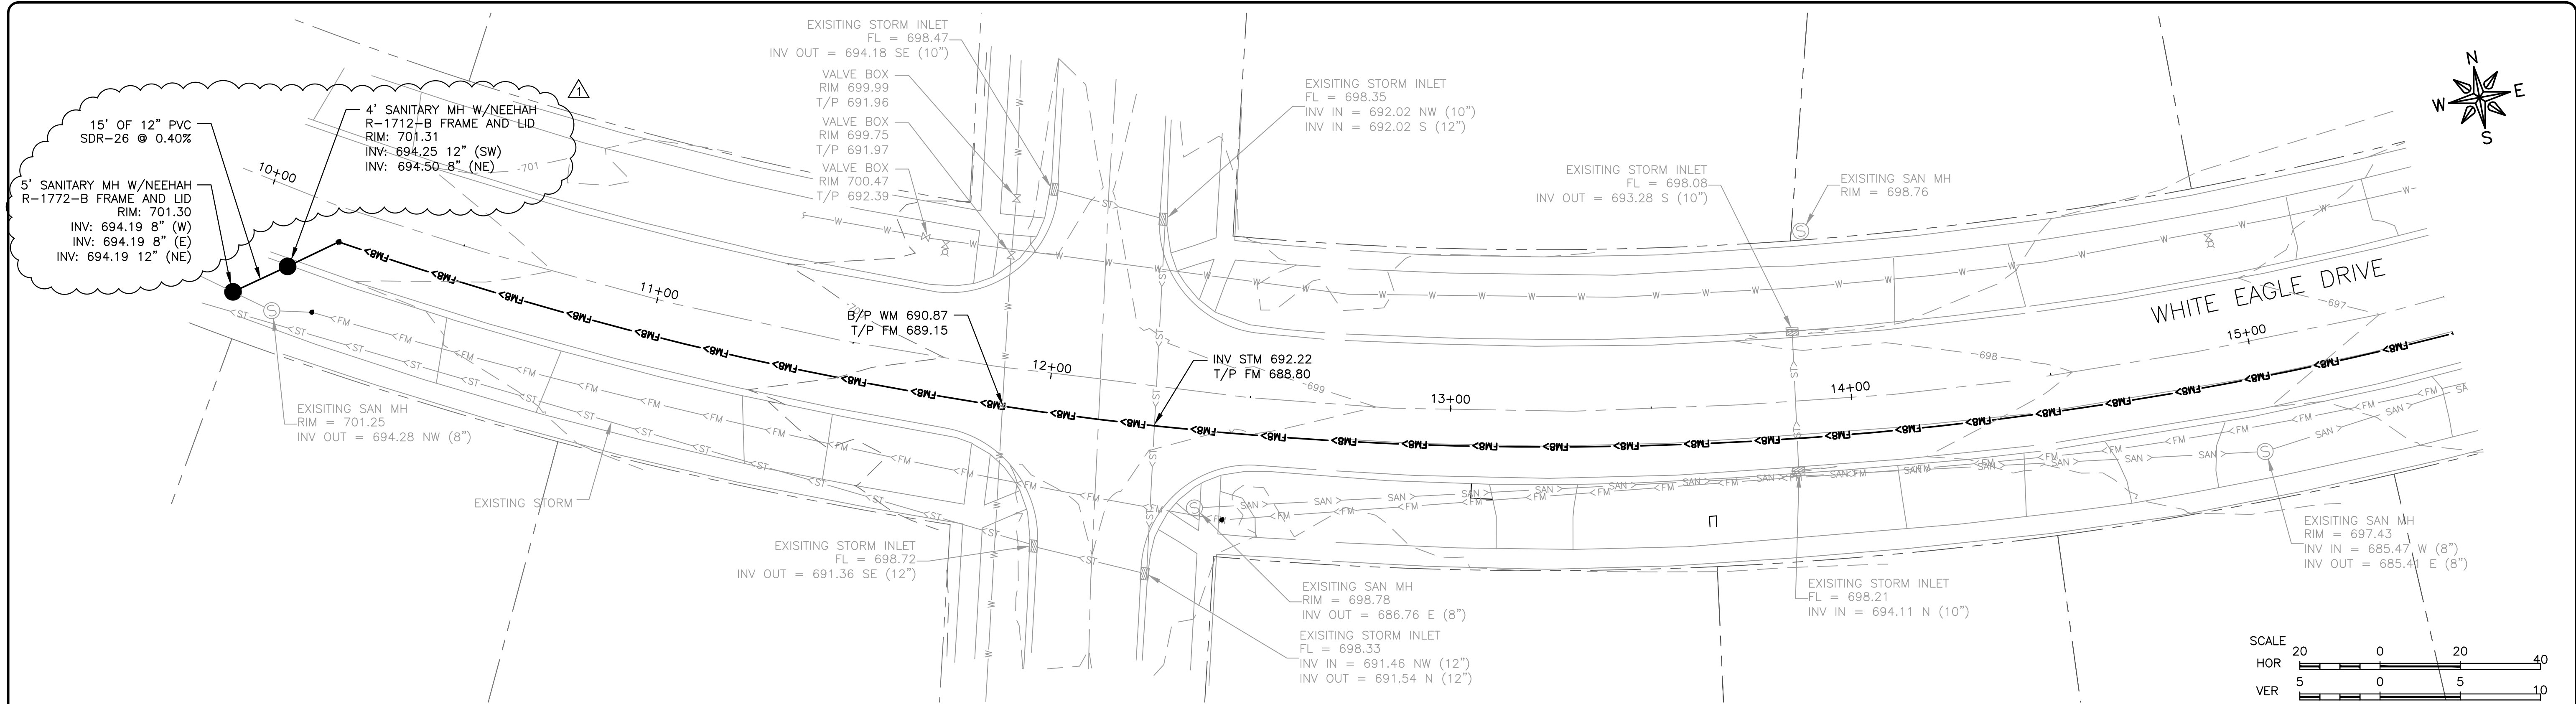

FEHR GRAHAM
ENGINEERING & ENVIRONMENTAL
ILLINOIS DESIGN FIRM NO. 184-003525

ILLINOIS
IOWA
WISCONSIN

OWNER/DEVELOPER:
CITY OF AURORA
44 E. DOWNER PLACE
AURORA, ILLINOIS

PROJECT AND LOCATION:
WHITE EAGLE FORCEMAIN
AURORA, ILLINOIS

DRAWN BY: AS/MV
APPROVED BY: ARD
DATE: 3-10-2023
SCALE: AS NOTED

REVISIONS		
REV. NO.	DESCRIPTION	DATE
1	ADDENDUM 1	7/10/2023

DRAWING:
PLAN AND PROFILE

SET TYPE: BID SET





G:\C30\22-694\Plans\White Eagle FM\22-694-Palmer Pipe Network 08.dwg, 4 PLAN AND PROFILE

JOB NUMBER:
22-694

SHEET NUMBER:
4 of 9

PLOT DATE: 7/10/23

© 2023 FEHR GRAHAM

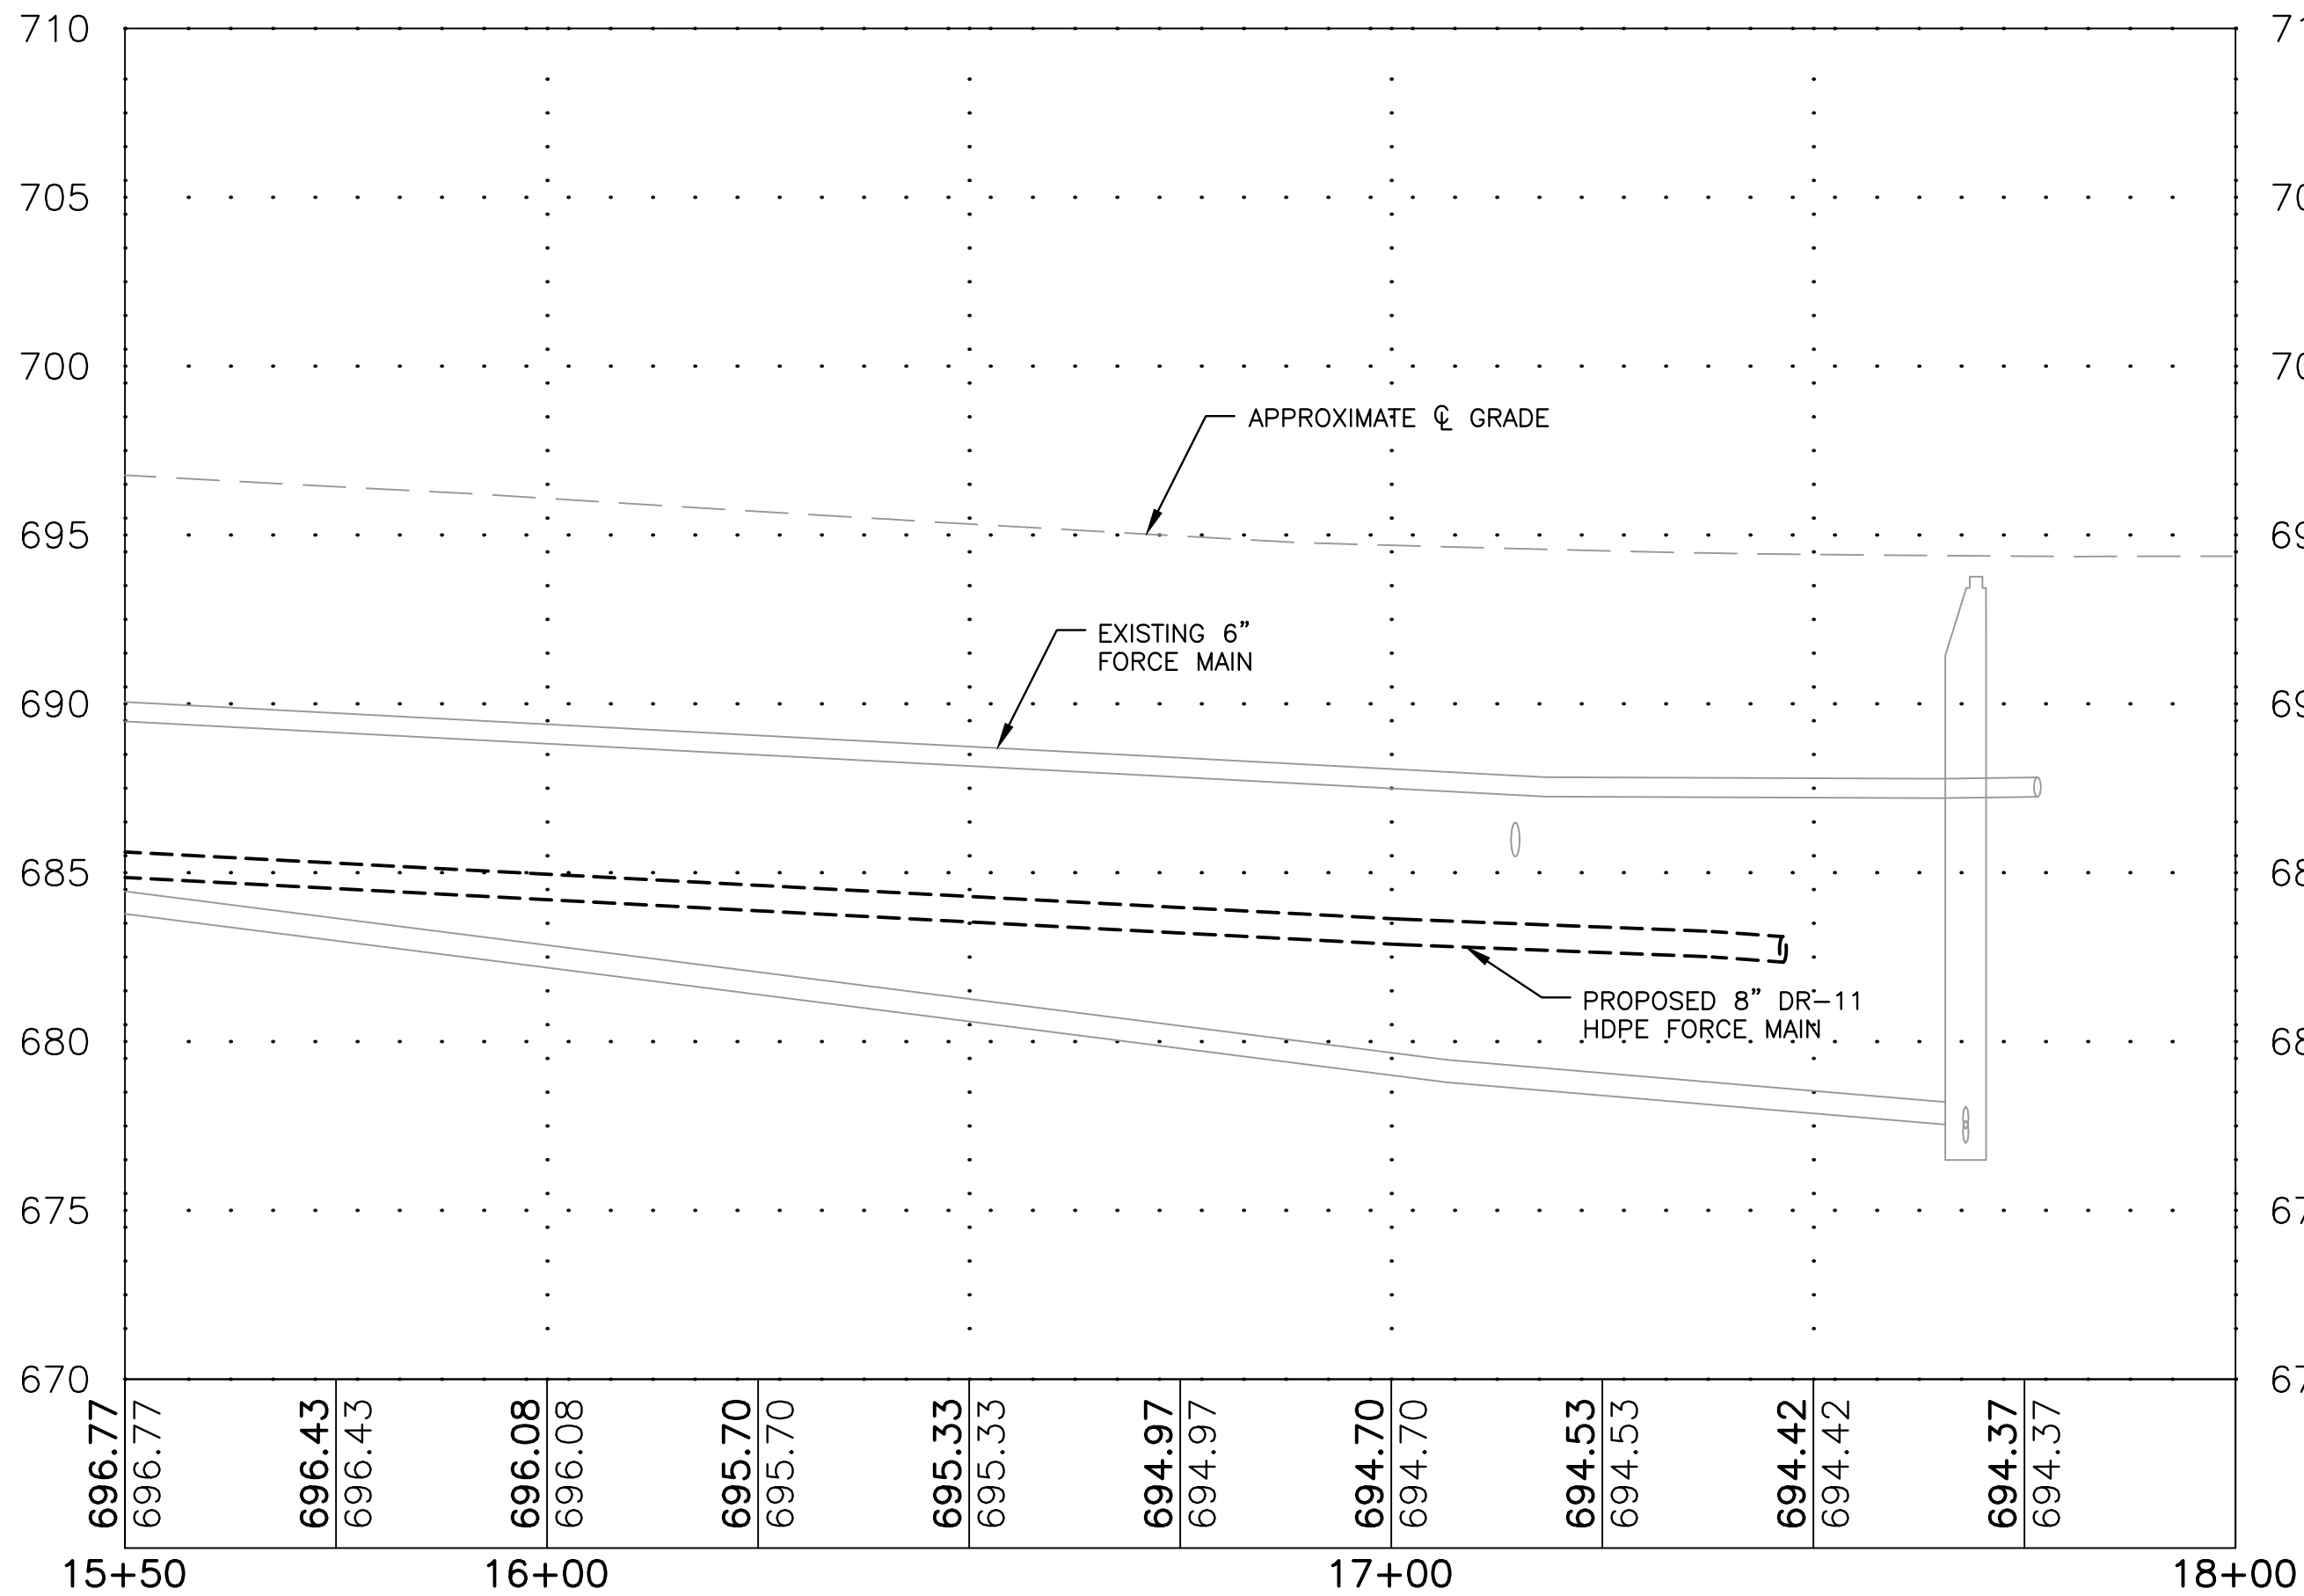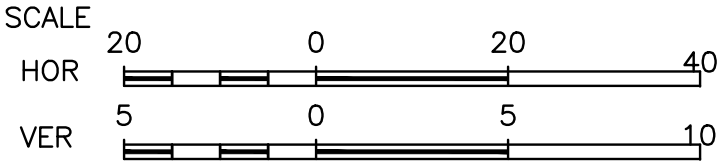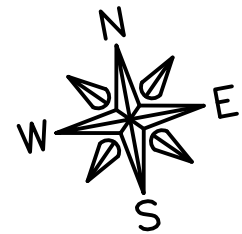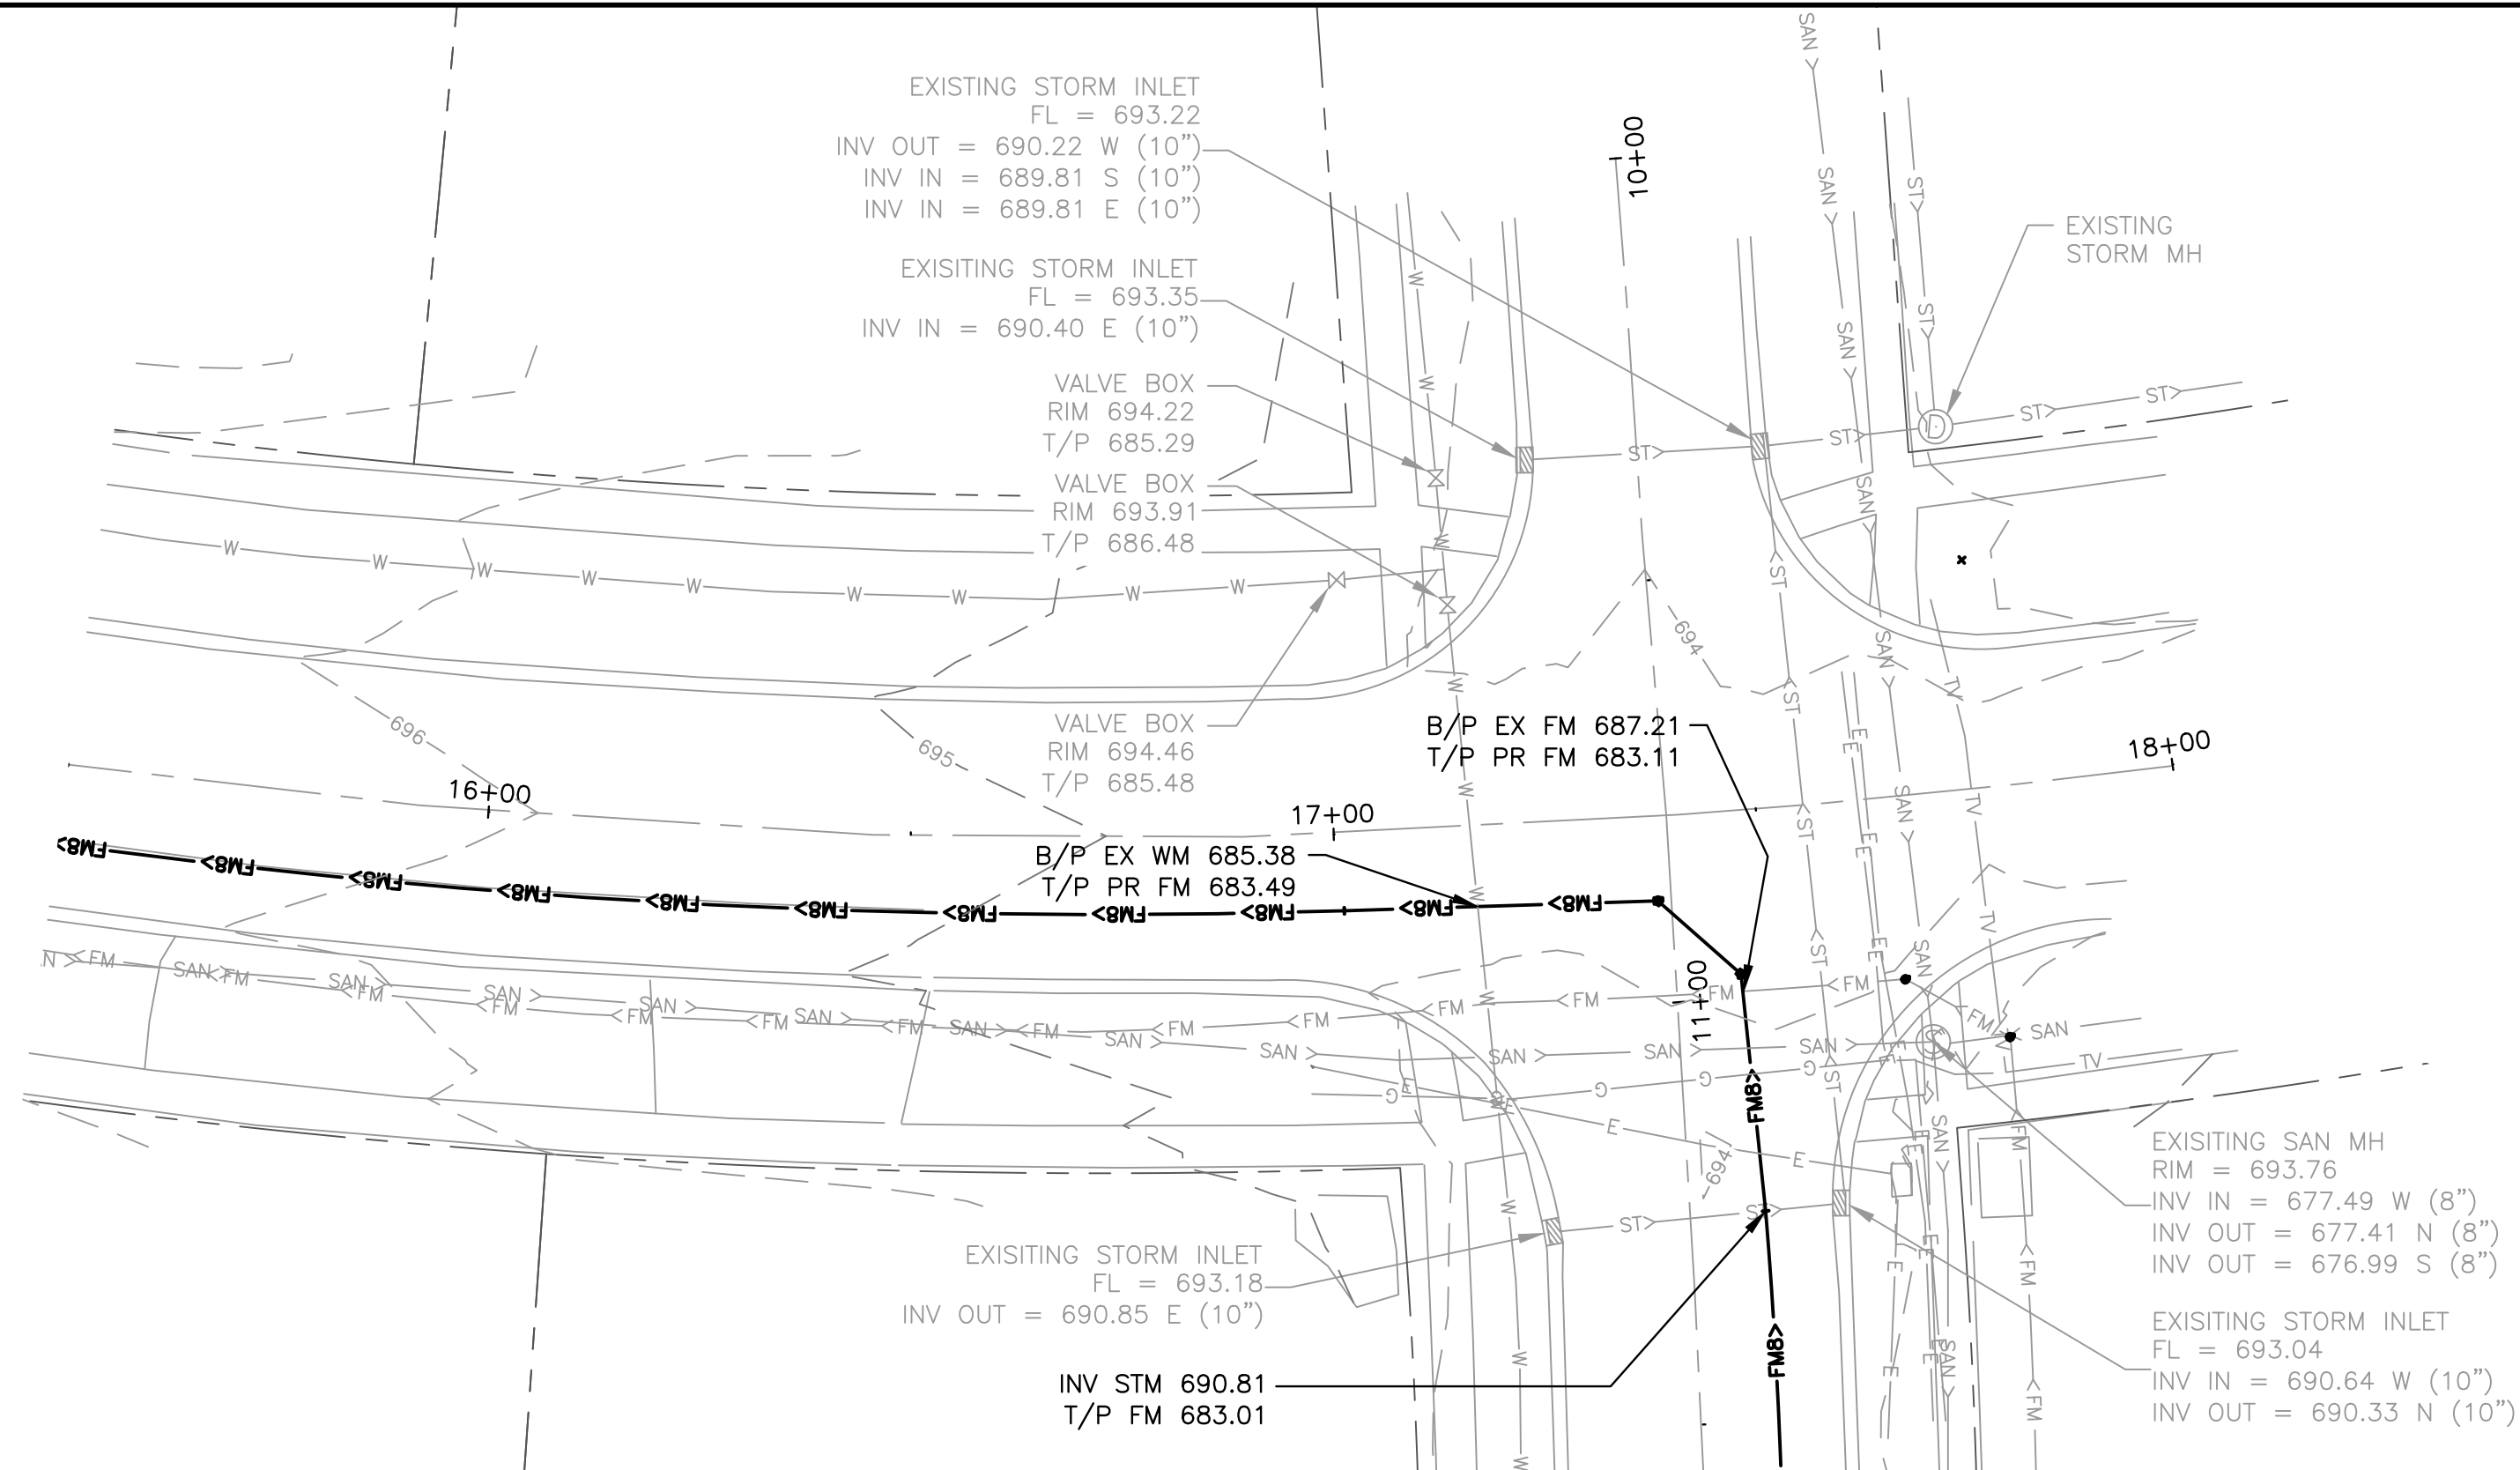

FEHR GRAHAM

ENGINEERING & ENVIRONMENTAL

ILLINOIS DESIGN FIRM NO. 184-003525

ILLINOIS
IOWA
WISCONSIN

OWNER/DEVELOPER:
CITY OF AURORA
44 E. DOWNER PLACE
AURORA, ILLINOIS

PROJECT AND LOCATION:
WHITE EAGLE FORCEMAIN
AURORA, ILLINOIS

DRAWN BY: AS/MV
APPROVED BY: ARD
DATE: 3-10-2023
SCALE: AS NOTED

REVISIONS		
REV. NO.	DESCRIPTION	DATE



DRAWING:
PLAN AND PROFILE

SET TYPE: BID SET

G:\C30\22\22-694\Plans\White Eagle FM\22-694-Palmer Pipe Network 08.dwg, 5 PLAN AND PROFILE

JOB NUMBER:
22-694

SHEET NUMBER:
5 of 9

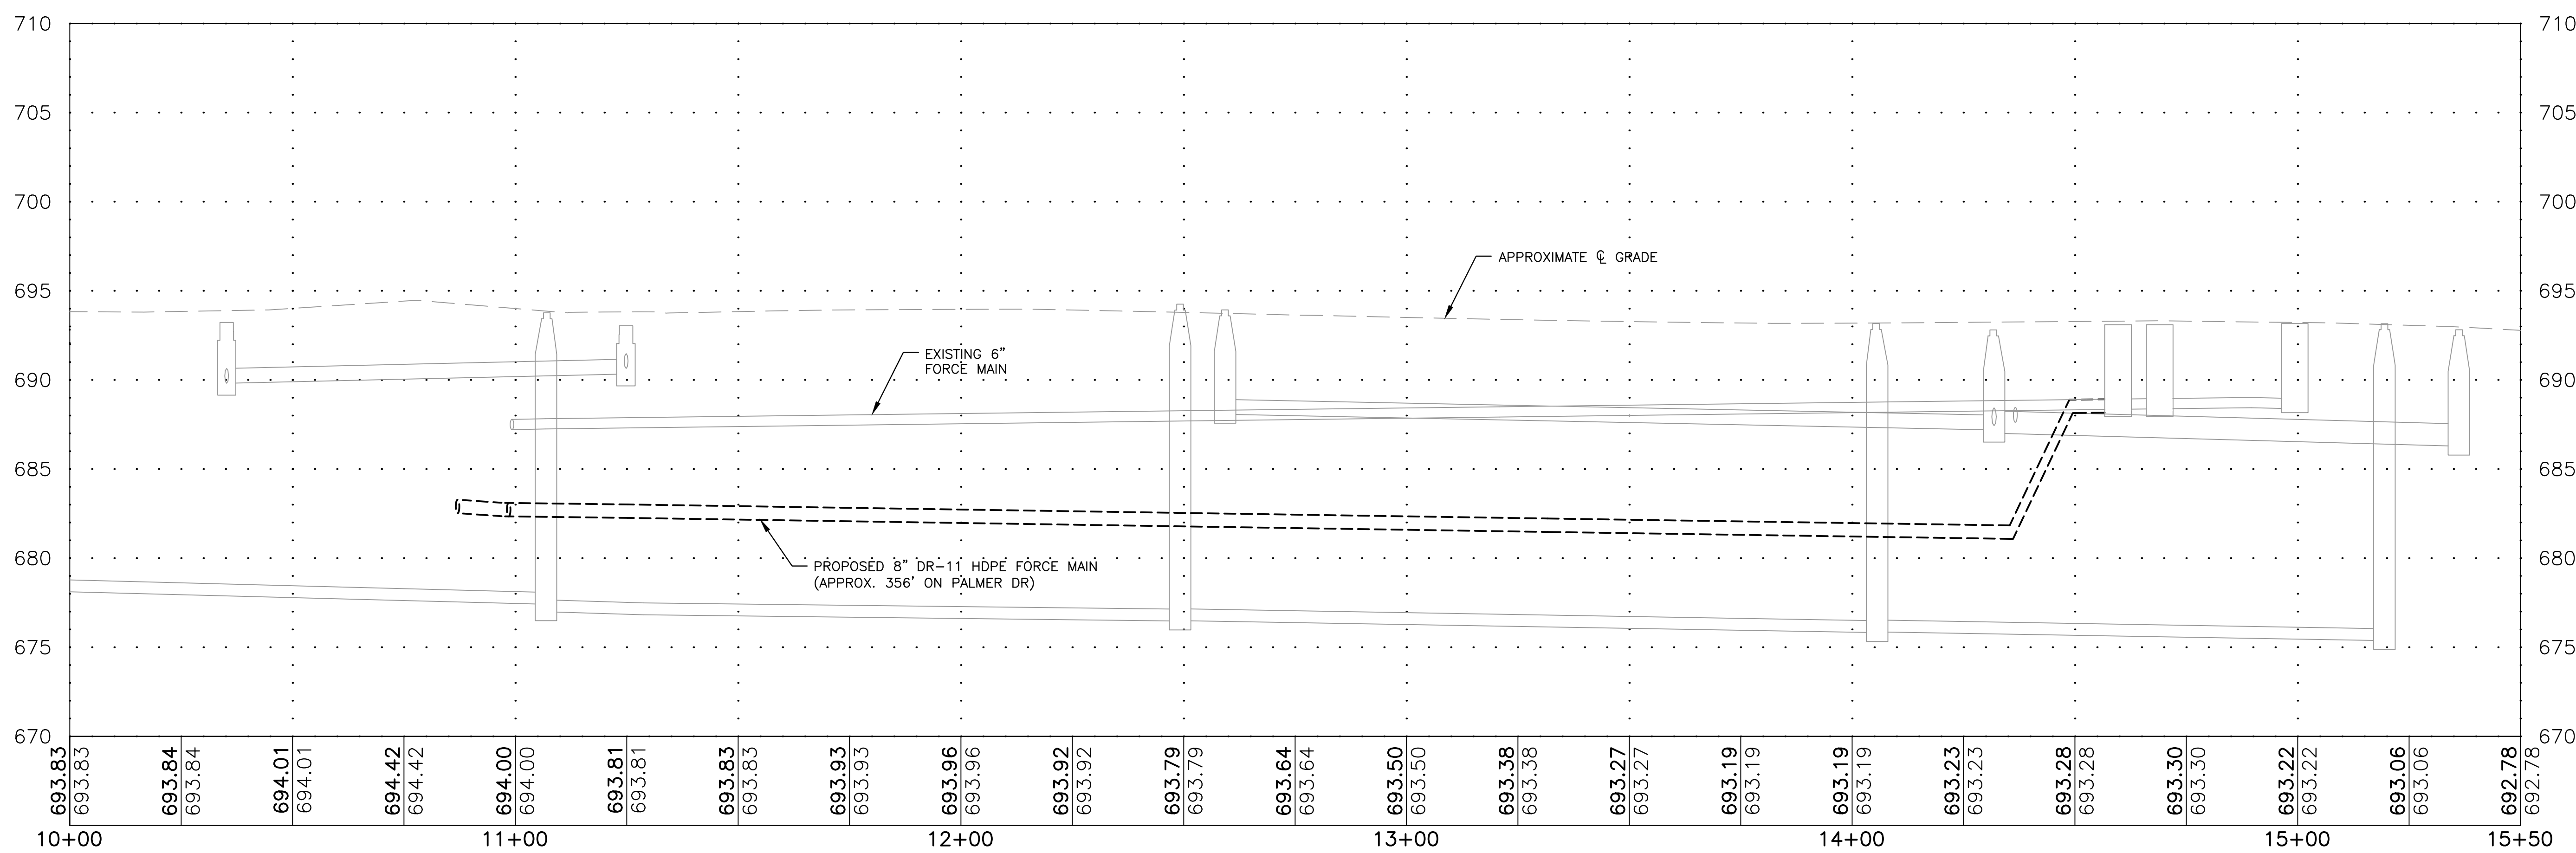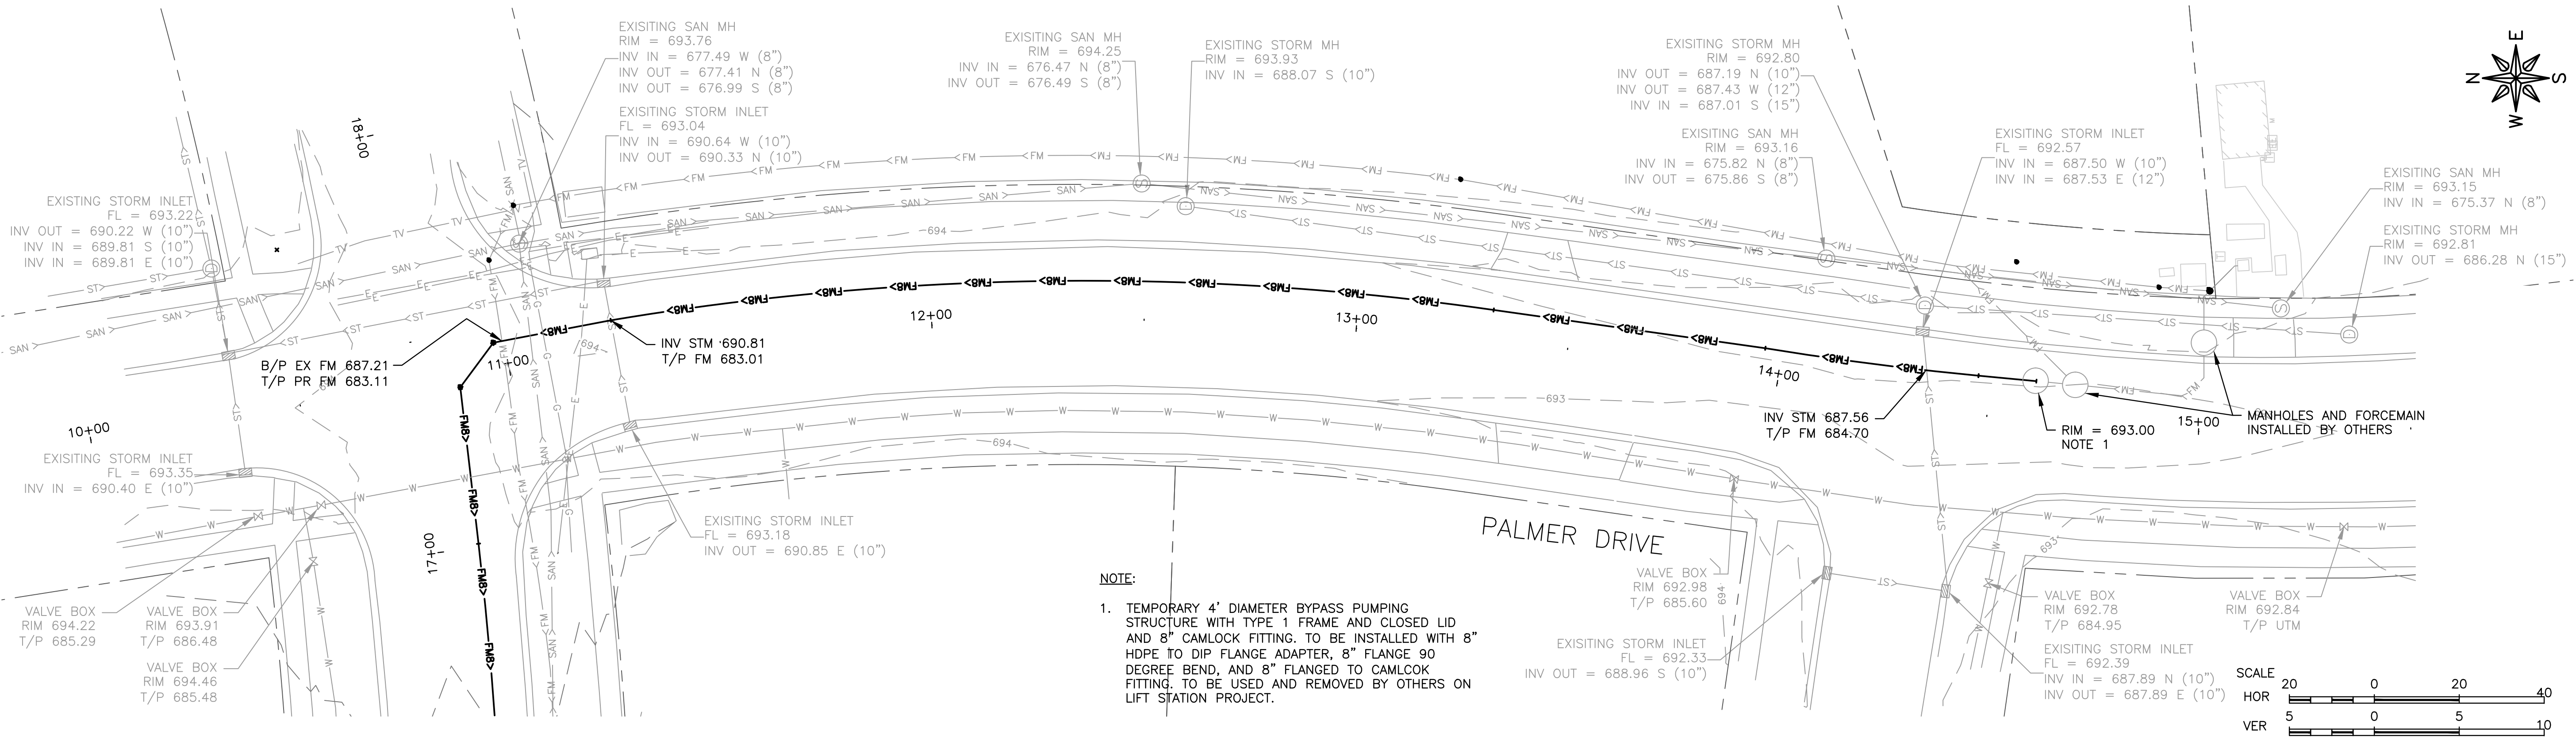

FEHR GRAHAM

ENGINEERING & ENVIRONMENTAL

ILLINOIS DESIGN FIRM NO. 184-003525

ILLINOIS
IOWA
WISCONSIN

OWNER/DEVELOPER:

CITY OF AURORA
44 E. DOWNER PLACE
AURORA, ILLINOIS

PROJECT AND LOCATION:

WHITE EAGLE FORCEMAIN
AURORA, ILLINOIS

DRAWN BY: AS/MV

APPROVED BY: ARD

DATE: 3-10-2023

SCALE: AS NOTED

REVISIONS

REV. NO.	DESCRIPTION	DATE

DRAWING:

PLAN AND PROFILE

SET TYPE: BID SET

G:\C30\22\22-694\Plans\White Eagle FM\22-694-Palmer Pipe Network 08.dwg, 6 PLAN AND PROFILE

JOB NUMBER:

22-694

SHEET NUMBER:

6 of 9