



**SOUTH ELEVATION**

SCALE: 1/8" = 1'-0"

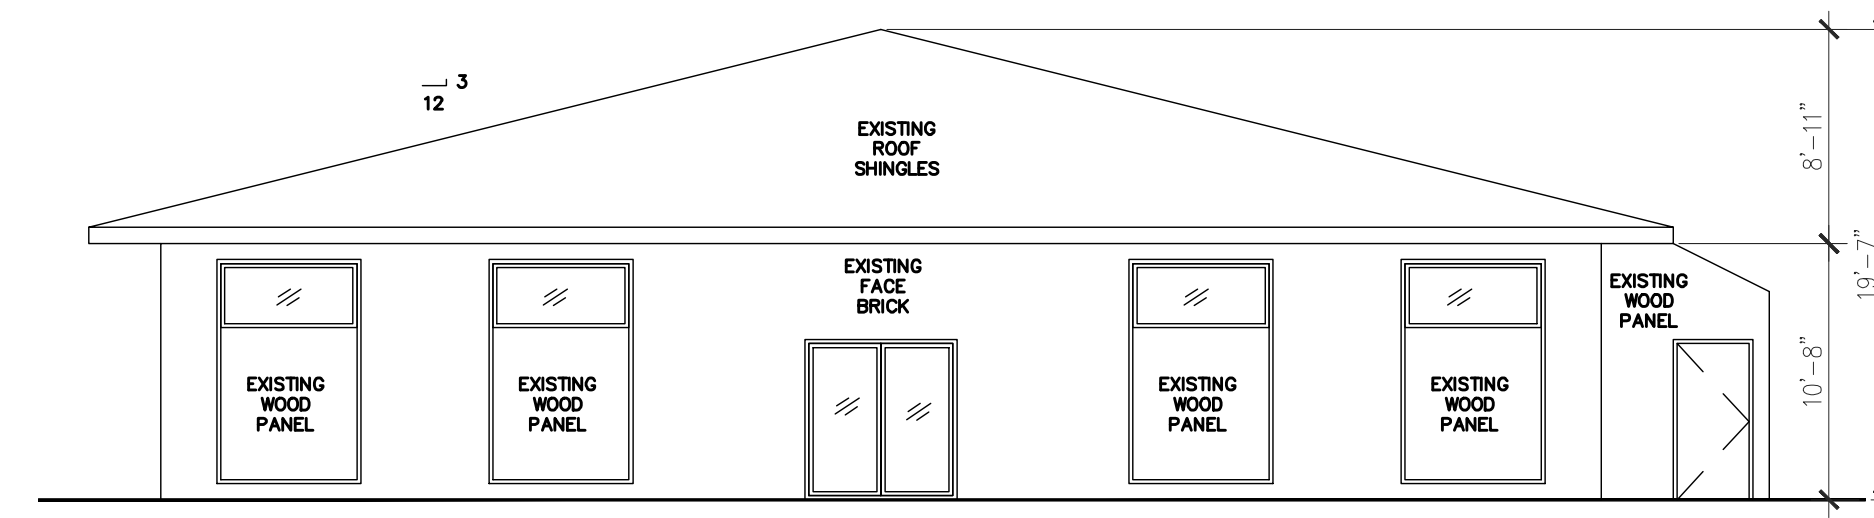


**EAST ELEVATION**

SCALE: 1/8" = 1'-0"

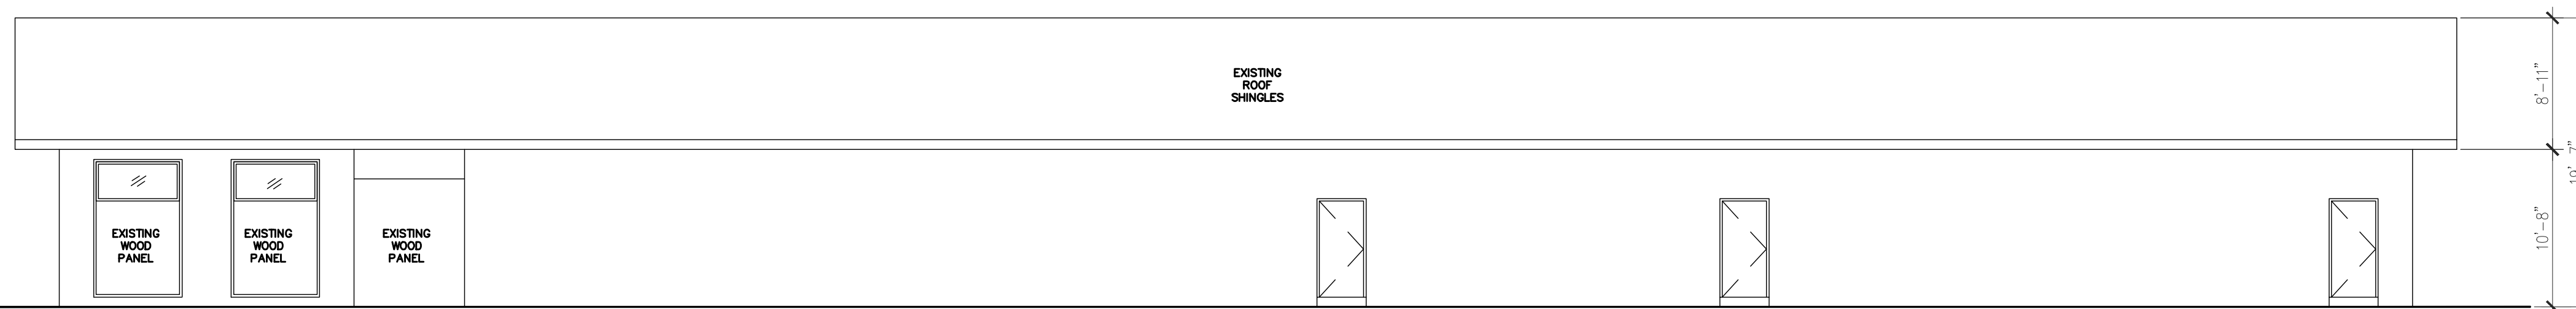

**NORTH ELEVATION**


SCALE: 1/8" = 1'-0"

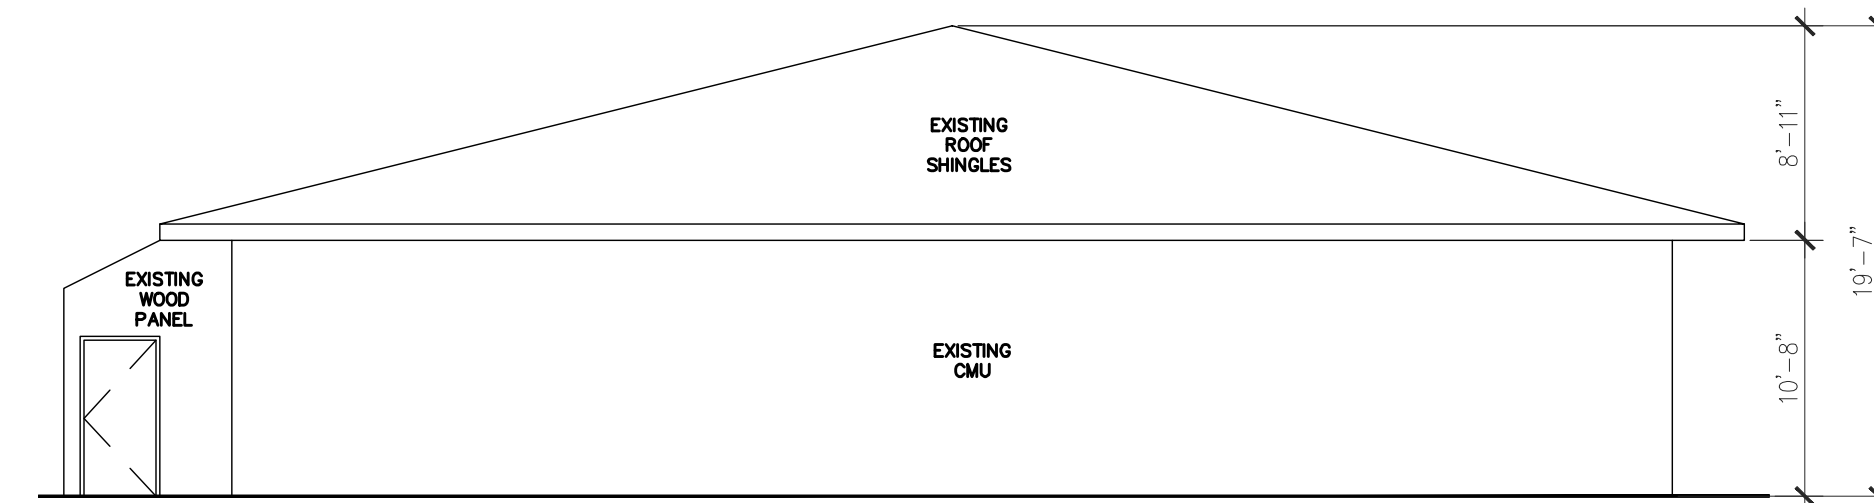


**WEST ELEVATION**

SCALE: 1/8" = 1'-0"


JOB NUMBER	14102
DATE	1.20.14
REVISIONS	
△	
△	
△	
△	
△	
△	
SHEET	

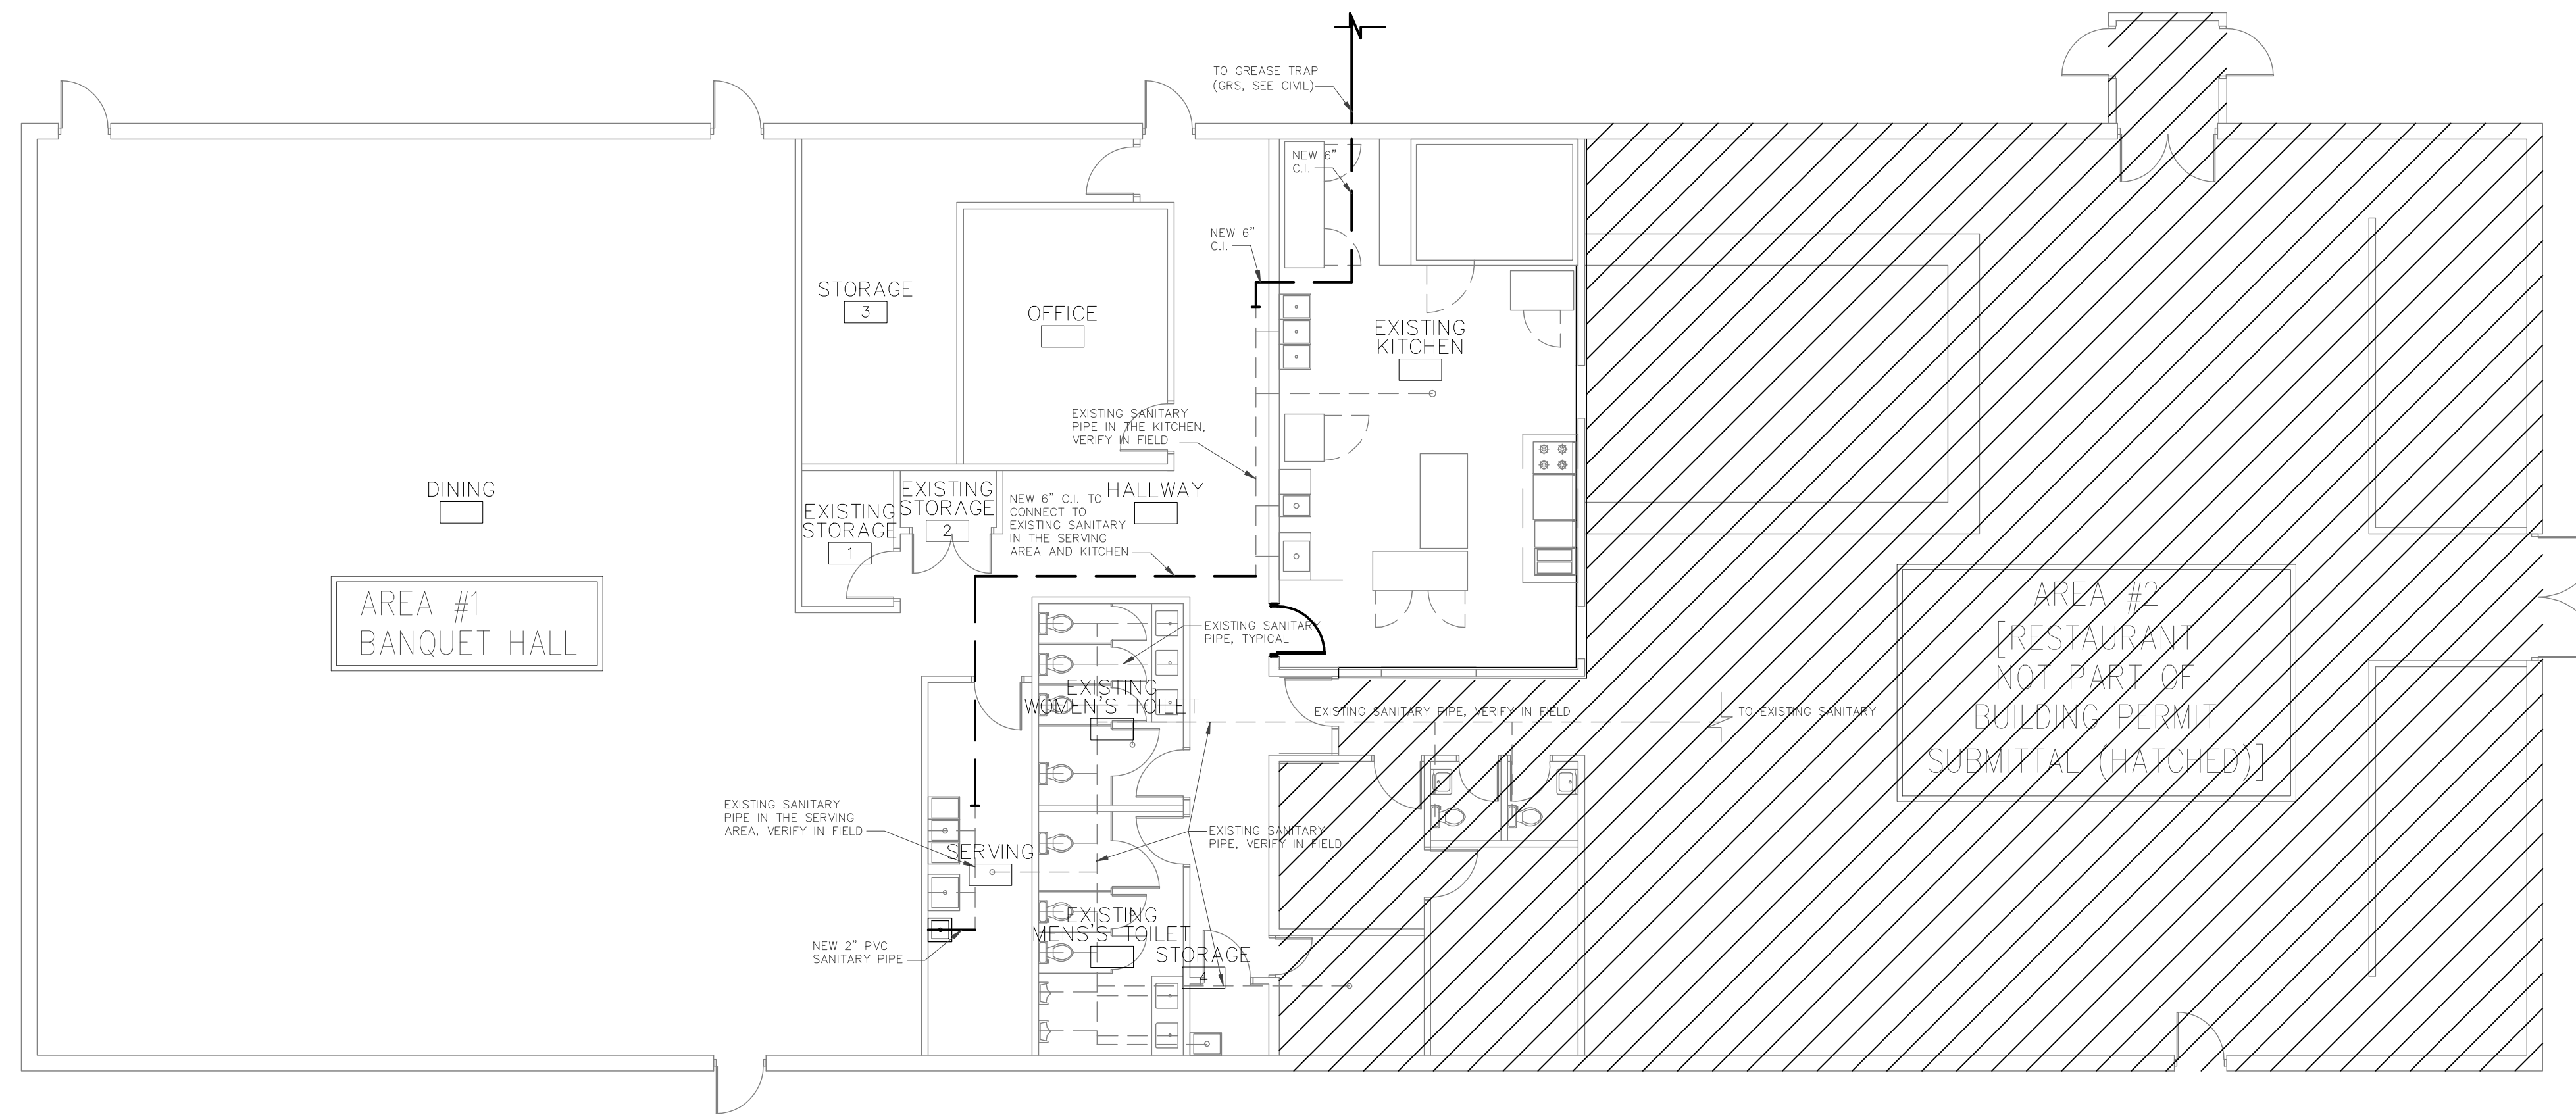


PLUMBING PLAN  
SCALE: 1/8" = 1'-0"

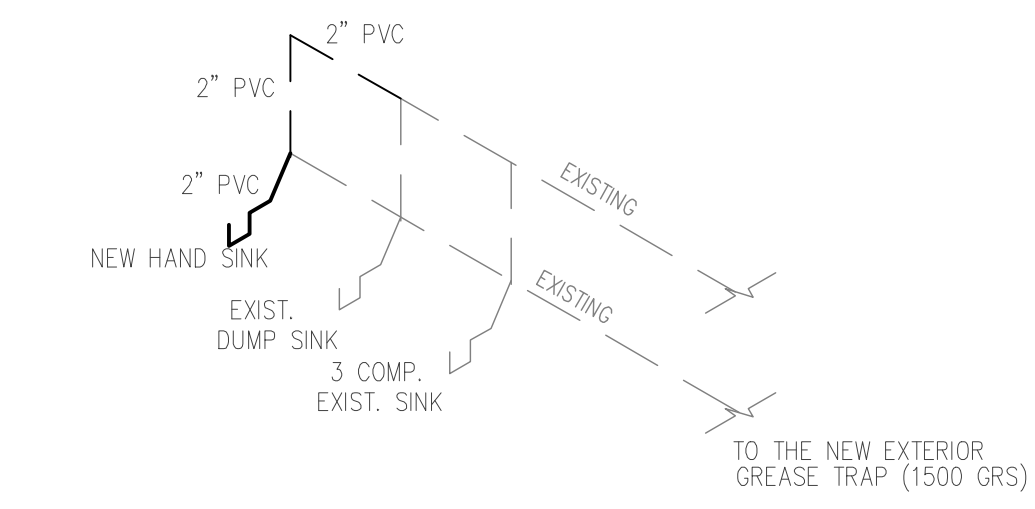


WASTE & VENT DIAGRAM  
SCALE: N.T.S.

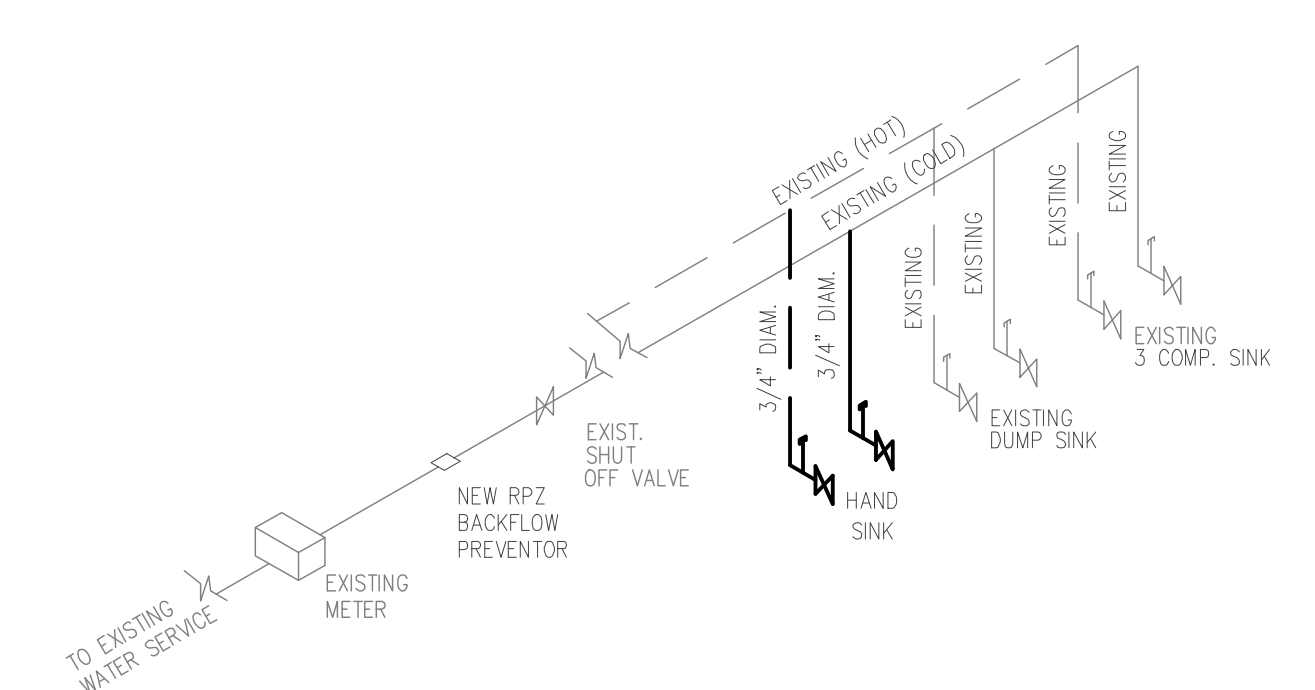

DOMESTIC WATER  
SCALE: N.T.S.

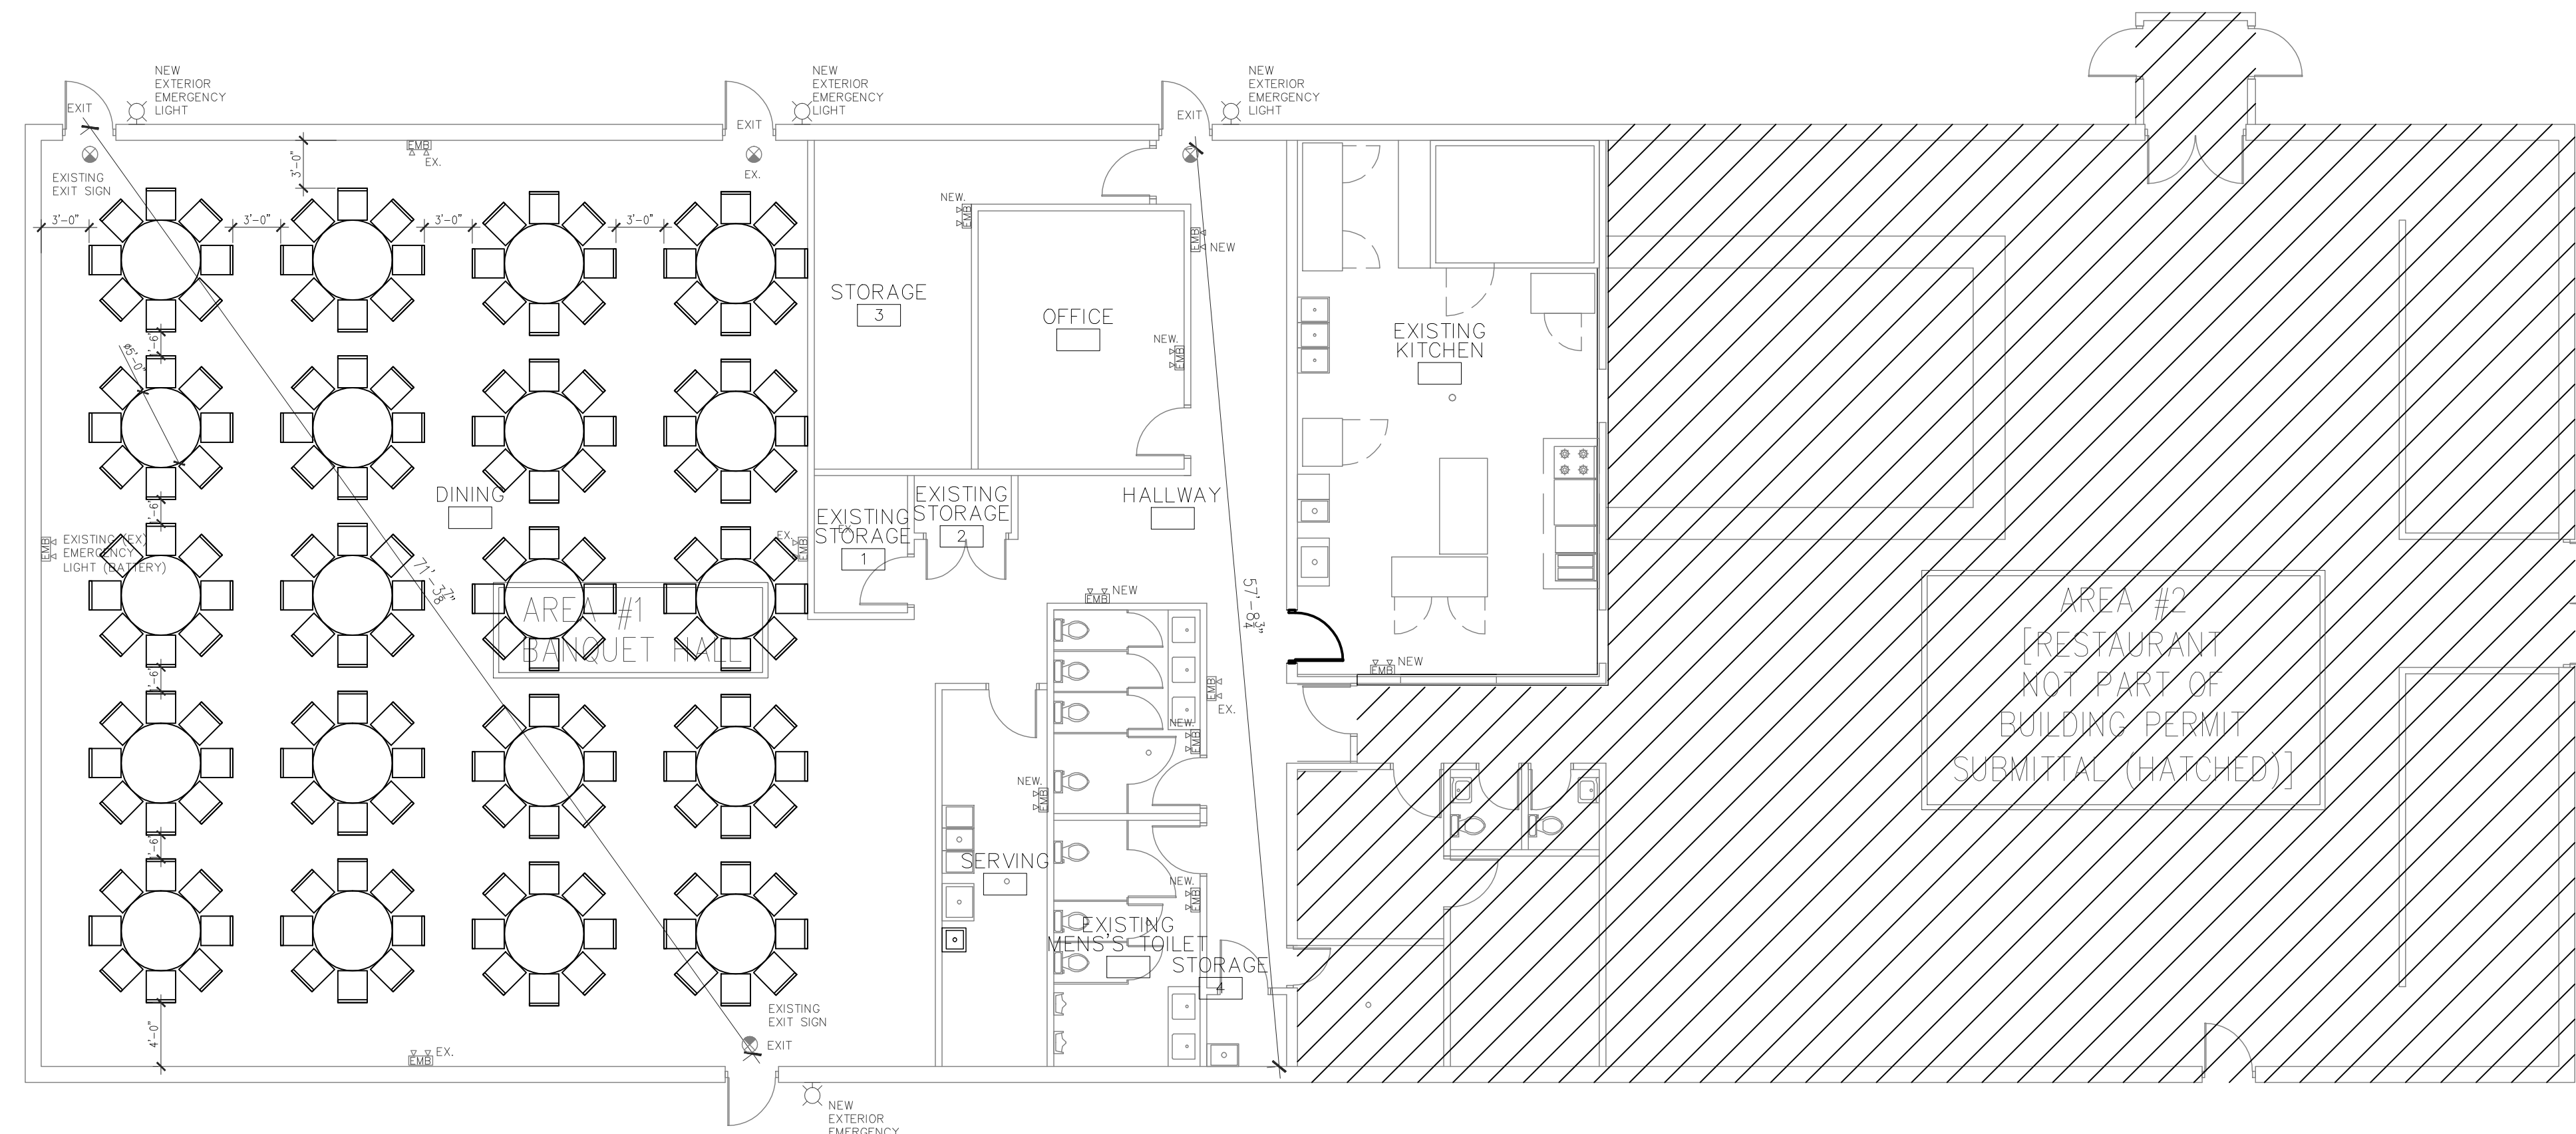

EGRESS, EMERGENCY LIGHTING PLAN, AND SEATING PLAN  
SCALE: 1/8" = 1'-0"

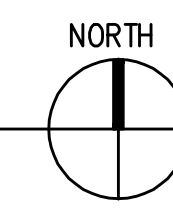

NEW FIXTURE COUNT		
	QUANTITY	LOCATION
HAND SINK	1	SERVING