



FIRE PLAN - WATERFORD PLAZA RESUBDIVISION

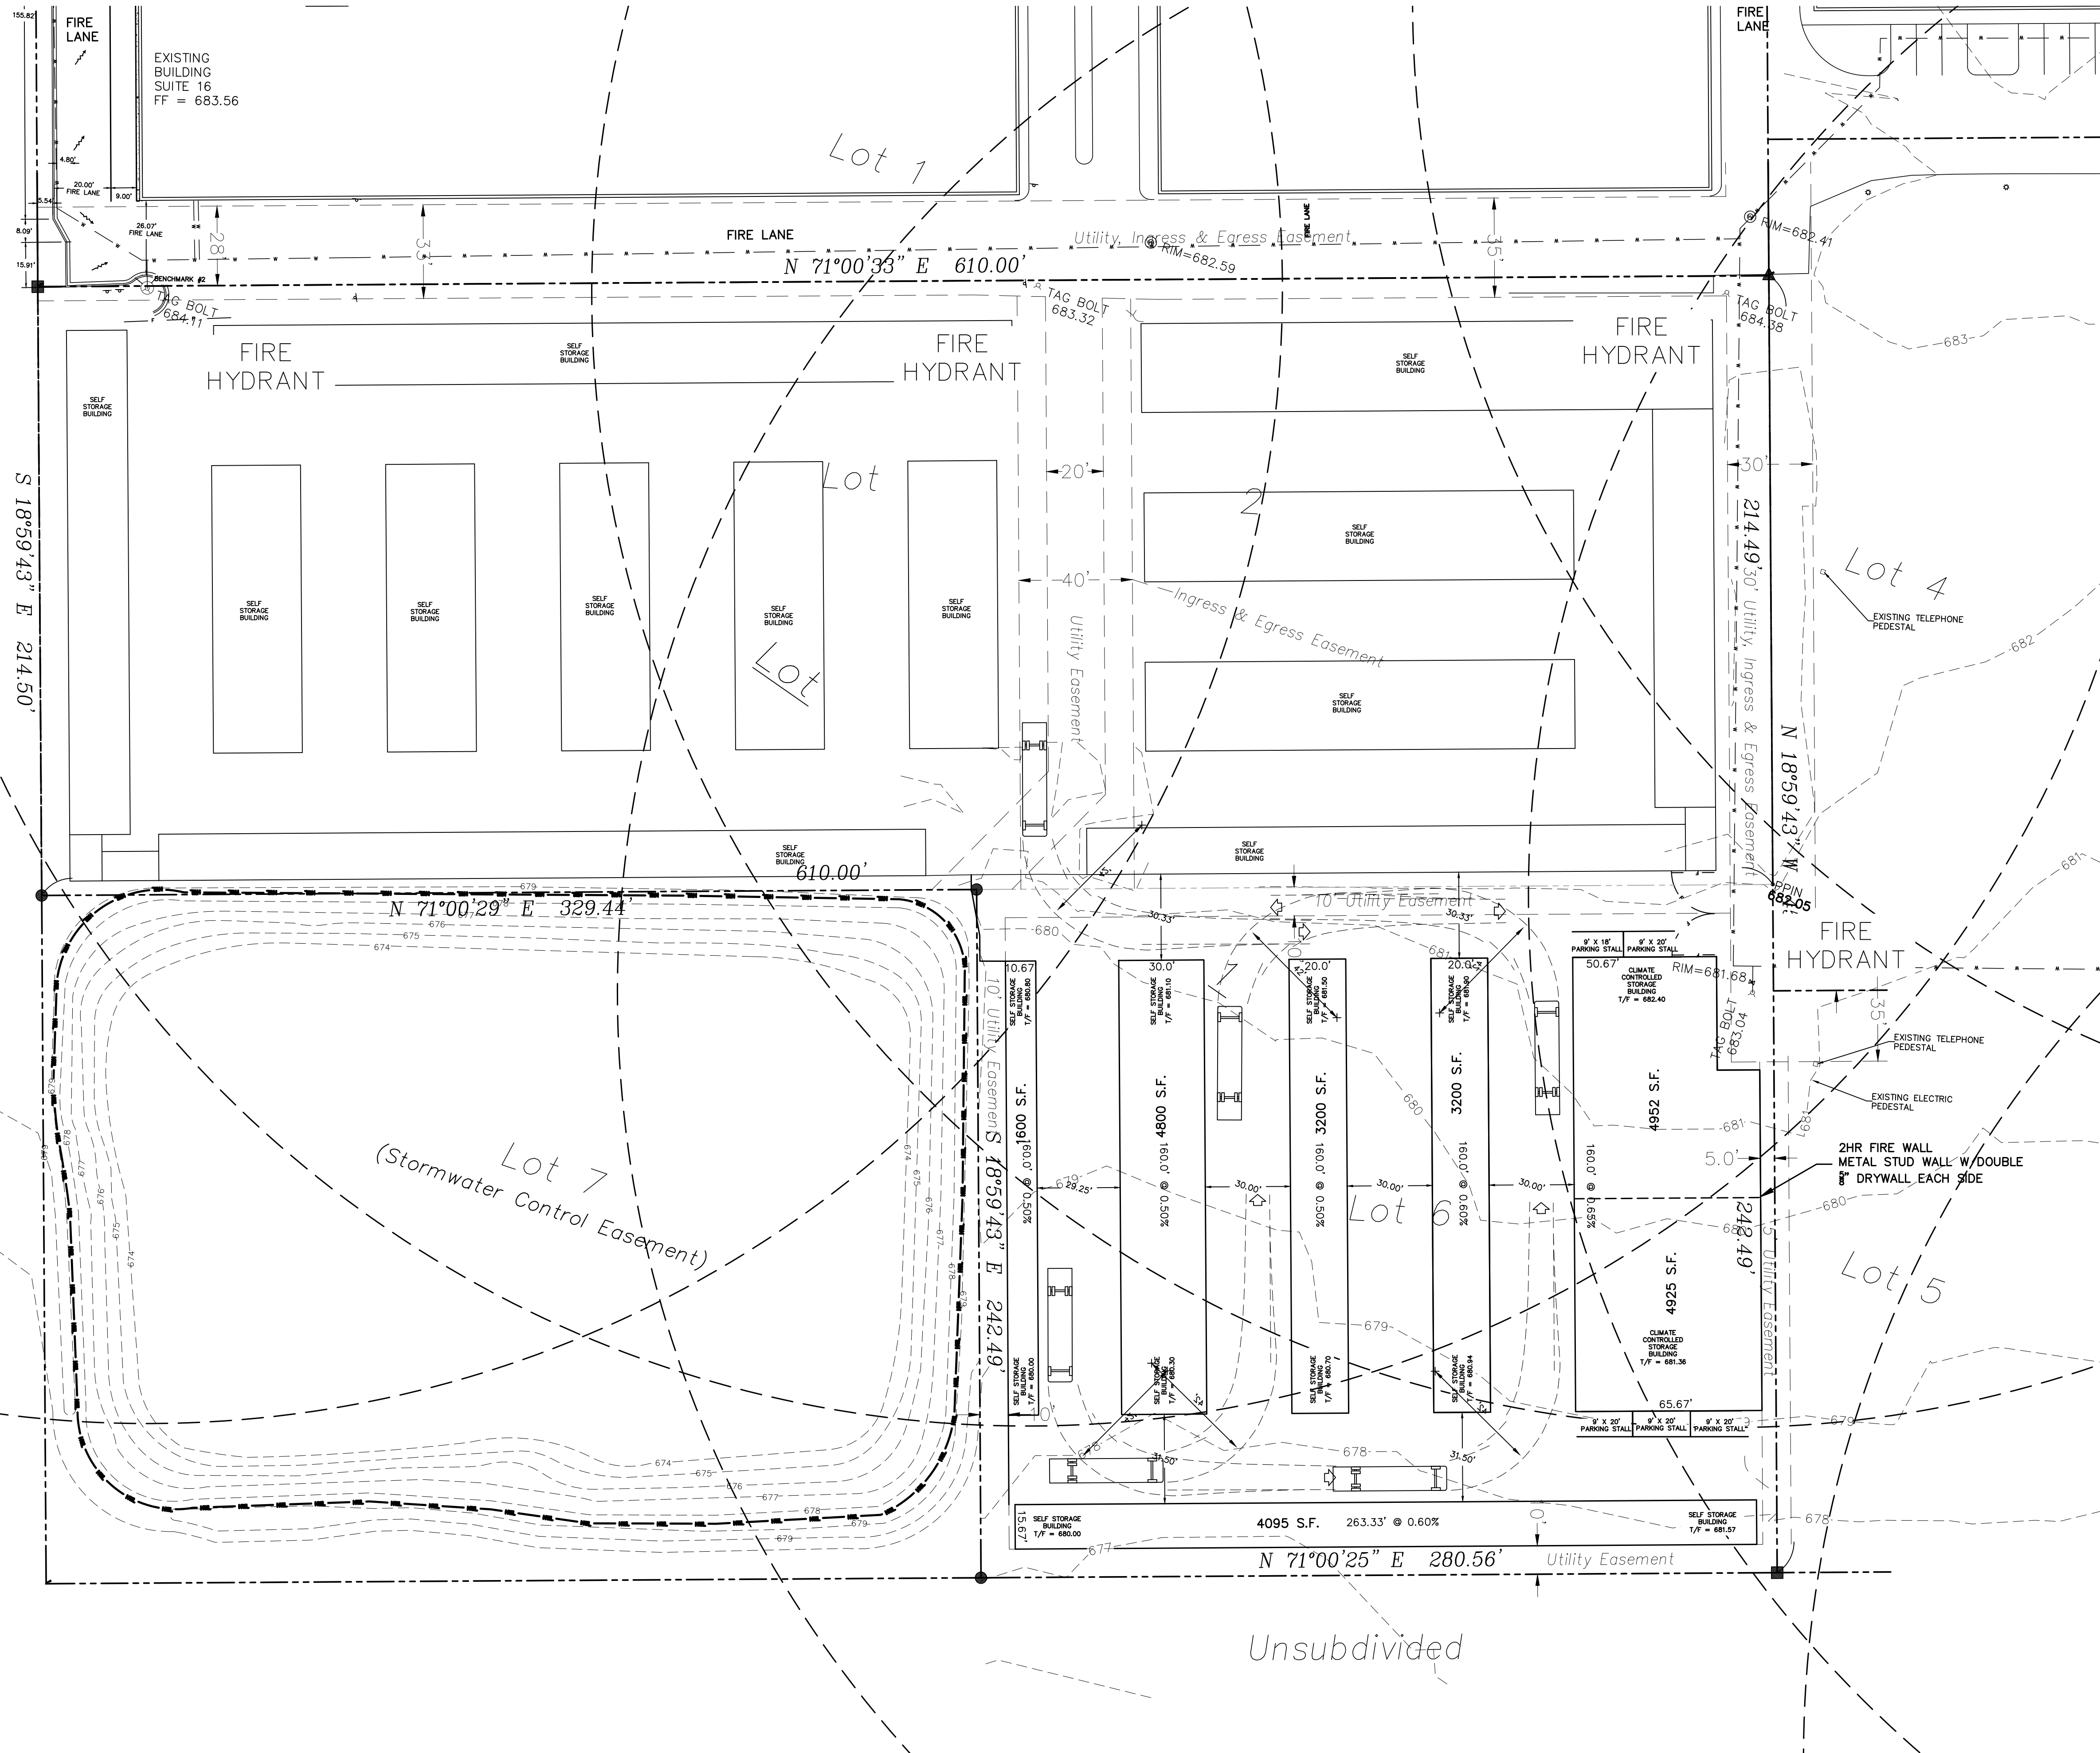

LEGEND	
---	PROPERTY BOUNDARY
---	EXISTING CONTOUR LINE
---	EXISTING STORM SEWER
---	EXISTING SANITARY SEWER LINE
---	EXISTING WATERMAIN
---	EXISTING UNDERGROUND ELECTRIC
---	EXISTING OVERHEAD ELECTRIC
---	EXISTING GAS SERVICE
---	EXISTING TELEPHONE
---	PROPOSED CONTOUR LINE
---	PROPOSED WATERMAIN
---	PROPOSED STORM SEWER
---	PROPOSED SANITARY SEWER LINE
---	PROPOSED GREASE SERVICE LINE
---	PROPOSED VENT LINE
---	EXISTING FENCELINE
---	PROPOSED SILT FENCE
---	EXISTING SPOT SHOT
---	PROPOSED SPOT GRADE
---	EXIST
---	PROP
WATER: ---	B-BOX
---	HYDRANT
---	VALVE
---	VALVE VAULT
---	INLET-CURB
---	INLET OR MANHOLE
---	FLARED END SECTION
---	CLEANOUT
---	MANHOLE
---	UTILITY POLE
---	GUY WIRE LOC.
---	UTIL. CABINET
---	UTIL. PEDESTAL
---	LIGHT POLE
---	TRAFFIC SIGNAL
---	ELECTRIC VAULT
---	GAS VALVE

Fire Access Plan Data Table		
Description	Value	Unit
a) Building Height	10.00	feet
b) Building Square Footage (typical)	26,802	square feet
c) Building fire suppression information including any proposed use of sprinkler systems, fire alarm systems, whether fire extinguishers are needed: no sprinkler system, the climate controlled building will have a 2hr fire wall consisting of metal stud		
d) General description of business to be conducted within each building including: will there be rack storage in the building, will there be storage of combustible materials over twelve feet in height, clearance of sprinkler heads and stored materials (18 inch minimum): 5 self storage buildings and 1 climate controlled self storage building		

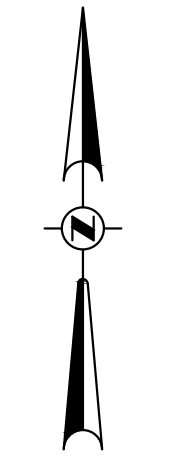

TEBRUGGE ENGINEERING
410 E. CHURCH STREET - SUITE A SANDWICH, IL 60548
PHONE: (815) 786-0195 TEBRUGGEENGINEERING.COM

NO.	DATE	NOTES

PREPARED FOR:
4M SELF STORAGE, INC.
1649 MONTGOMERY ROAD, AURORA, IL

WATERFORD PLAZA SITE PLAN - LOT 6
FIRE PLAN FOR WATERFORD PLAZA RESUBDIVISION

PROJECT NO. **17 276 03** SHEET NO. **1**
SCALE: **1" = 30'**
DATE: **6.5.17** OF 1 SHEETS