


WEST GALENA BOULEVARD WATER MAIN LINING & REPLACEMENT

MAY, 2019

GENERALLY LOCATED: N 1/2 SECTION 19, T38N, R8E

LEGEND	
EXISTING	PROPOSED
SANITARY SEWER 8" PVC	→
STORM SEWER 12" STORM	→
WATER MAIN 8" WM	→
GAS LINE	→
TELEPHONE LINE	→
ELECTRIC LINE	→
FENCE	→
INDEX CONTOUR	→
INTERMEDIATE CONTOUR	→
EDGE OF PAVEMENT	→
CURB AND GUTTER	→
RIGHT-OF-WAY	→
SANITARY MANHOLE	⊙
SANITARY CLEANOUT	⊙
STORM MANHOLE	⊙
CATCH BASIN	⊙
INLET	⊙
FLARED END SECTION	⊙
FIRE HYDRANT	⊙
VALVE VAULT	⊙
VALVE BOX	⊙
STREET LIGHT	⊙
POWER POLE	⊙
STREET SIGN	⊙
ELECTRIC BOX	⊙
TELEPHONE BOX	⊙
TELEPHONE MANHOLE	⊙
B-BOX	⊙
GAS VALVE	⊙
TRAFFIC HANDHOLE	⊙
ELECTRIC HANDHOLE	⊙
MAILBOX	⊙
PARKING METER	⊙
TREE W/ DIAMETER	⊙
UTILITY CROSSING	⊙
SPOT ELEVATION	⊙
TOP OF CURB ELEVATION	⊙
TOP OF FOUNDATION ELEVATION	⊙
GUTTER ELEVATION	⊙
PAVEMENT ELEVATION	⊙
FORCE MAIN	→
UNDERDRAIN	→
OVERHEAD LINE	→
CABLE TV LINE	→
HIGH WATER LEVEL	→
NORMAL WATER LEVEL	→
PAVEMENT FLOW DIRECTION	→
EXPLORATORY EXCAVATION LOCATION	⊙
ADDRESS	⊙
SANITARY MANHOLE REHABILITATION NUMBER	⊙
SOIL BORING LOCATION WITH IDENTIFICATION NUMBER & ELEVATION	⊙
STRUCTURE TO BE REMOVED	⊙
PLUG EXISTING PIPE	⊙

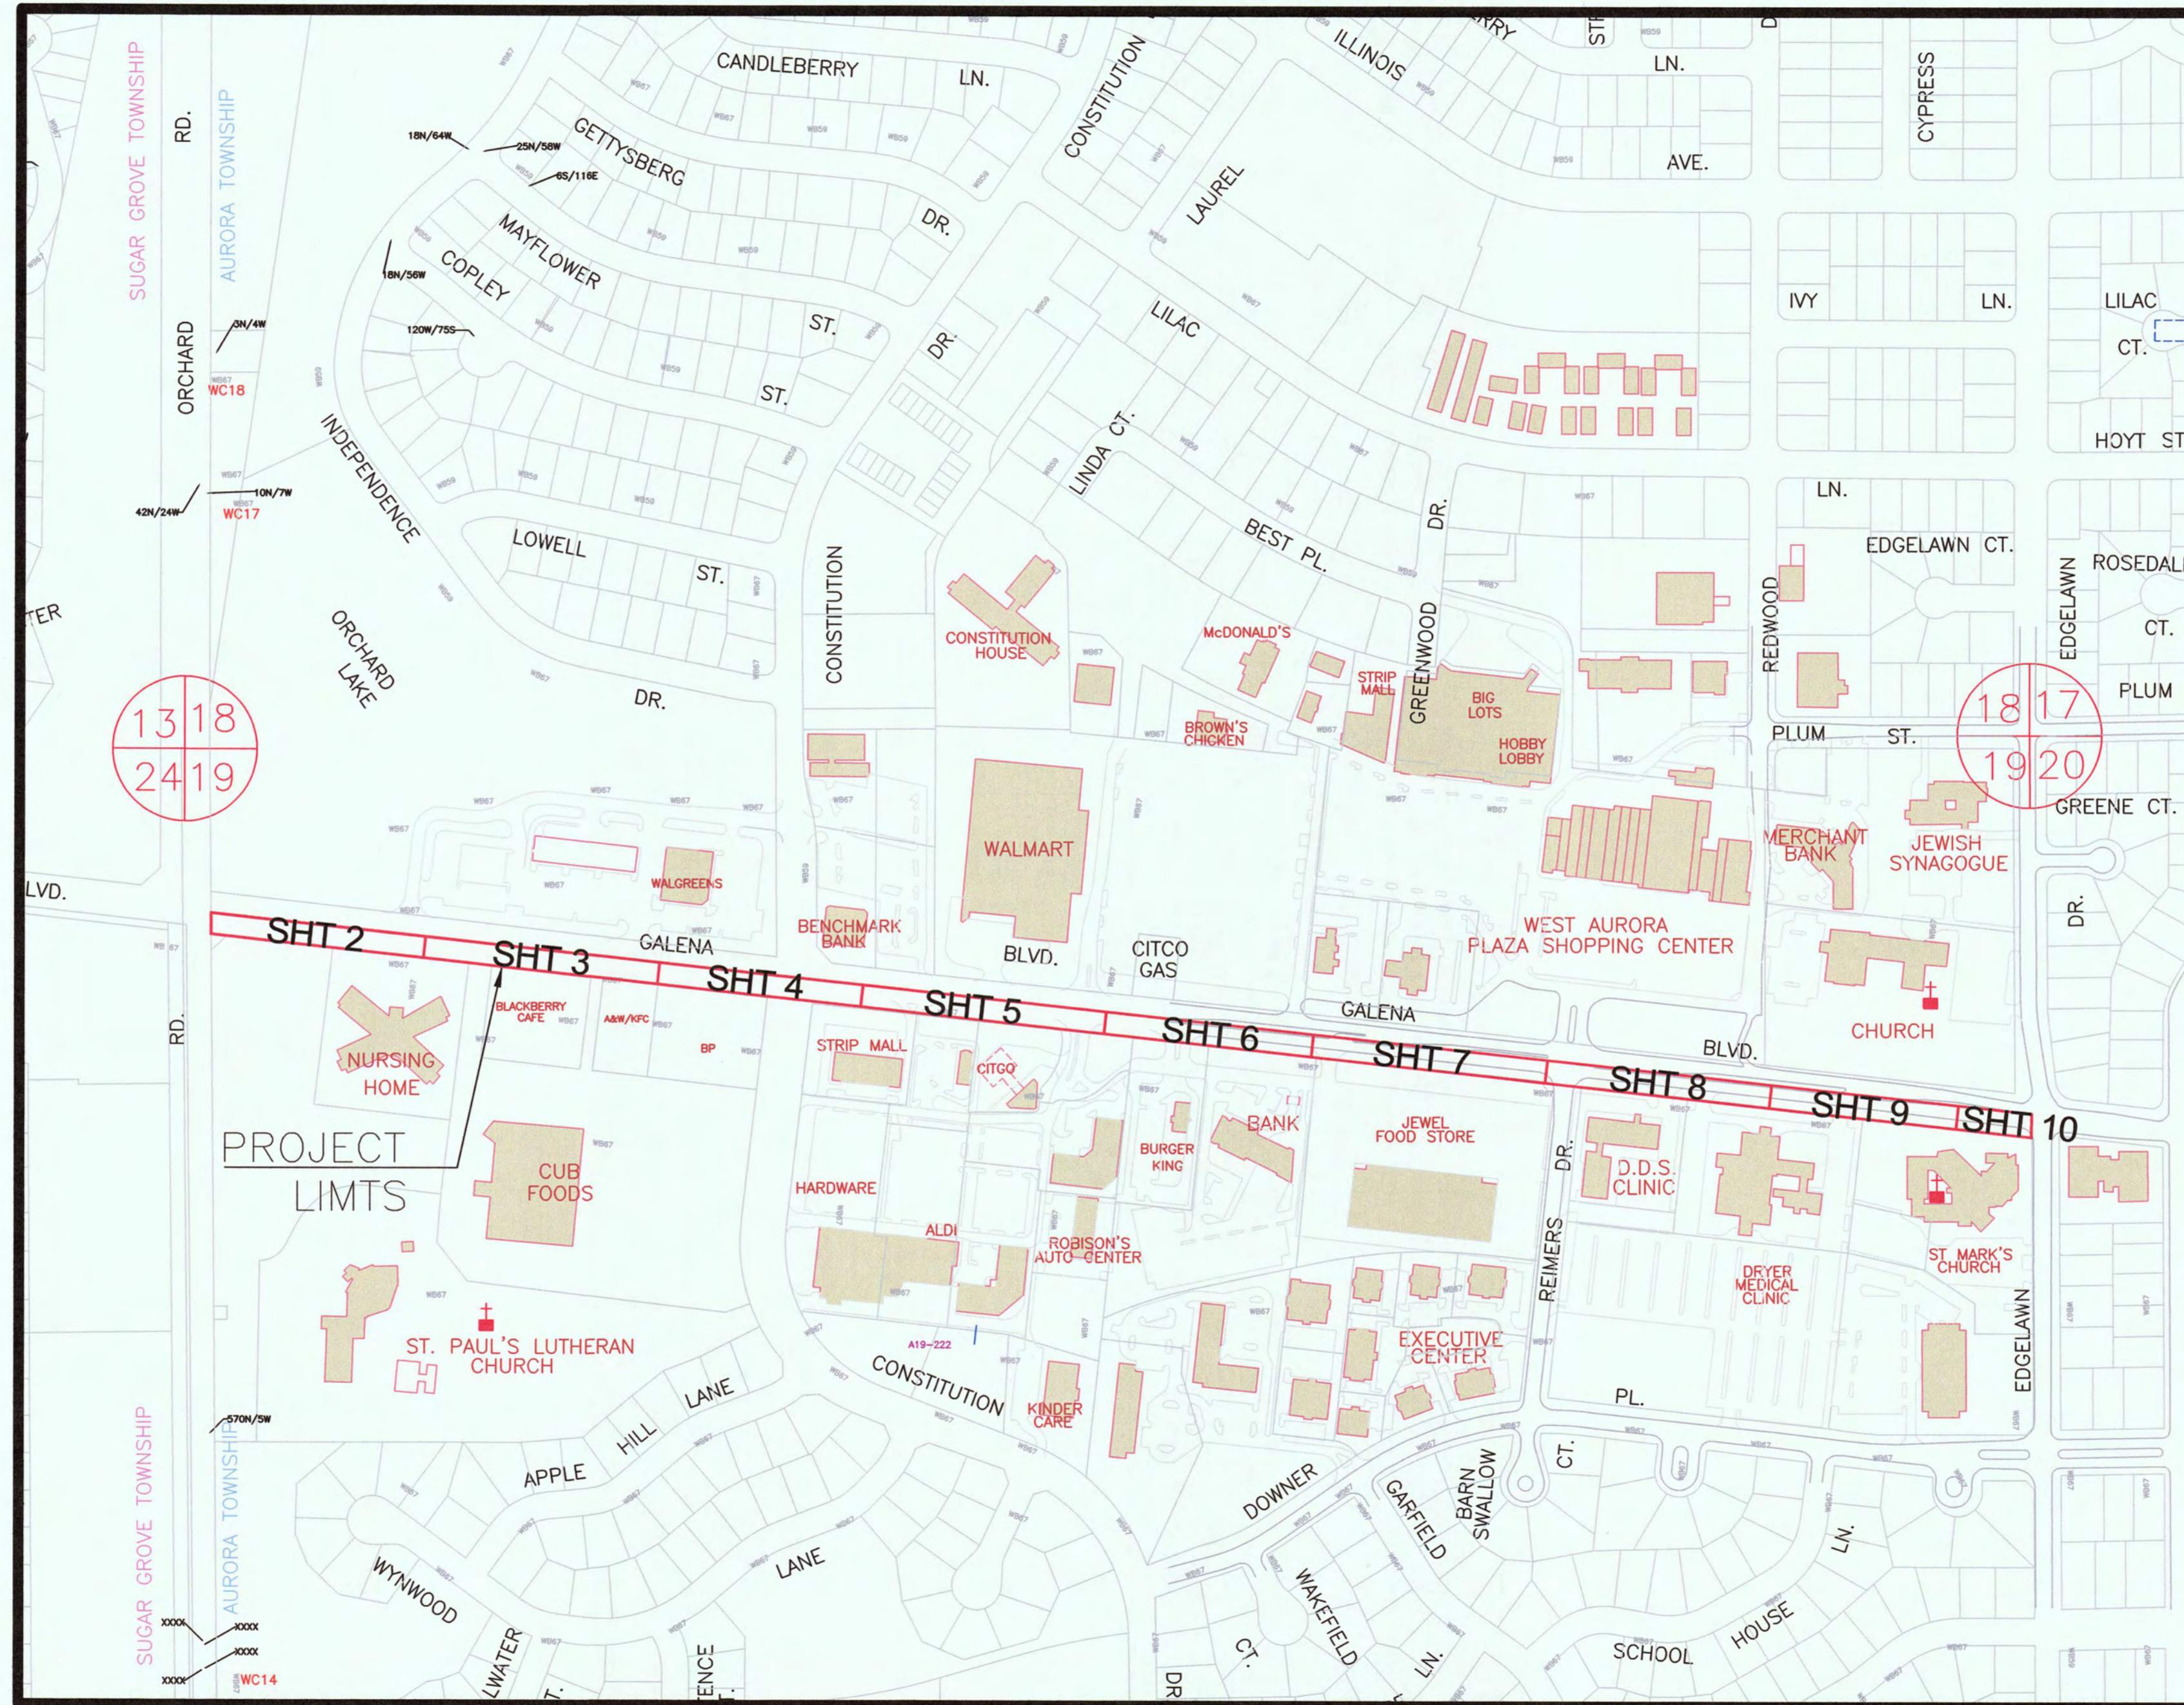

INDEX OF SHEETS

- 1 COVER SHEET
- 2-10 PLAN AND PROFILE
- 11-14 STANDARD DETAIL SHEETS

PLANS PREPARED BY:

CITY OF AURORA


DEPARTMENT OF PUBLIC WORKS, DIVISION OF ENGINEERING

77 S. BROADWAY AVE. - AURORA, IL

PHONE: 630-256-3200 FAX: 630-256-3229

REVISIONS:

DESIGNED BY: KTM	DRAWN BY: KTM	CHECKED BY: JMB	APPROVED BY: JMB	HORIZ. SCALE: N/A	DATE: MAY 2019
				VERT. SCALE: N/A	

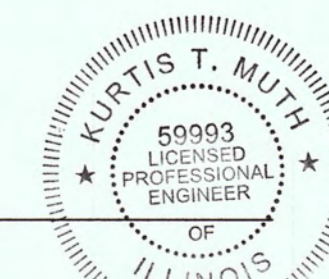

Kurtis T. Muth

ILLINOIS REGISTERED PROFESSIONAL

ENGINEER No. 69993

LICENSE EXPIRES NOVEMBER 30, 2019

5/4/19

DATE