


BENTON STREET WATER MAIN REPLACEMENT

JUNE 2018

GENERALLY LOCATED: T38N, R8E, SECTION 22, AURORA TOWNSHIP

LEGEND	
EXISTING	PROPOSED
SANITARY SEWER	---
STORM SEWER	---
WATER MAIN	---
GAS LINE	---
TELEPHONE LINE	---
ELECTRIC LINE	---
FENCE	---
INDEX CONTOUR	---
INTERMEDIATE CONTOUR	---
EDGE OF PAVEMENT	---
CURB AND GUTTER	---
RIGHT-OF-WAY	---
SANITARY MANHOLE	○
SANITARY CLEANOUT	○
STORM MANHOLE	○
CATCH BASIN	○
INLET	○
FLARED END SECTION	○
FIRE HYDRANT	○
VALVE VAULT	○
VALVE BOX	○
STREET LIGHT	○
POWER POLE	○
STREET SIGN	○
ELECTRIC BOX	○
TELEPHONE BOX	○
TELEPHONE MANHOLE	○
B-BOX	○
GAS VALVE	○
TRAFFIC HANDHOLE	○
ELECTRIC HANDHOLE	○
MAILBOX	○
PARKING METER	○
TREE W/ DIAMETER	○
UTILITY CROSSING	○
SPOT ELEVATION	X
TOP OF CURB ELEVATION	X
TOP OF FOUNDATION ELEVATION	X
GUTTER ELEVATION	X
PAVEMENT ELEVATION	X
FORCE MAIN	---
UNDERDRAIN	---
OVERHEAD LINE	---
CABLE TV LINE	---
HIGH WATER LEVEL	---
NORMAL WATER LEVEL	---
PAVEMENT FLOW DIRECTION	---
EXPLORATORY EXCAVATION LOCATION	○
ADDRESS	○
SANITARY MANHOLE REHABILITATION NUMBER	○
SOIL BORING LOCATION WITH IDENTIFICATION NUMBER & ELEVATION	○
STRUCTURE TO BE REMOVED	○
PLUG EXISTING PIPE	○

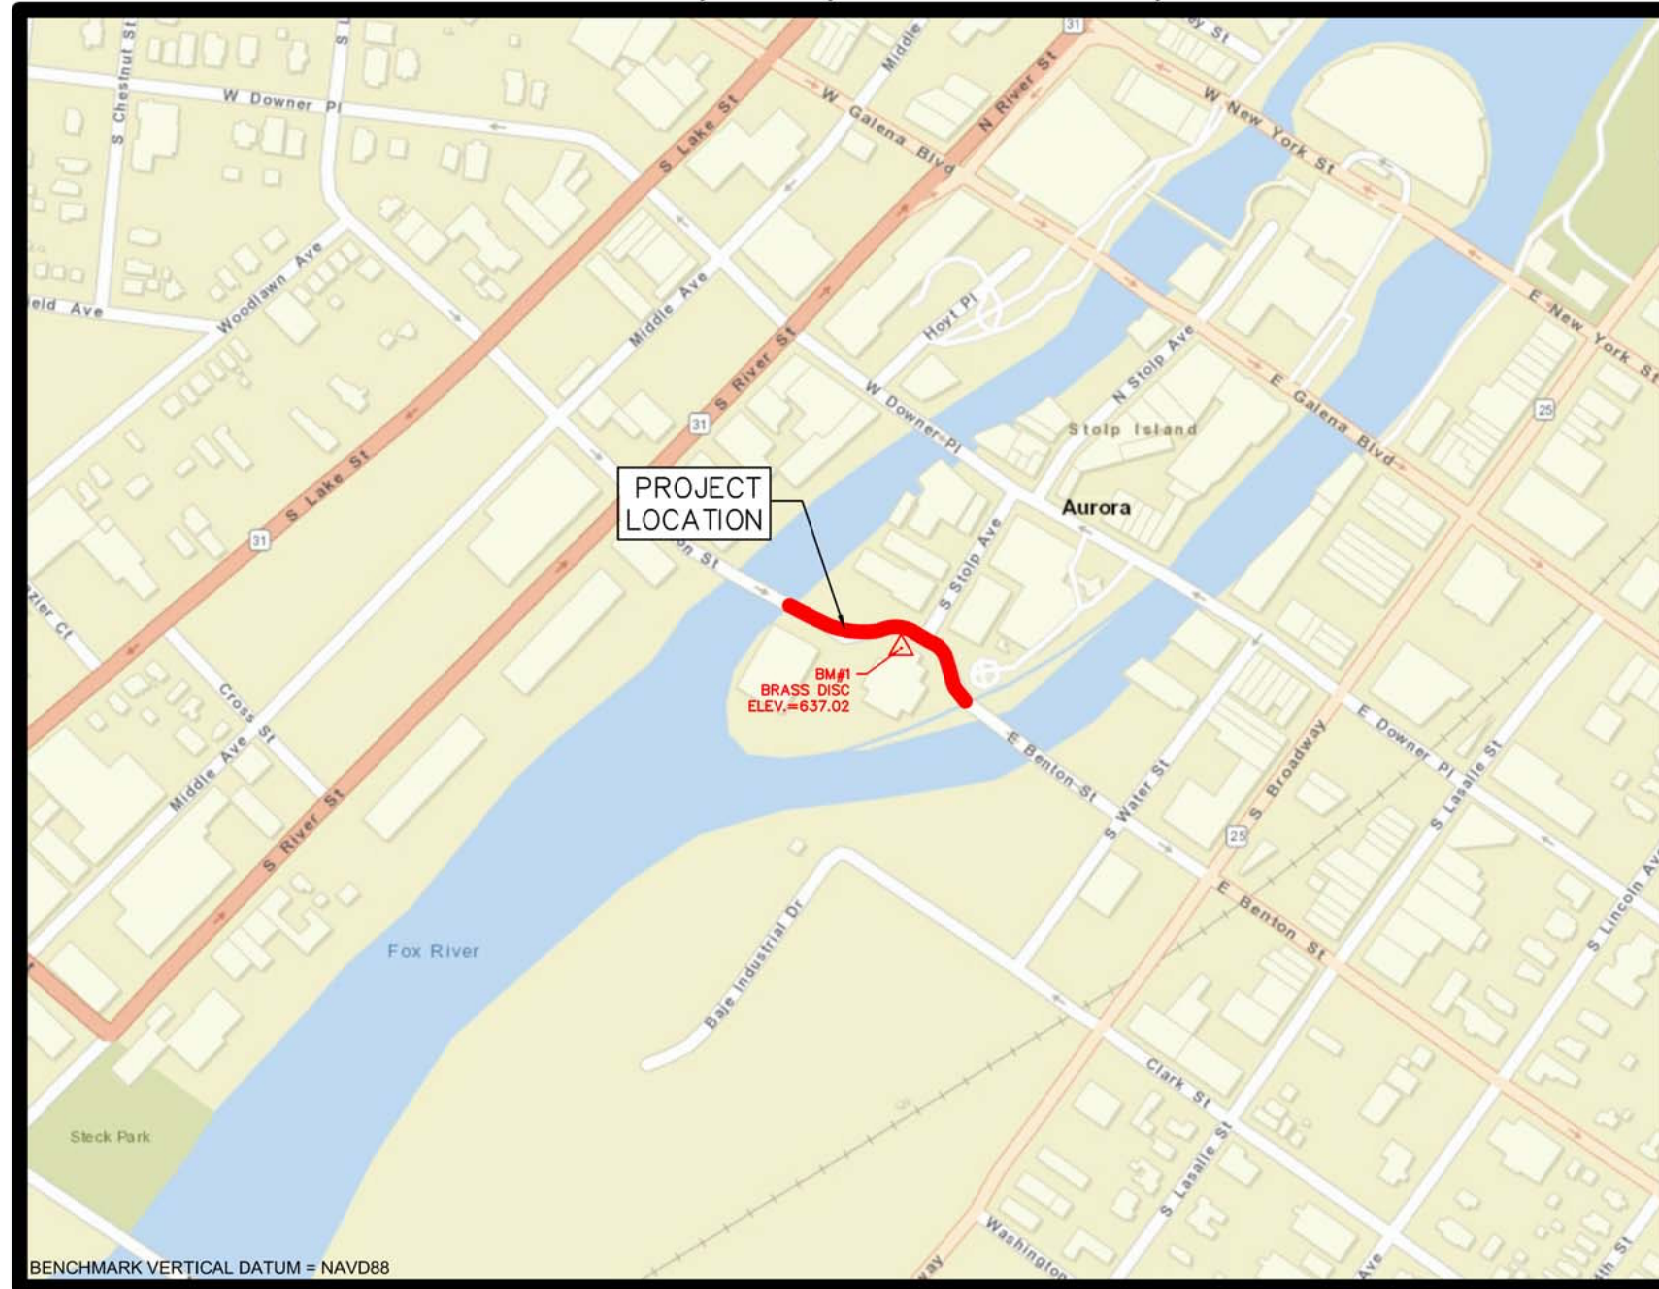

NOTE:
CONTRACTOR TO CONTACT J.U.L.I.E.
PRIOR TO STARTING CONSTRUCTION

INDEX OF SHEETS

- 1 COVER SHEET
- 2 PLAN AND PROFILE
- 3-5 STANDARD DETAILS

PLANS PREPARED BY:



DEPARTMENT OF PUBLIC WORKS
ENGINEERING DIVISION

PLANS DESIGNED BY:

CITY OF AURORA

DEPARTMENT OF PUBLIC WORKS, DIVISION OF ENGINEERING

44 E. DOWNER PLACE - AURORA, IL

PHONE: 630-256-3200 FAX: 630-256-3229

REVISIONS:

DESIGNED BY: JB	DRAWN BY: GIL	CHECKED BY: JB	APPROVED BY: JB	HORIZ. SCALE: N/A	DATE: 6/2018
				VERT. SCALE: N/A	

ILLINOIS REGISTERED PROFESSIONAL

ENGINEER No. 062-058265

LICENSE EXPIRES NOVEMBER 30, 2017