


# AURORA ILLINOIS

## PLANS FOR THE PROPOSED DAYWARD CT WATER MAIN LOOP DAYWARD CT. FROM OHIO ST. TO HILL AVE

FEBRUARY 2025

GENERALLY LOCATED IN THE N. 1/2 OF SEC 26, T38N, R8E

LEGEND	
EXISTING	PROPOSED
SANITARY SEWER	_____
STORM SEWER	_____
WATER MAIN	_____
FORCE MAIN	_____
UNDERDRAIN	_____
OVERHEAD LINE	_____
CABLE TV LINE	_____
GAS LINE	_____
TELEPHONE LINE	_____
ELECTRIC LINE	_____
FENCE	_____
MAJOR CONTOUR	_____
MINOR CONTOUR	_____
HIGH WATER LEVEL	_____
NORMAL WATER LEVEL	_____
PAVEMENT FLOW DIRECTION	
SPOT ELEVATION	
TOP OF CURB ELEVATION	
TOP OF FOUNDATION ELEVATION	
GUTTER ELEVATION	
PAVEMENT ELEVATION	
EDGE OF PAVEMENT	=====
CURB AND GUTTER	=====
RIGHT-OF-WAY	=====
SANITARY MANHOLE	
SANITARY CLEANOUT	
STORM MANHOLE	
CATCH BASIN	
INLET	
FLARED END SECTION	
FIRE HYDRANT	
VALVE VAULT	
VALVE BOX	
STREET LIGHT	
POWER POLE	
STREET SIGN	
ELECTRIC BOX	
TELEPHONE BOX	
TELEPHONE MANHOLE	
B-BOX	
GAS VALVE	
TRAFFIC HANDHOLE	
ELECTRIC HANDHOLE	
TREE W/ DIAMETER	
MAILBOX	
INLET PROTECTION	
STRUCTURE TO BE REMOVED	
PLUG EXISTING PIPE	
UTILITY CROSSING	
EXPLORATORY EXCAVATION LOCATION	
SANITARY MANHOLE REHABILITATION NUMBER	
SOIL BORING LOCATION WITH IDENTIFICATION NUMBER & ELEVATION	

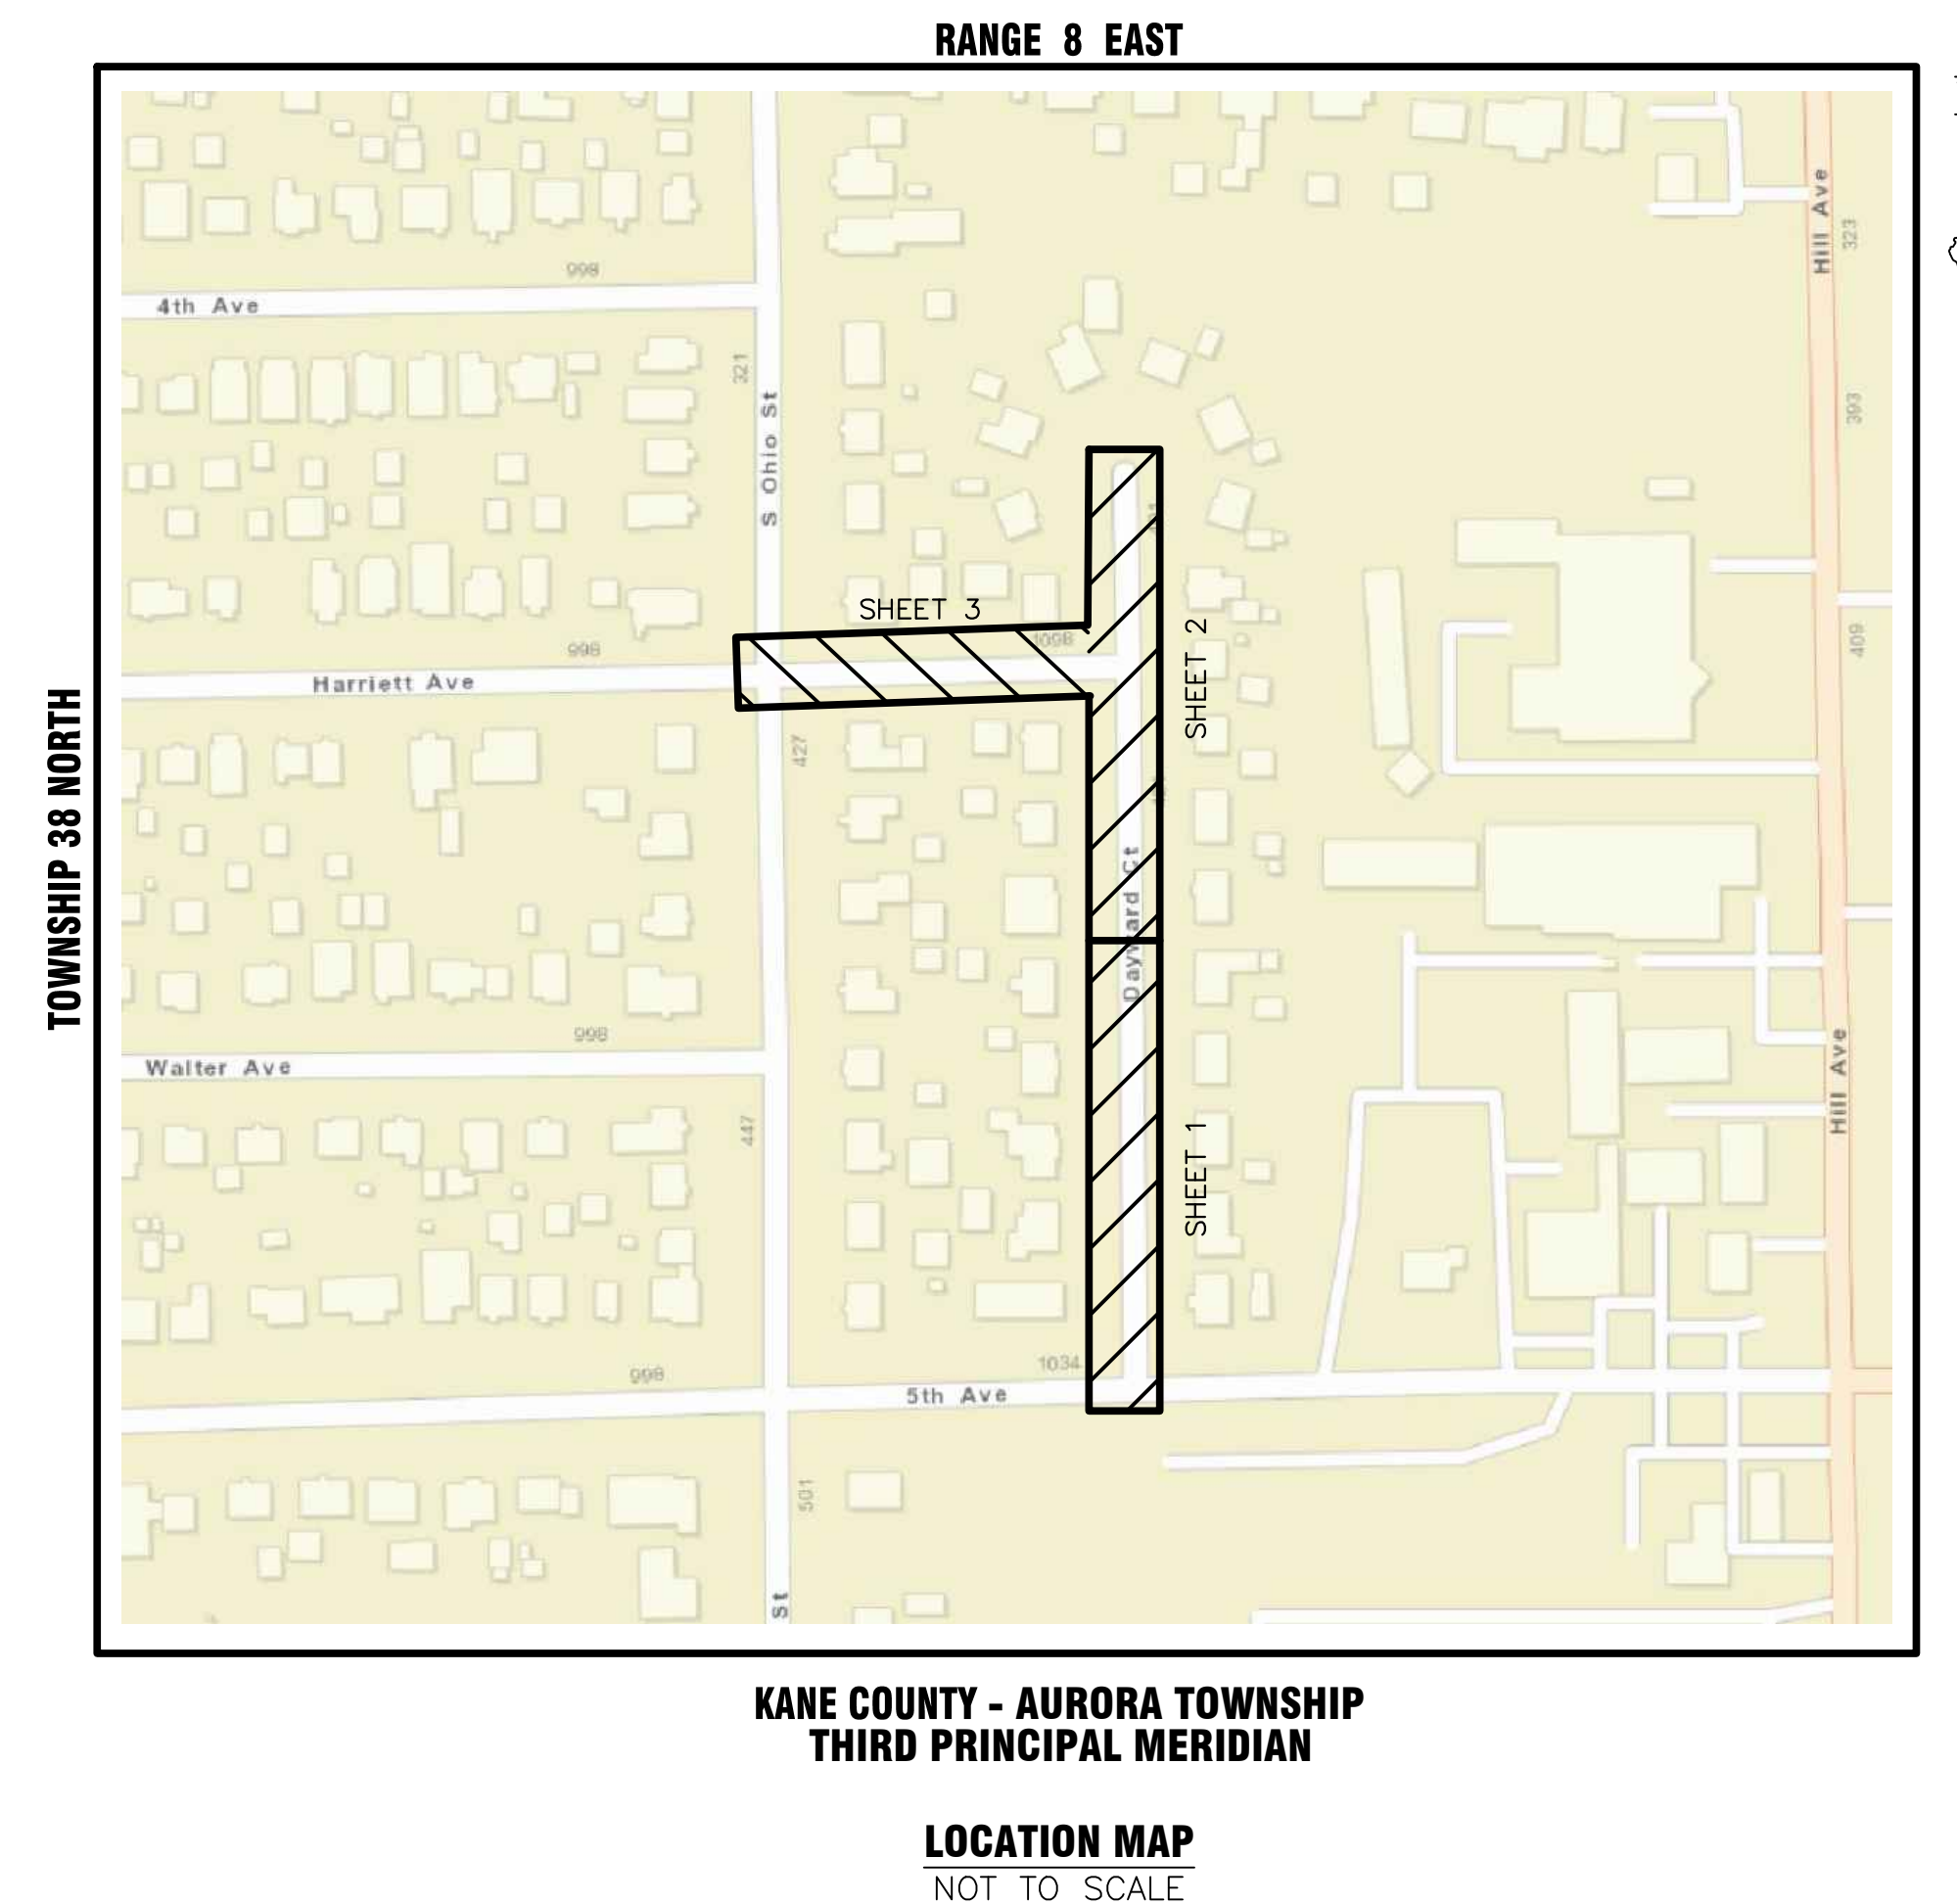

### INDEX OF SHEETS

- 1 COVER SHEET
- 2-4 PLAN AND PROFILE
- 5-10 STANDARD DETAILS



**J.U.L.I.E.**  
JOINT UTILITY LOCATION INFORMATION FOR EXCAVATION  
811 OR 1-800-892-0123

CONSTRUCTION AND MAINTENANCE TO BE IN ACCORDANCE WITH ALL APPLICABLE REGULATORY REQUIREMENTS AND STANDARDS

**PRINTED BY THE AUTHORITY  
OF THE CITY OF AURORA**

PLANS PREPARED BY:

**CITY OF AURORA**

DEPARTMENT OF PUBLIC WORKS - ENGINEERING DIVISION  
77 S. BROADWAY AVE, AURORA, IL 60505

PHONE: 630-256-3200 FAX: 630-256-3229

REVISIONS:

DESIGNED BY: OSC	DRAWN BY: AHB	CHECKED BY: KTM	APPROVED BY: KTM	HORIZ. SCALE: N/A	DATE: 2025
				VERT. SCALE: N/A	

STAMP

ILLINOIS REGISTERED PROFESSIONAL

ENGINEER No. 062.59993

LICENSE EXPIRES NOVEMBER 30, 2025

DATE