


FIRE ACCESS PLAN

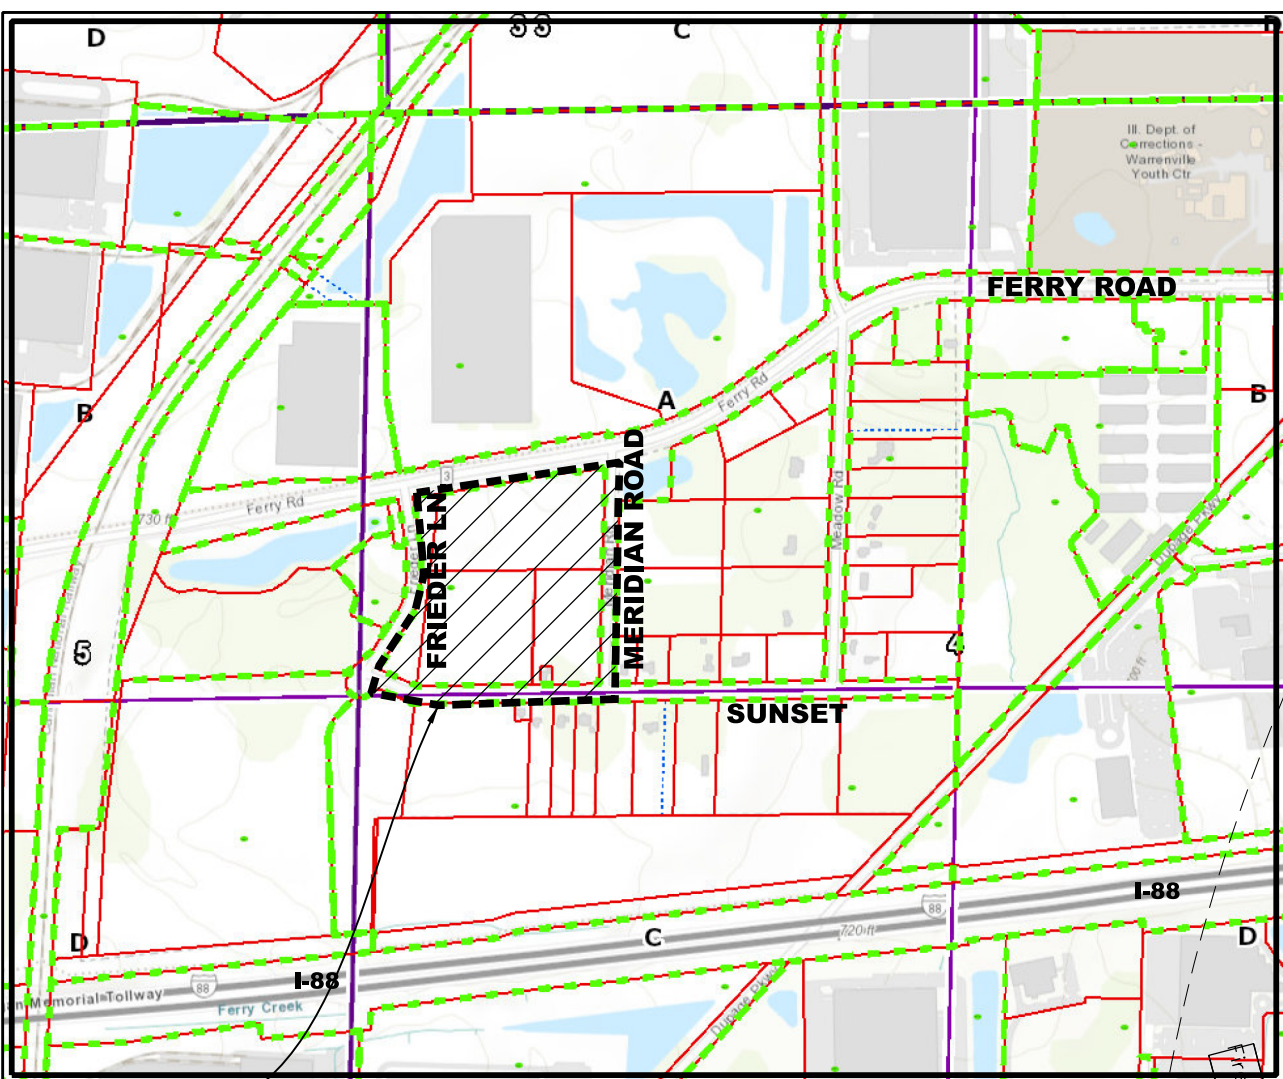

SITE LOCATION

FRIEDER LANE

SUNRISE ROAD

FERRY ROAD

Proposed Warehouse
270,934SF

SPRINKLER ROOM

FDC

FIRE TRUCK STAGING

HYDRANT

HYDRANT

Fire Access Plan Data Table		
Description	Value	Unit
a) Building Height	45.00	feet
b) Building Square Footage (typical)	270,934	square feet
c) Building fire suppression information including any proposed use of sprinkler systems, fire alarm systems, whether fire extinguishers are needed:	Sprinkler	
d) General description of business to be conducted within each building including: will there be rack storage in the building, will there be storage of combustible materials over twelve feet in height, clearance of sprinkler heads and stored materials (18 inch minimum):	0	

- 400' Fire Hydrant Radius
- Existing/Proposed Fire Hydrant
- 26x40 feet Truck Staging Area

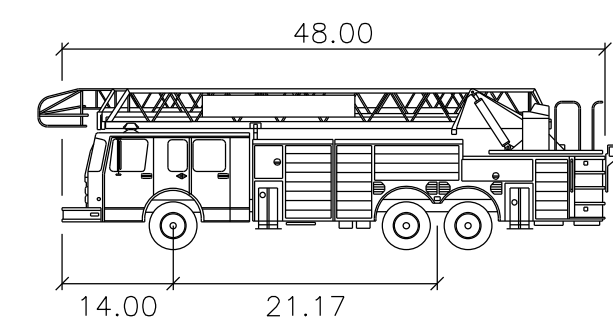

Fire Truck = 48'foot
Width : 9.60
Track : 6.00
Lock to Lock Time : 6.0
Steering Angle : 41.5

PROPOSED WAREHOUSE
SW CORNER FERRY AND MERIDIAN ROADS
AURORA, IL

Prepared For:
Logistics Property Company, LLC
One North Wacker Drive, Suite 1925
Chicago, IL 60606
Phone: 708.667.8866

WEBSTER, MCGRATH & AHLBERG, LTD.
WMA
Over 60 Years of Service to Clients
LAND SURVEYING, CIVIL ENGINEERING, LANDSCAPE ARCHITECTURE
207 SOUTH MARSHVILLE ROAD, WILMINGTON, ILLINOIS 60407
PH: (630) 667-2000 WWW.WMA-IL.COM
COUNTY FIRE LICENSE NO. 104-0000001

REV#	DATE	DESCRIPTION
1	01-05-2022	Revised per City Review
2	01-18-2022	Revised Meridian and Sunrise Entrances

Section: Township/Range
County: NW1/4 04-38-09

JOB # 44544 SURV: Compass

DRAWN: BMB REVIEW: SMR

SCALE: 1" = 40' DATE: 10-18-2021

SHEET NAME

FIRE ACCESS PLAN

SHEET # **FAP-1**