
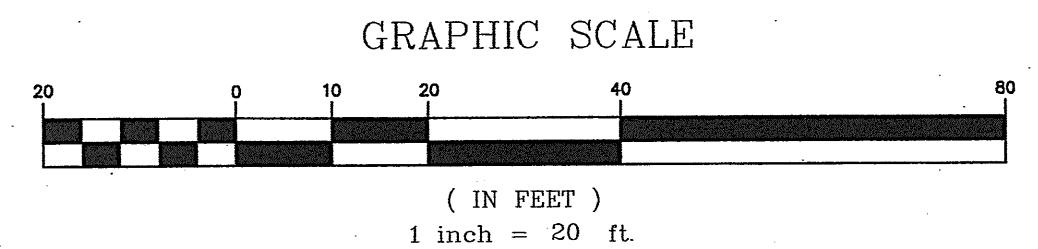


FIRE ACCESS PLAN FOR O'REILLY SUBDIVISION

URB & GUTTER (TYP.)

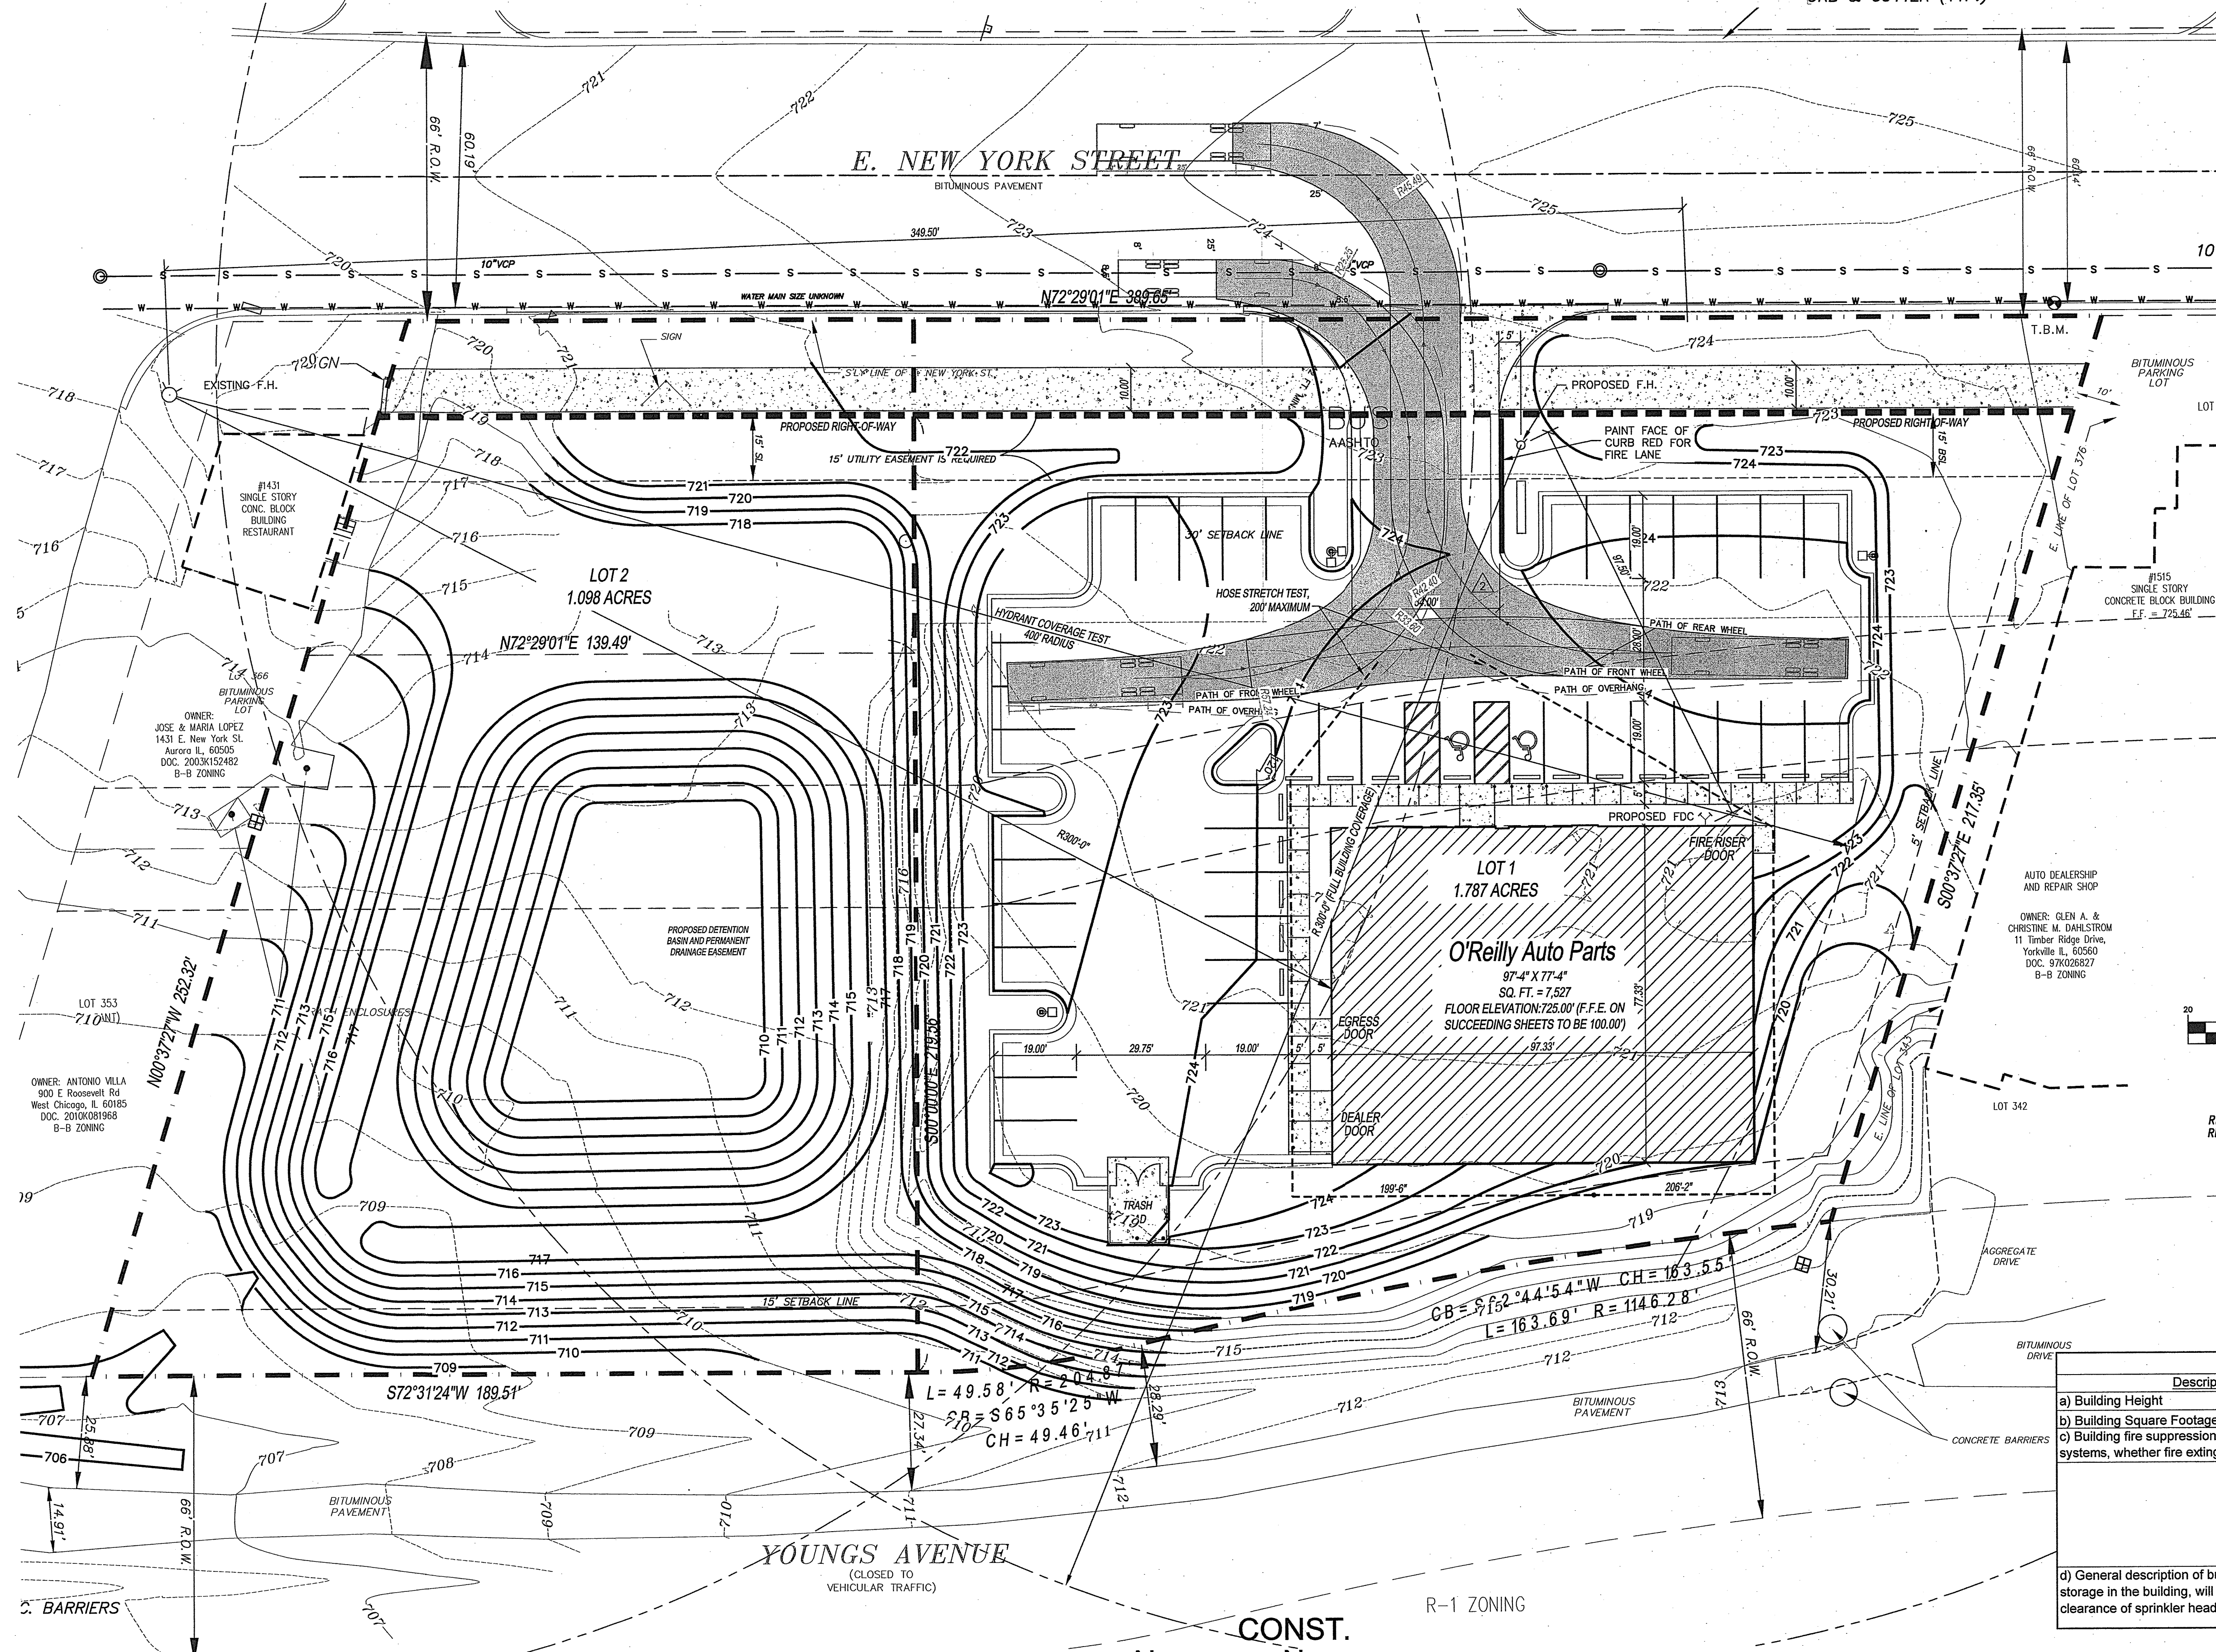

REV 1: REVISED PER CITY COMMENTS.
REV 5: REVISED PER FIRE PREVENTION & CITY COMMENTS (October 13 2016)

SYMBOLS LEGEND


NOTE: REFER TO SURVEY FOR EXISTING CONDITION SYMBOLS LEGEND.

NEW BUILDING

NEW MONUMENT SIGN LOCATION

Fire Access Plan Data Table		
Description	Value	Unit
a) Building Height	19.00	feet
b) Building Square Footage (typical)	7,527	square feet
c) Building fire suppression information including any proposed use of sprinkler systems, fire alarm systems, whether fire extinguishers are needed:		
d) General description of business to be conducted within each building including: will there be rack storage in the building, will there be storage of combustible materials over twelve feet in height, clearance of sprinkler heads and stored materials (18 inch minimum):		

1 FIRE ACCESS PLAN
F1A SCALE: 1" = 20'-0"

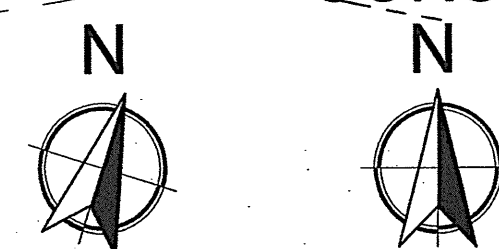

BFW **BACON | FARMER | WORKMAN**
ENGINEERING & TESTING, INC.

500 SOUTH 17th STREET PADUCAH, KY 42003 PHONE: 270.443.1955
403 NORTH COURT STREET MARION, IL 62959 PHONE: 618.997.9190
1215 DULGARD DRIVE MURRAY, KY 40371 PHONE: 270.753.7307

RONALD S. BACON
REGISTERED PROFESSIONAL ENGINEER
STATE OF ILLINOIS

FINAL PLAN O'REILLY SUBDIVISION

Plan Drafter Company: Bacon Farmer Workman Engineering & Testing, Inc.
500 S. 17th Street, Paducah, KY 42003

Owner: O'Reilly Auto Enterprises, LLC, 233 S. Patterson, Springfield, Mo 65802

Patitioner: Sheldon Jennings, 233 S. Patterson, Springfield, Mo 65802

Origin Date: 01/23/15
Revision Dates: Rev. 1 - 02/03/15, Rev. 2 - 03/12/15, Rev. 3 - 07/21/15, Rev. 4 - 12/07/15

CRAIG A. SCHNEIDER, AIA
ARCHITECT
1736 East Sunshine, Suite 417
Springfield, Missouri 65804
e-mail: architect@osterschnelder.com
417.862.0558
Fax: 417.862.3265

E. NEW YORK ST.
AURORA, IL
(AURORA #2)

O'Reilly AUTO PARTS
233 SOUTH PATTERSON
SPRINGFIELD, MISSOURI 65802
417-862-2674 PHONE

COMM # 3564

DATE: 1-23-15
REVISION
DATE:
REV 1: 7-21-15
REV 2: 12-7-15
REV 3: 4-6-16
REV 4: 5-18-16
REV 5: 10-26-16

FA1 of 1