



FIRE ACCESS PLAN
CIRCLE K
AURORA, IL

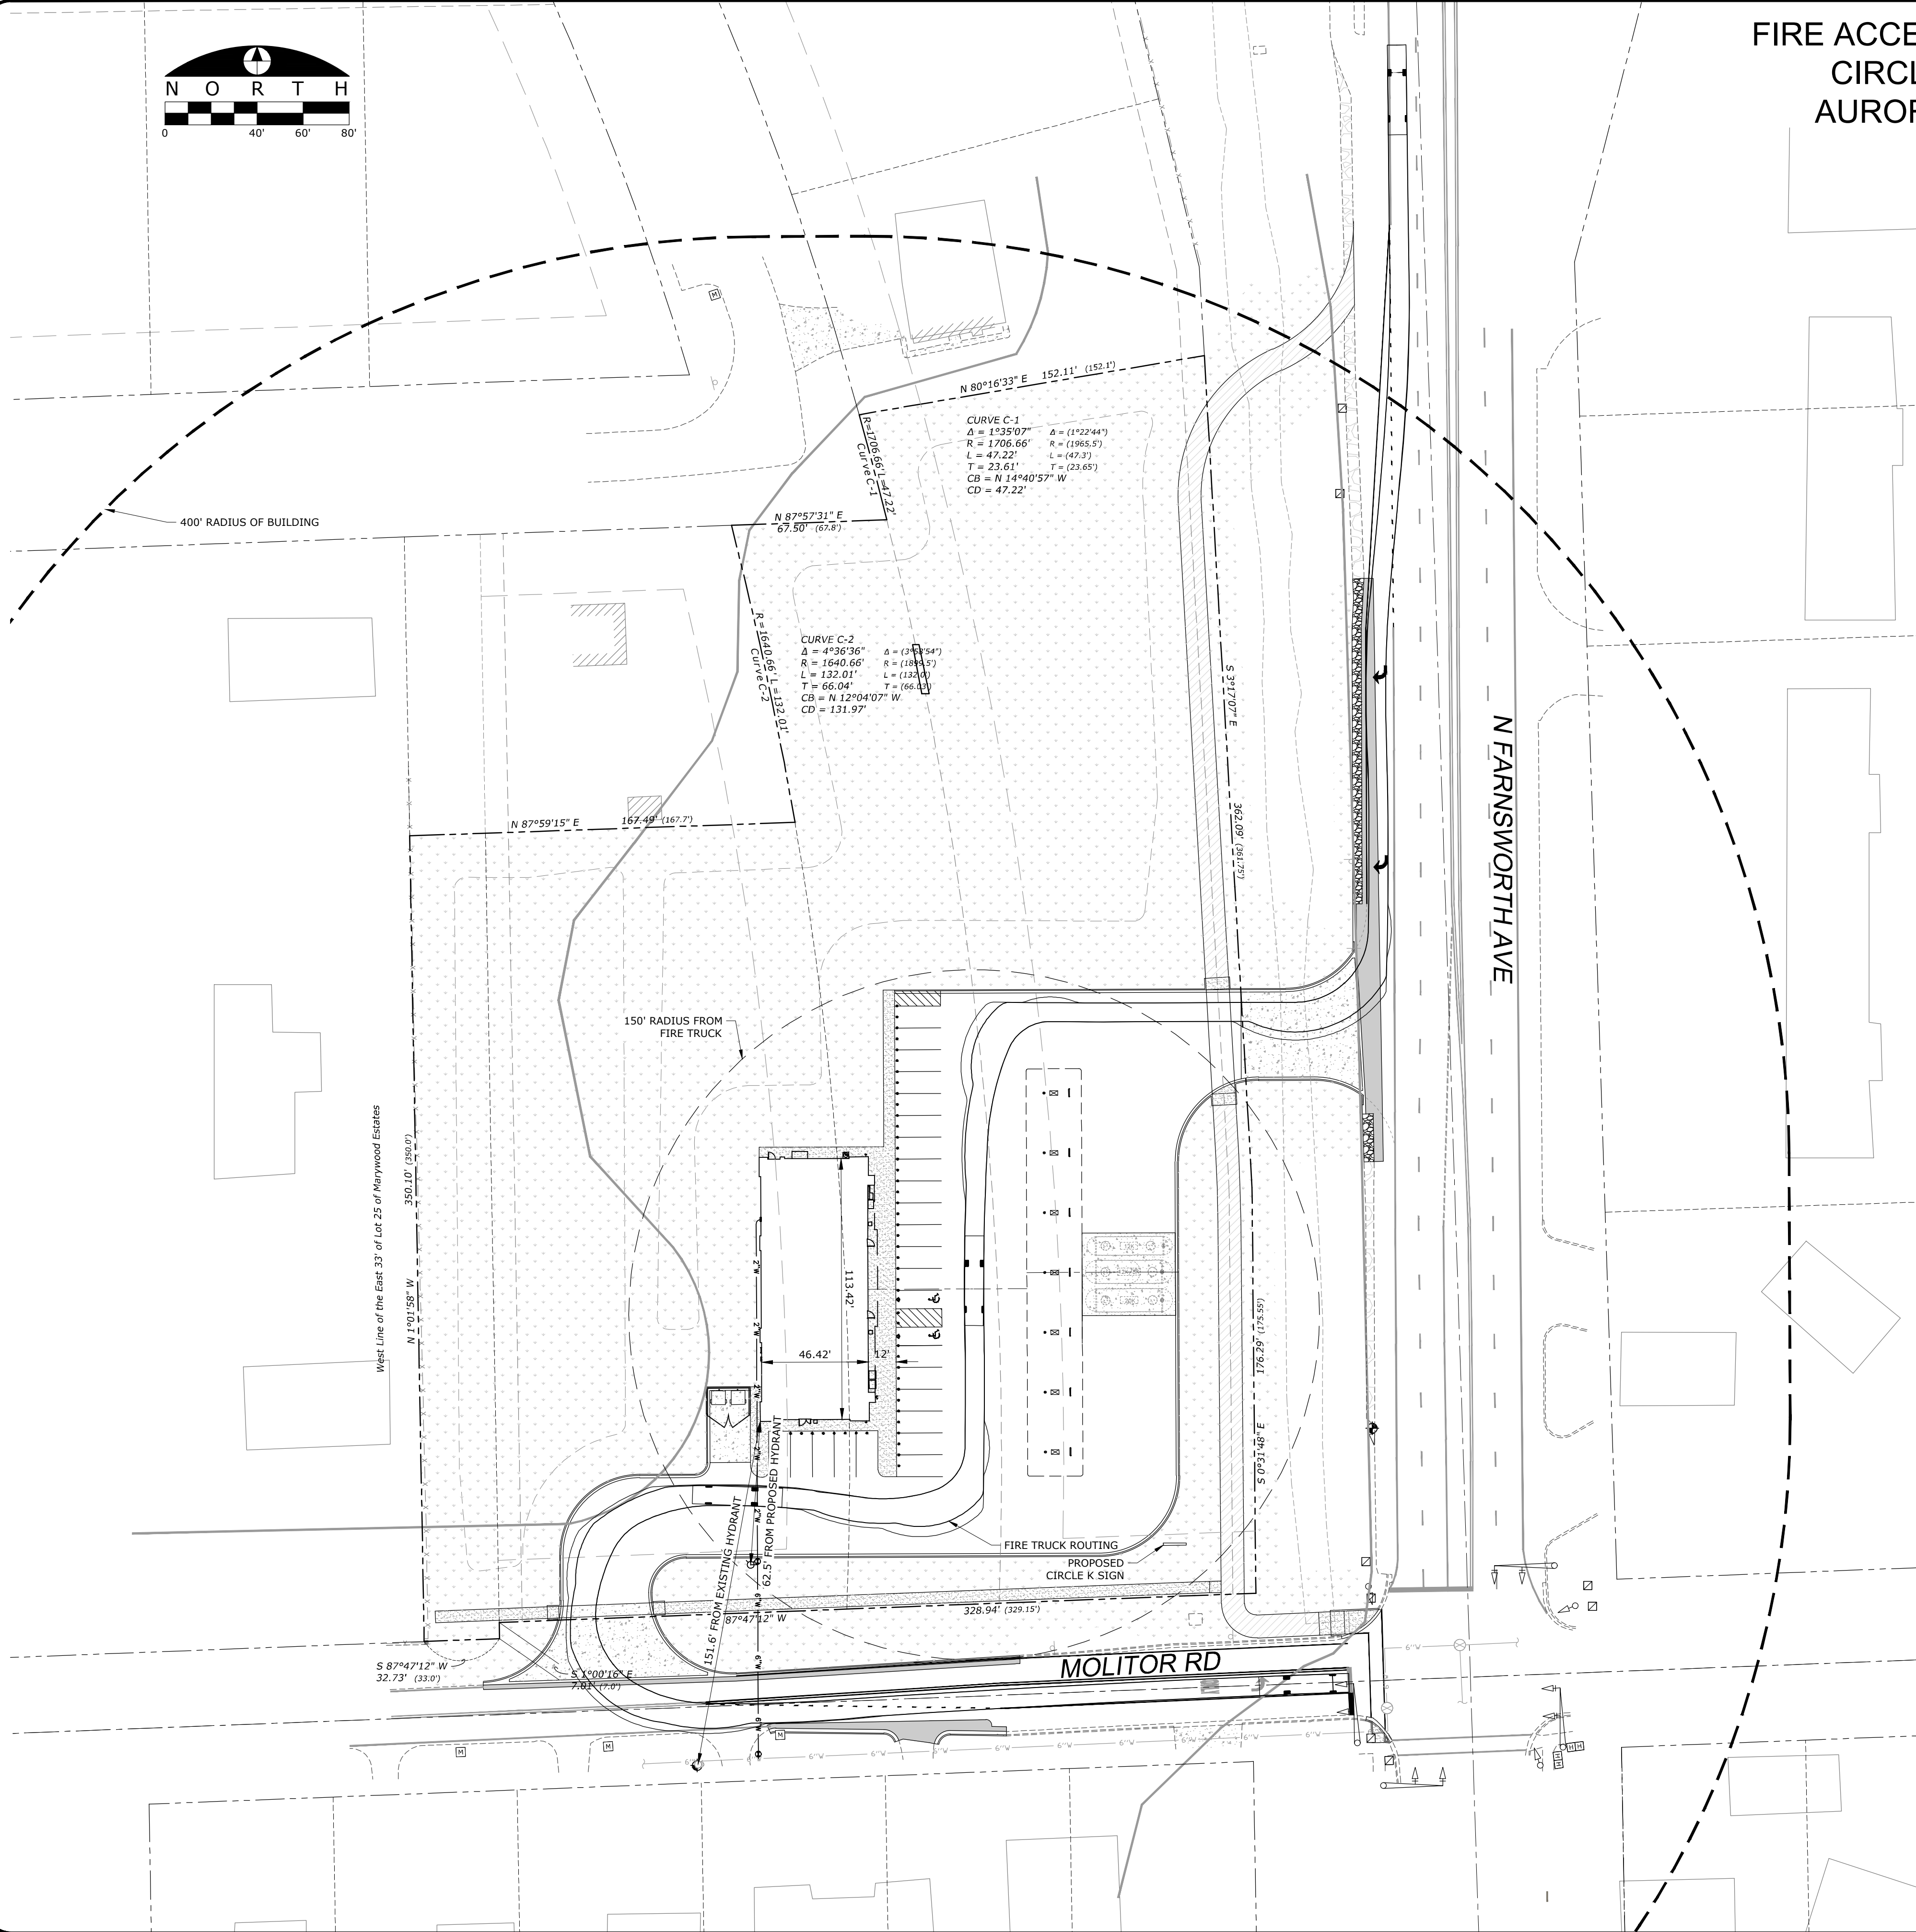

FIRE TRUCK PROFILE

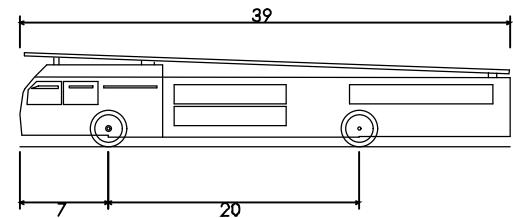

Aerial Fire Truck	
Overall Length	39.00ft
Overall Width	8.67ft
Overall Body Height	9.50ft
Min Body Ground Clearance	0.75ft
Track Width	8.67ft
Lock-to-lock time	5.00s
Max Wheel Angle	45.00°

FIRE ACCESS PLAN DATA TABLE

DESCRIPTION	VALUE	UNIT
A) BUILDING HEIGHT	-	FEET
B) SQUARE FOOTAGE OF EACH BUILDING	-	SQUARE FEET
C) BUILDING FIRE SUPPRESSION INFORMATION INCLUDING ANY PROPOSED USE OF SPRINKLERS, FIRE ALARM SYSTEMS, WHETHER FIRE EXTINGUISHERS ARE NEEDED. THE BUILDING WILL BE EQUIPPED WITH AN AUTOMATIC FIRE ALARM SYSTEM AND 8 FIRE EXTINGUISHERS LOCATED AROUND THE BUILDING.		
D) GENERAL DESCRIPTION OF BUSINESS TO BE CONDUCTED WITHIN EACH BUILDING INCLUDING: WILL THERE BE RACK STORAGE IN THE BUILDING, WILL THERE BE STORAGE OF COMBUSTIBLE MATERIALS OVER TWELVE FEET IN HEIGHT, CLEARANCE OF SPRINKLER HEADS AND STORE MATERIALS (18 INCH MINIMUM): THE PROPOSED BUILDING IS A CONVENIENCE STORE FOR A GAS STATION DEVELOPEMENT. THE BUILDING WILL INCLUDE THE SALE OF RETAIL GOODS AS WELL AS LIMITED FOOD SELECTIONS. THE 16' X 8' STORAGE ROOM WILL INCLUDE 6' TALL WIRE RACKS. NO STORAGE OVER 12 FEET IN HEIGHT.		

ARC DESIGN
RESOURCES INC.

5281 ZENITH PARKWAY
LOVES PARK, IL 61111
VOICE: (815) 484-4300
FAX: (815) 484-4303

www.arcdesign.com
Illinois Design Firm License No. 184-001334

PROJECT NAME
OWNER'S NAME

PRELIMINARY
PLAN - CIRCLE K
- AURORA, IL

NW CORNER OF
FARNSWORTH AVE.
AND MOLITOR RD.

RDK VENTURES, LLC
KEVIN KIRCHNER (OWNER REP)
550 WARRENVILLE ROAD, SUITE 400
LISLE, ILLINOIS 60532

CONSULTANTS

ISSUED FOR

1.	AGENCY REVIEW	DATE
2.	---	---
3.	---	---
4.	---	---
5.	---	---
6.	---	---
7.	---	---
8.	---	---
9.	---	---
10.	---	---
11.	---	---
12.	---	---

REVISIONS

1.	ITEM	DATE
2.	---	---
3.	---	---
4.	---	---
5.	---	---
6.	---	---

SHEET TITLE

FIRE ACCESS PLAN

DRAWN DRH
CHECKED LND
PM RCS

PROJECT NUMBER
SHEET NUMBER

17195

C12